
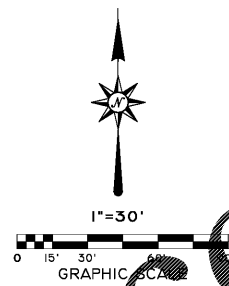


2017037 Proj: 17WHD02 - Tattersall Park - Main S.E. Exhibit Download by B. J. Wilson - 2.2.2017

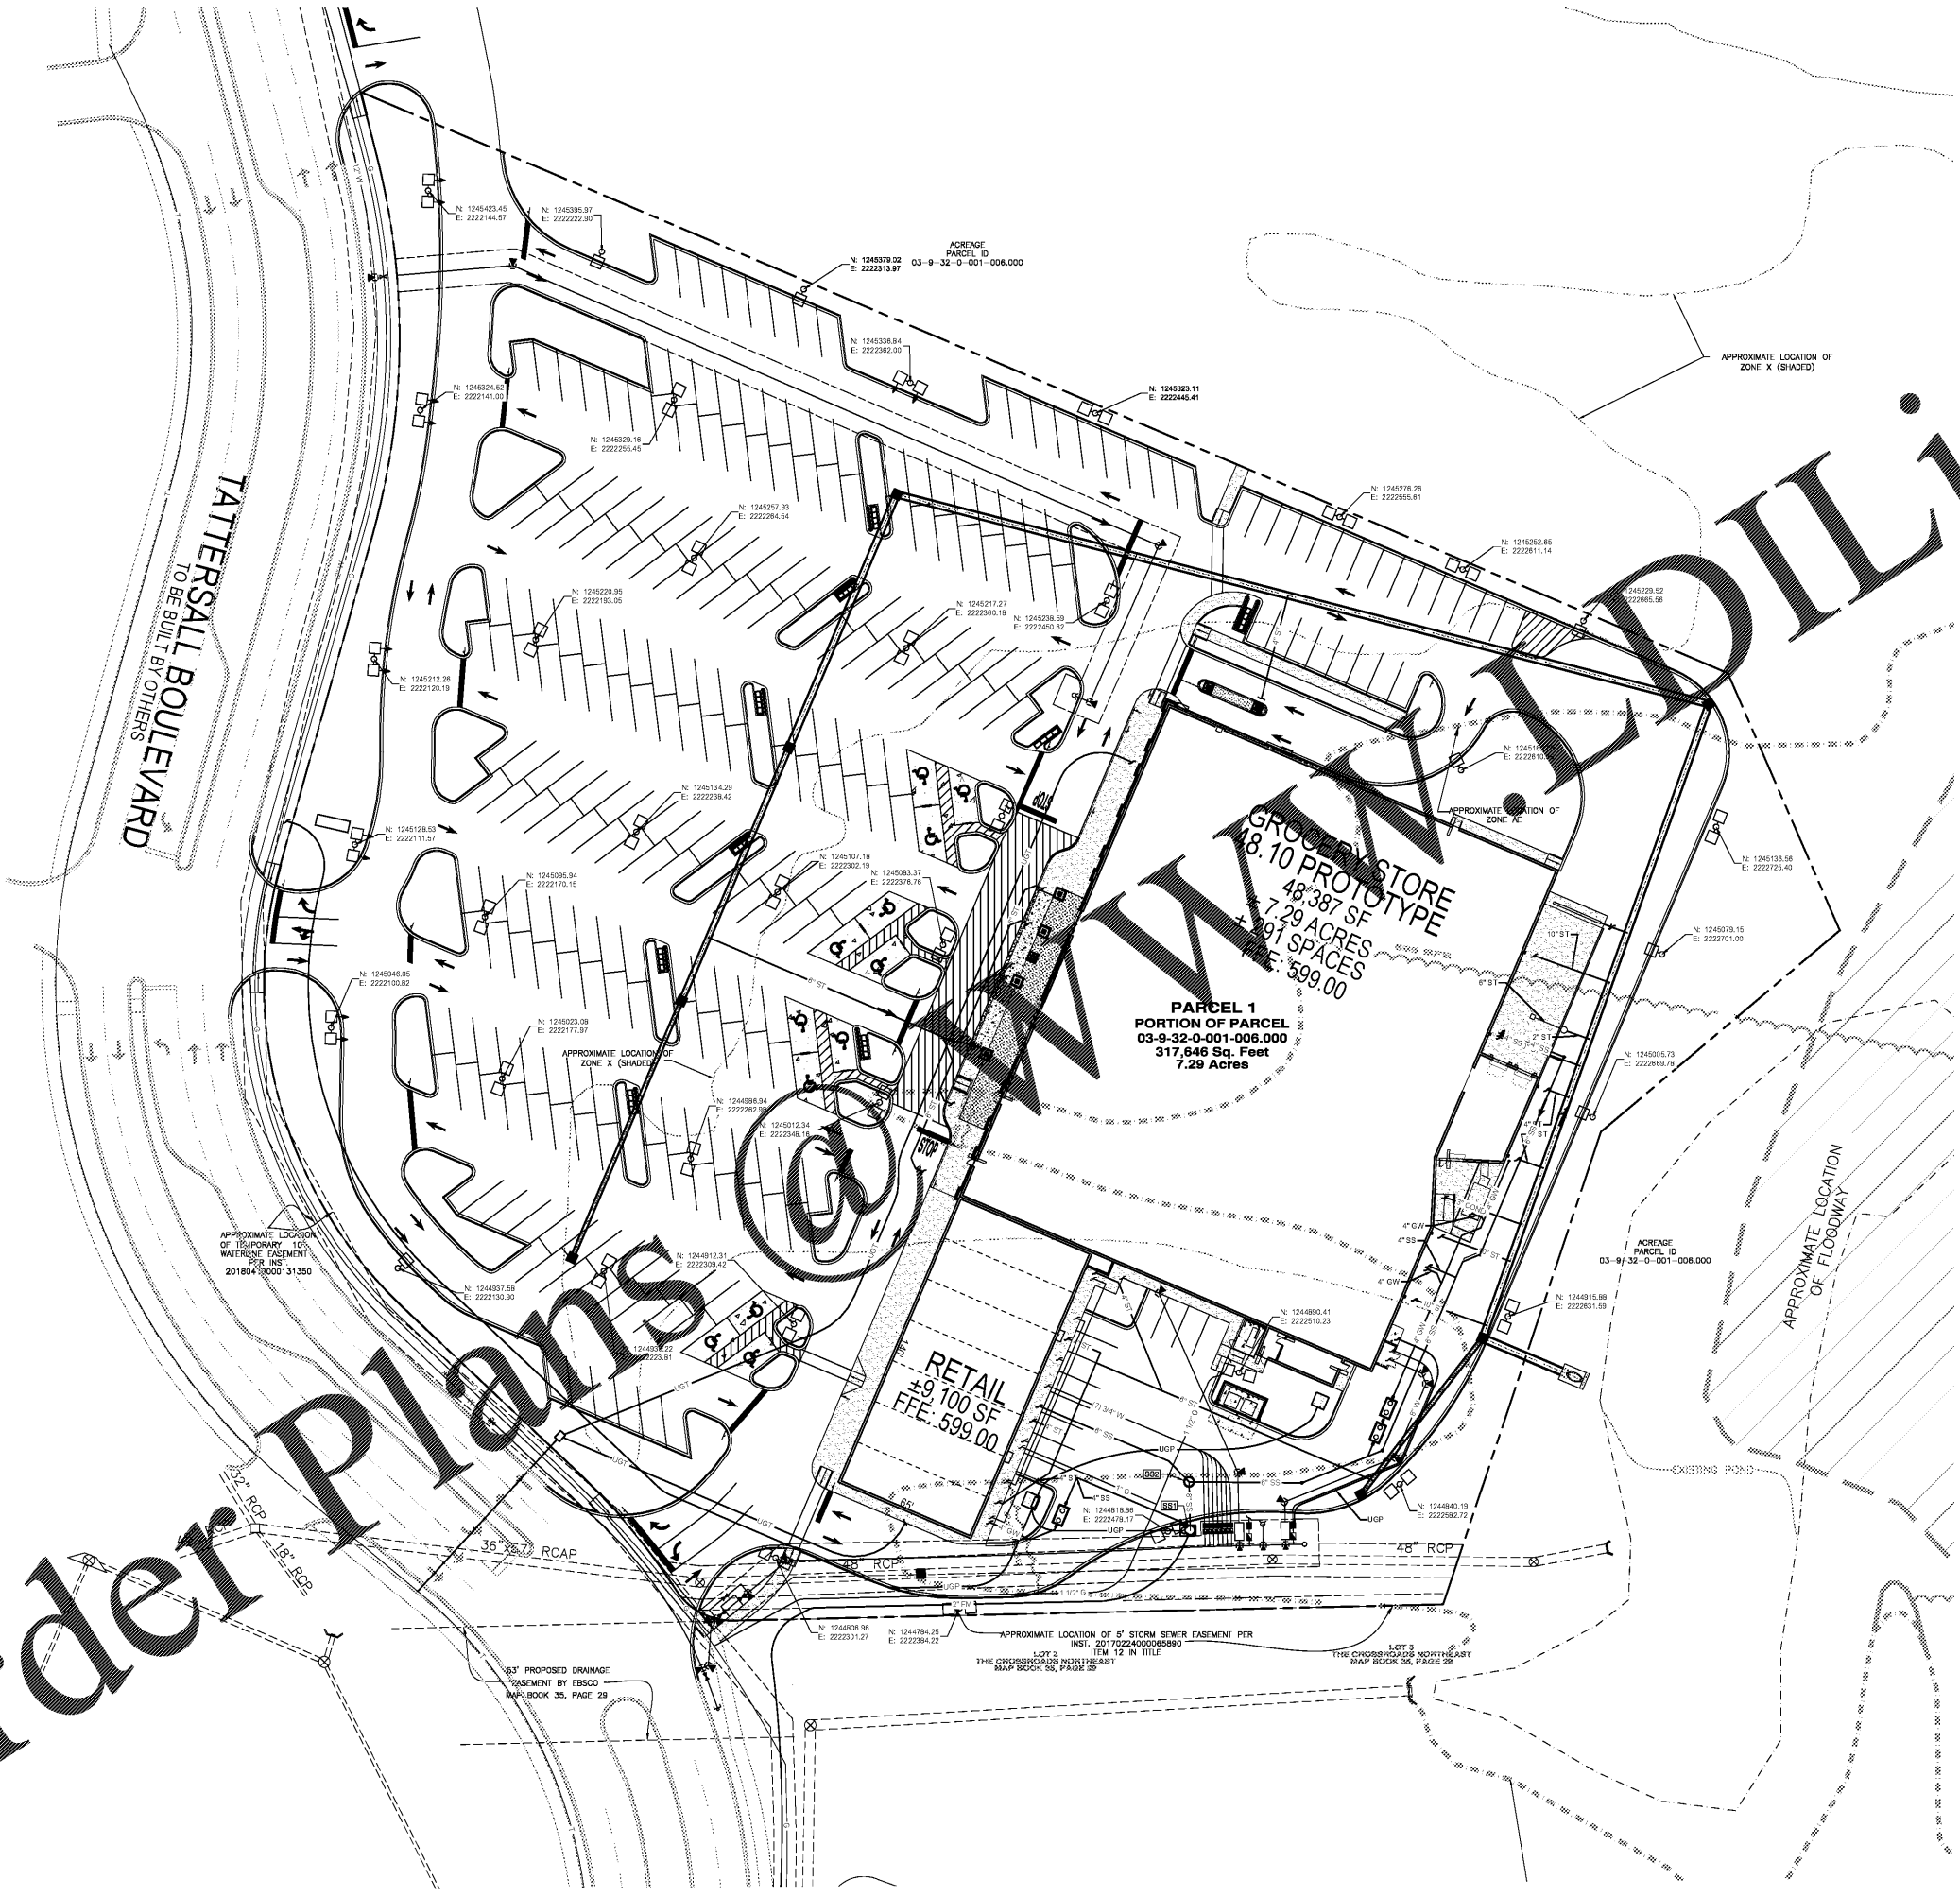

LIGHTING NOTES
1. ARCHITECT AND LANDSCAPE ARCHITECT TO PROVIDE ELECTRICAL PLAN.
2. LIGHT FIXTURES TO BE PROVIDED BY ELECTRICAL ENGINEER PRIOR TO INSTALLATION.
3. REVISIONS TO BE PROVIDED BY ELECTRICAL ENGINEER FOR MOUNTING HEIGHTS.
4. LIGHT FIXTURES SHALL BE LOCATED AT A MINIMUM OF 3 FEET BEHIND BACK OF CURB.

NO.	REVISIONS	DATE
0	ISSUED FOR APPROVAL	

TITLE
SITE LIGHTING PLAN
GROCERY STORE & SHOPS AT TATTERSALL PARK
TATTERSALL PARK
GREYSTONE WAY, LLC

DATE
SCALE
SEE PLANS

OWNED BY
A. WILSON

DESIGNED BY
B. WILSON, P.E.

GONZALEZ - STRENGTH & ASSOCIATES, INC.
CIVIL ENGINEERING, LAND SURVEYING, PLANNING, TRAFFIC & TRANSPORTATION
5176 PARKWAY LAKE DRIVE
TALLAHASSEE, FLORIDA 32310
PHONE: (904) 842-2486
FAX: (904) 842-3033
www.Gonzalez-Strength.com

© Copyright 2016



DWG. NO.
C10 - R0

PROJECT
17WHD02

Order Plans

Order Online.com