

PLOT DATE:  
August 21 2018

No.	Description	Date

STORE NUMBER

1687

Tattersall Park

US 280 & Highway 19

Hoover

Shelby Co., AL

48.10


VI814.2018

SIENNA LITE

HVAC ROOF  
PLAN

1/8" = 1'-0"

M4.1

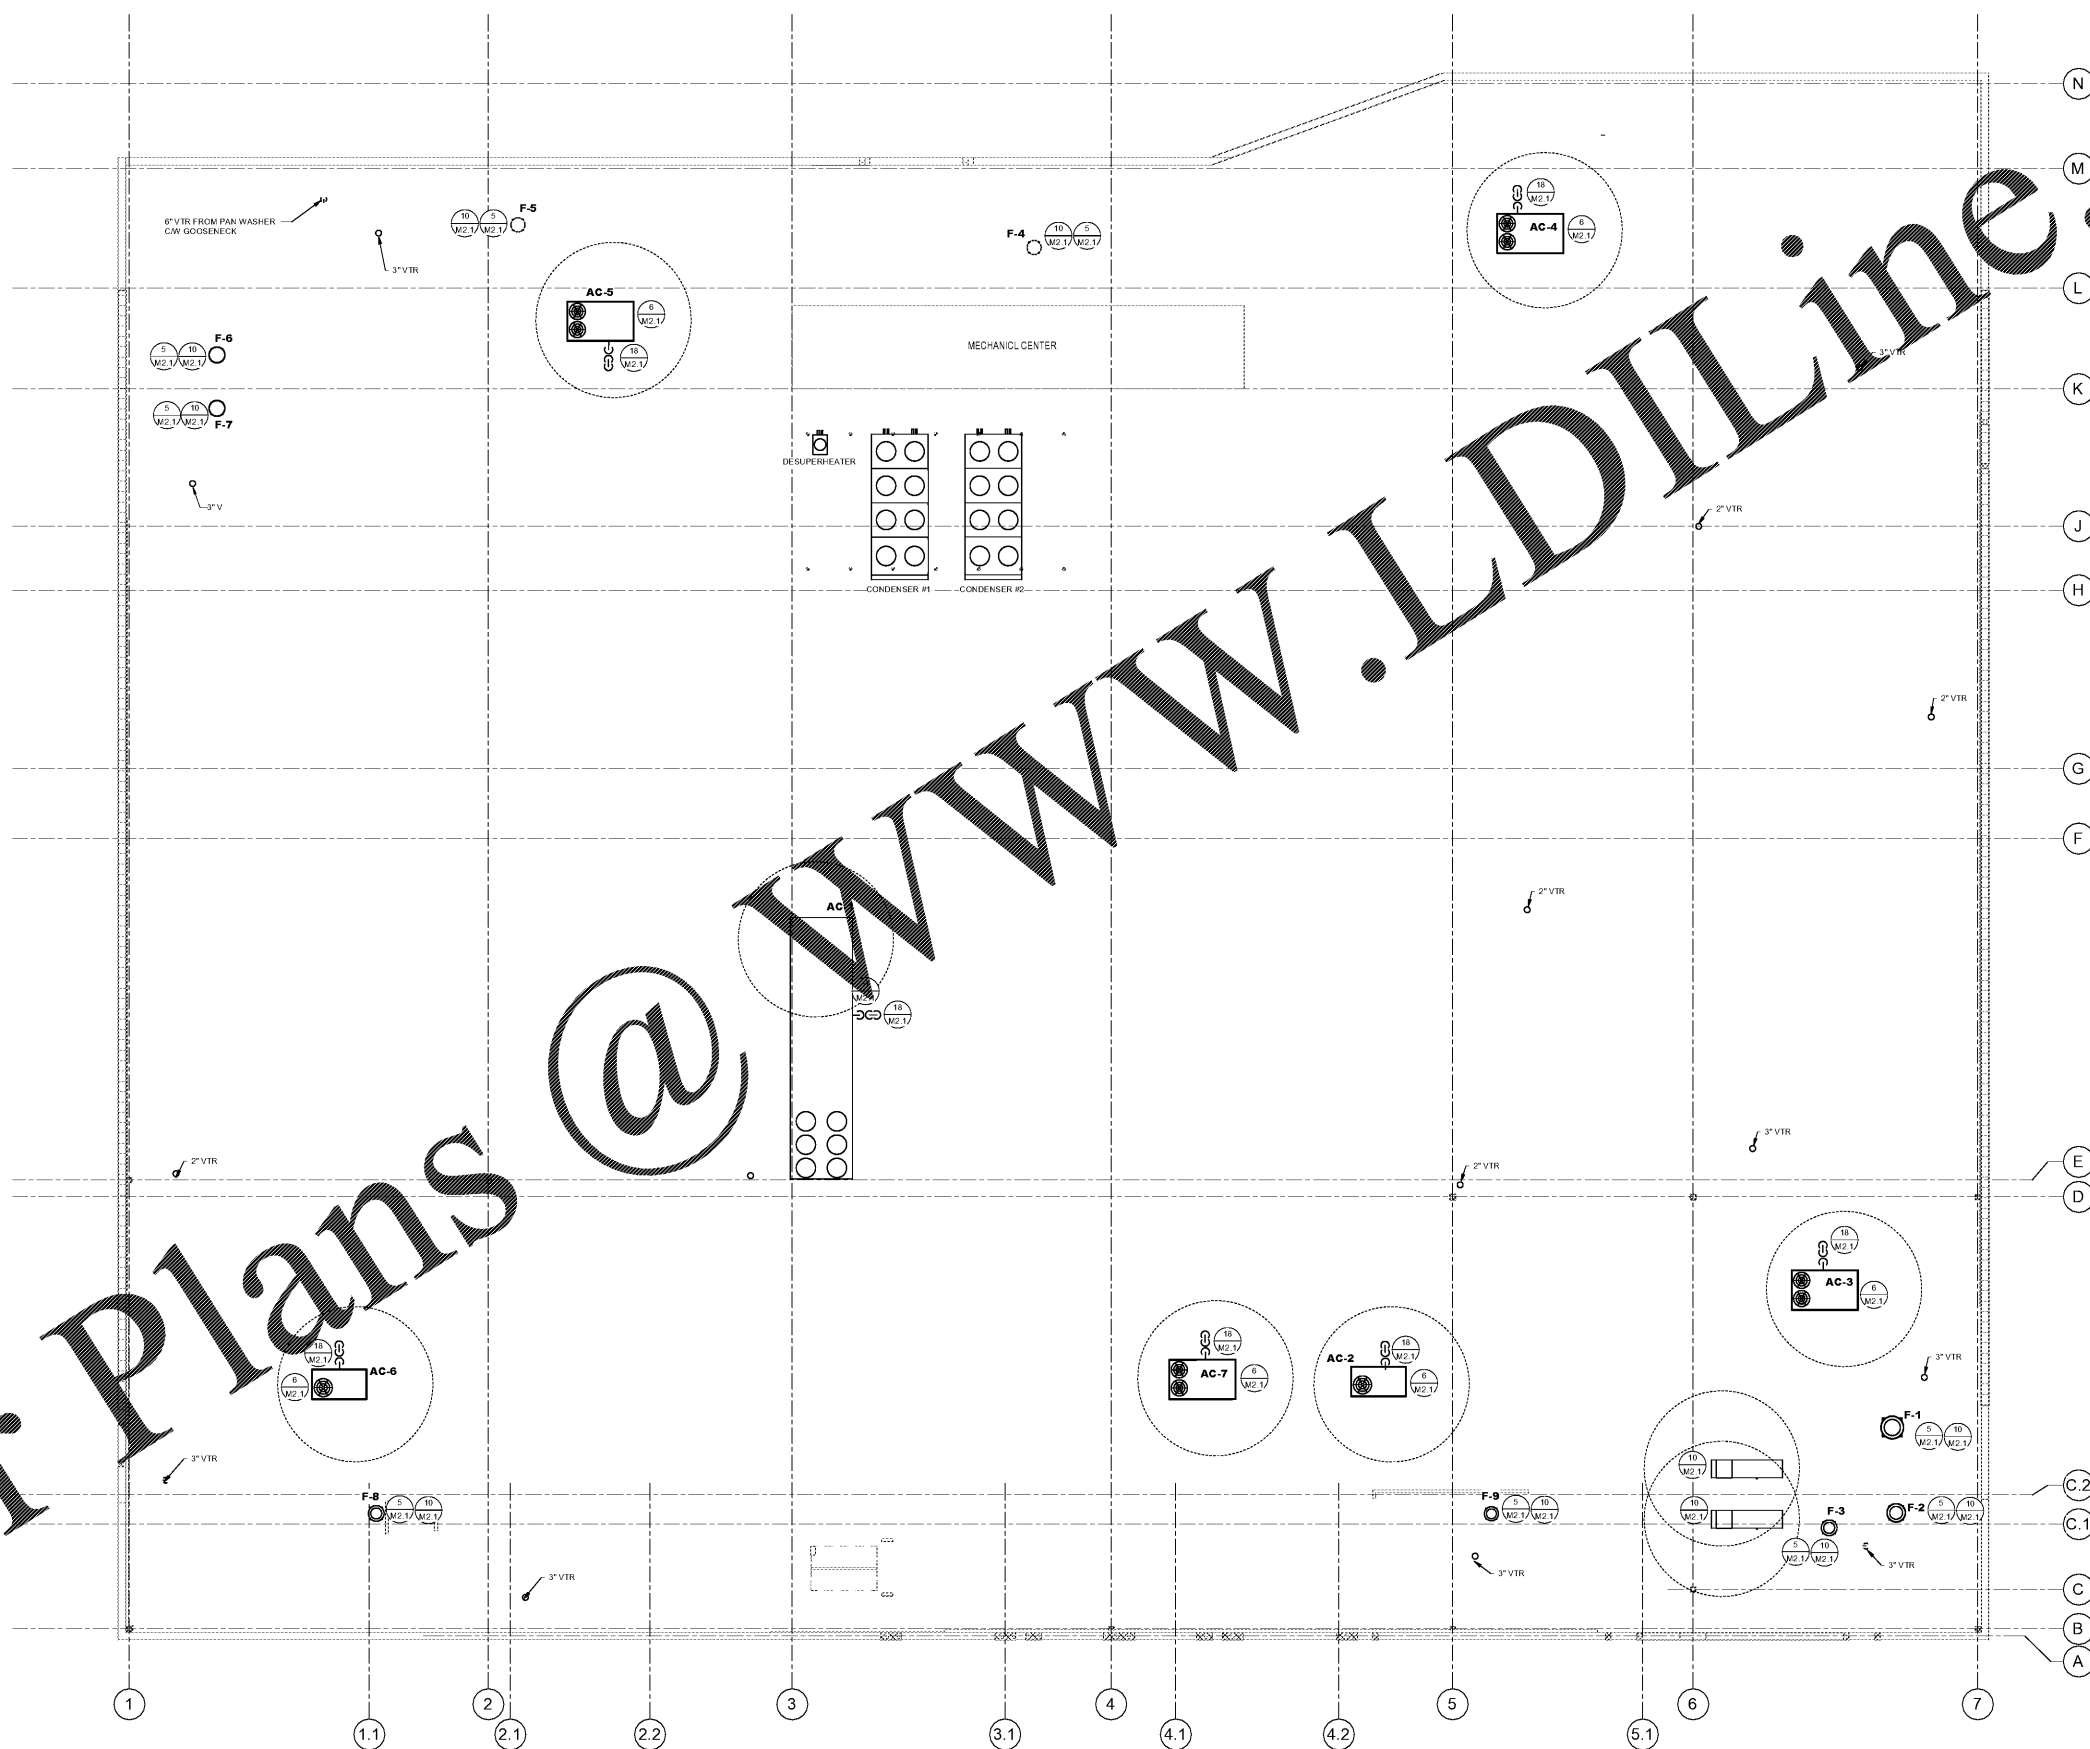

1 HVAC ROOF PLAN  
SCALE: 1/8" = 1'-0"