

PLOT DATE:  
August 21 2018

No.	Description	Date


STORE NUMBER  
**1687**  
Tattersall Park  
US 280 & Highway 19  
Hoover  
Shelby Co., AL

**48.10**  
7/26/2018  
SIENNA LITE


**ENLARGED  
REFRIGERATION  
PLANS**

As indicated

**R1.4**

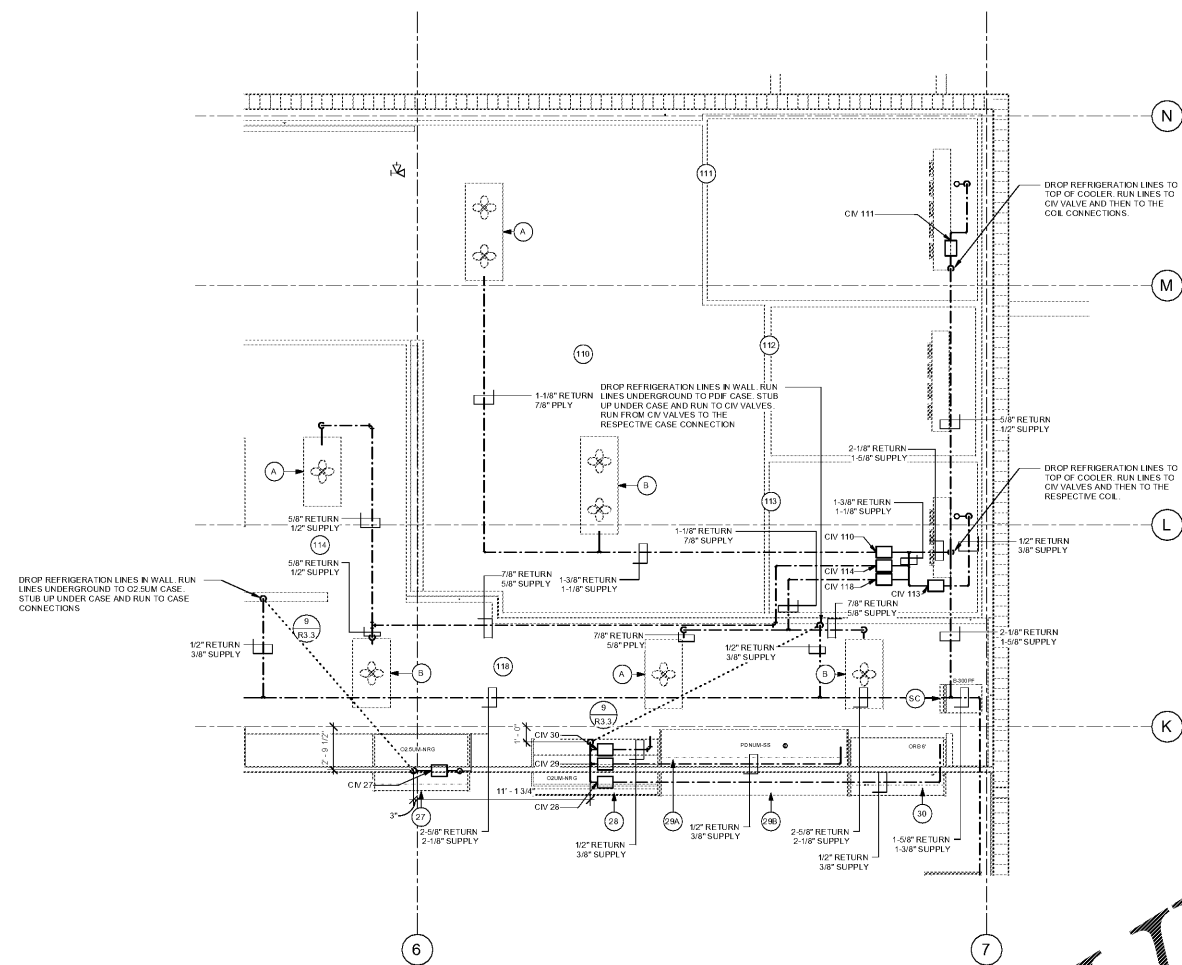

**1 ENLARGED MEAT/SEAFOOD/APRONS MT PIPING**  
SCALE: 1/4" = 1'-0"

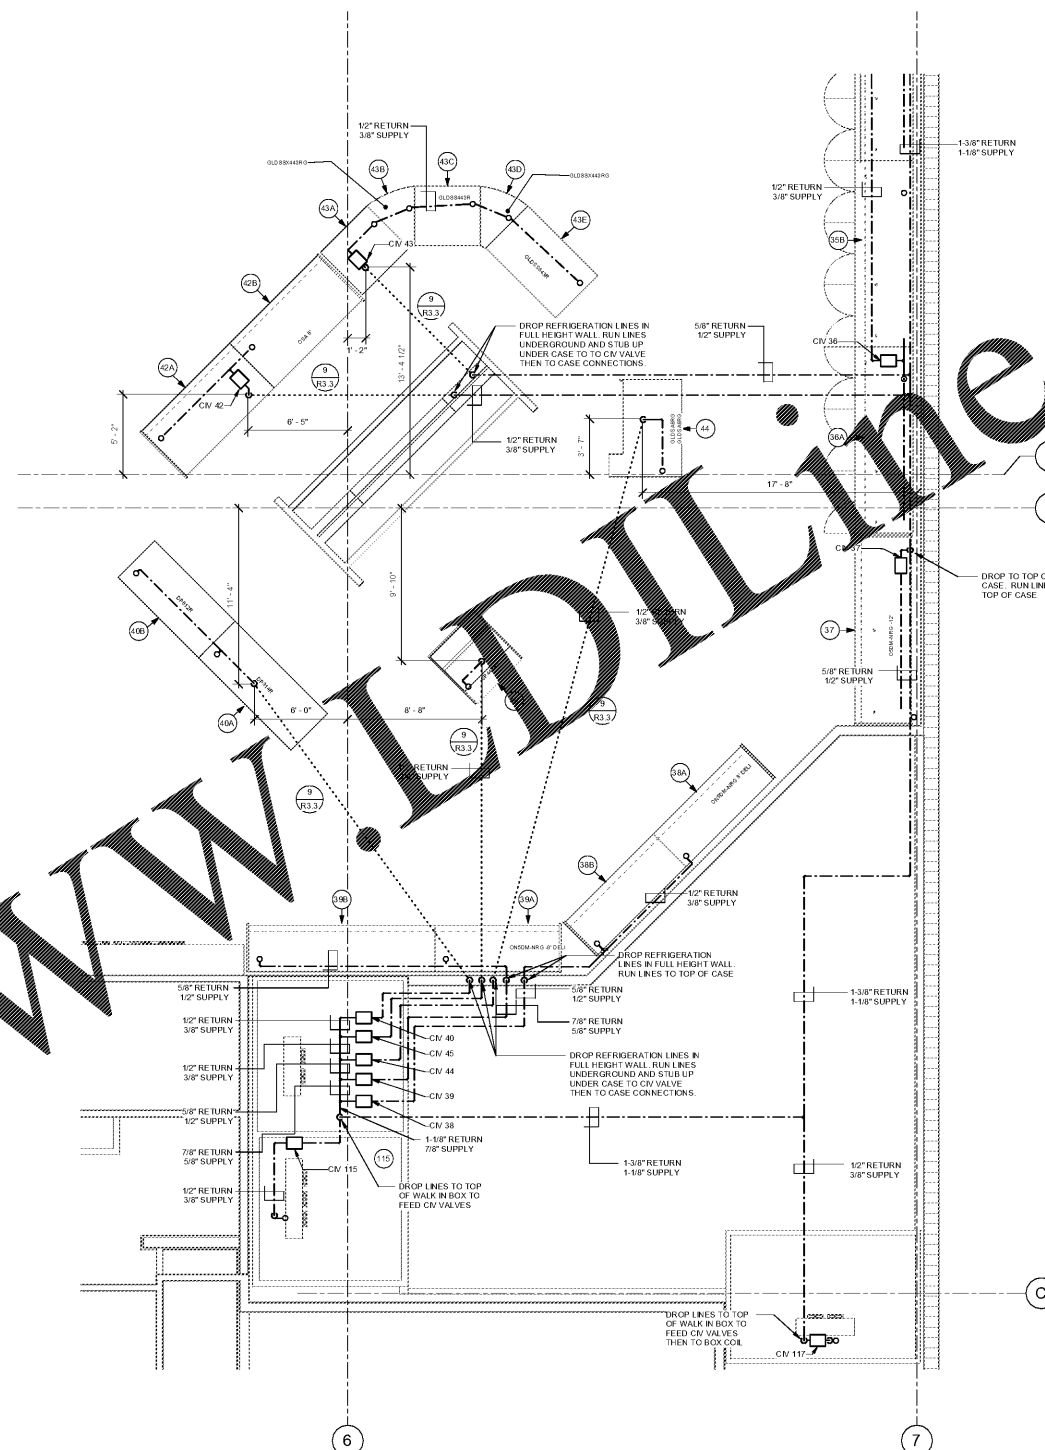

**2 ENLARGED DELI MT PIPING PLAN**  
SCALE: 1/4" = 1'-0"

PIPE SIZE	CO <sub>2</sub> INSULATION TABLE		
	MILD CONDITIONS 80°F DRY BULB 50% RH, 0 FPM	NORMAL CONDITIONS 65°F DRY BULB 70% RH, 0 FPM	SEVERE CONDITIONS 50°F DRY BULB 80% RH, 0 FPM
3/8"	1"	1 1/2"	2"
1/2"	1"	1 1/2"	2"
5/8"	1"	1 1/2"	2"
7/8"	1"	1 1/2"	2"
1 1/8"	1"	1 1/2"	2"
1 3/8"	1"	1 1/2"	2"
1 5/8"	1"	1 1/2"	2"

LEGEND	
---	MT LOOP #4 - CO <sub>2</sub> PUMP LIQUID OVERFEED LOOP #1 (<90°F LIQUID)
---	MT LOOP #4 - CO <sub>2</sub> PUMP LIQUID OVERFEED LOOP #1 (>90°F LIQUID)
---	MT UNDERGROUND LINES
□	CV (CIRCUIT ISOLATION VALVE) SEE DETAIL 1 ON R-3.3
○	REFRIGERATION SYSTEM NUMBER
⊕	SELF-CONTAINED CASE

Order Plans @ [www.dline.com](http://www.dline.com)