


Order Plans @

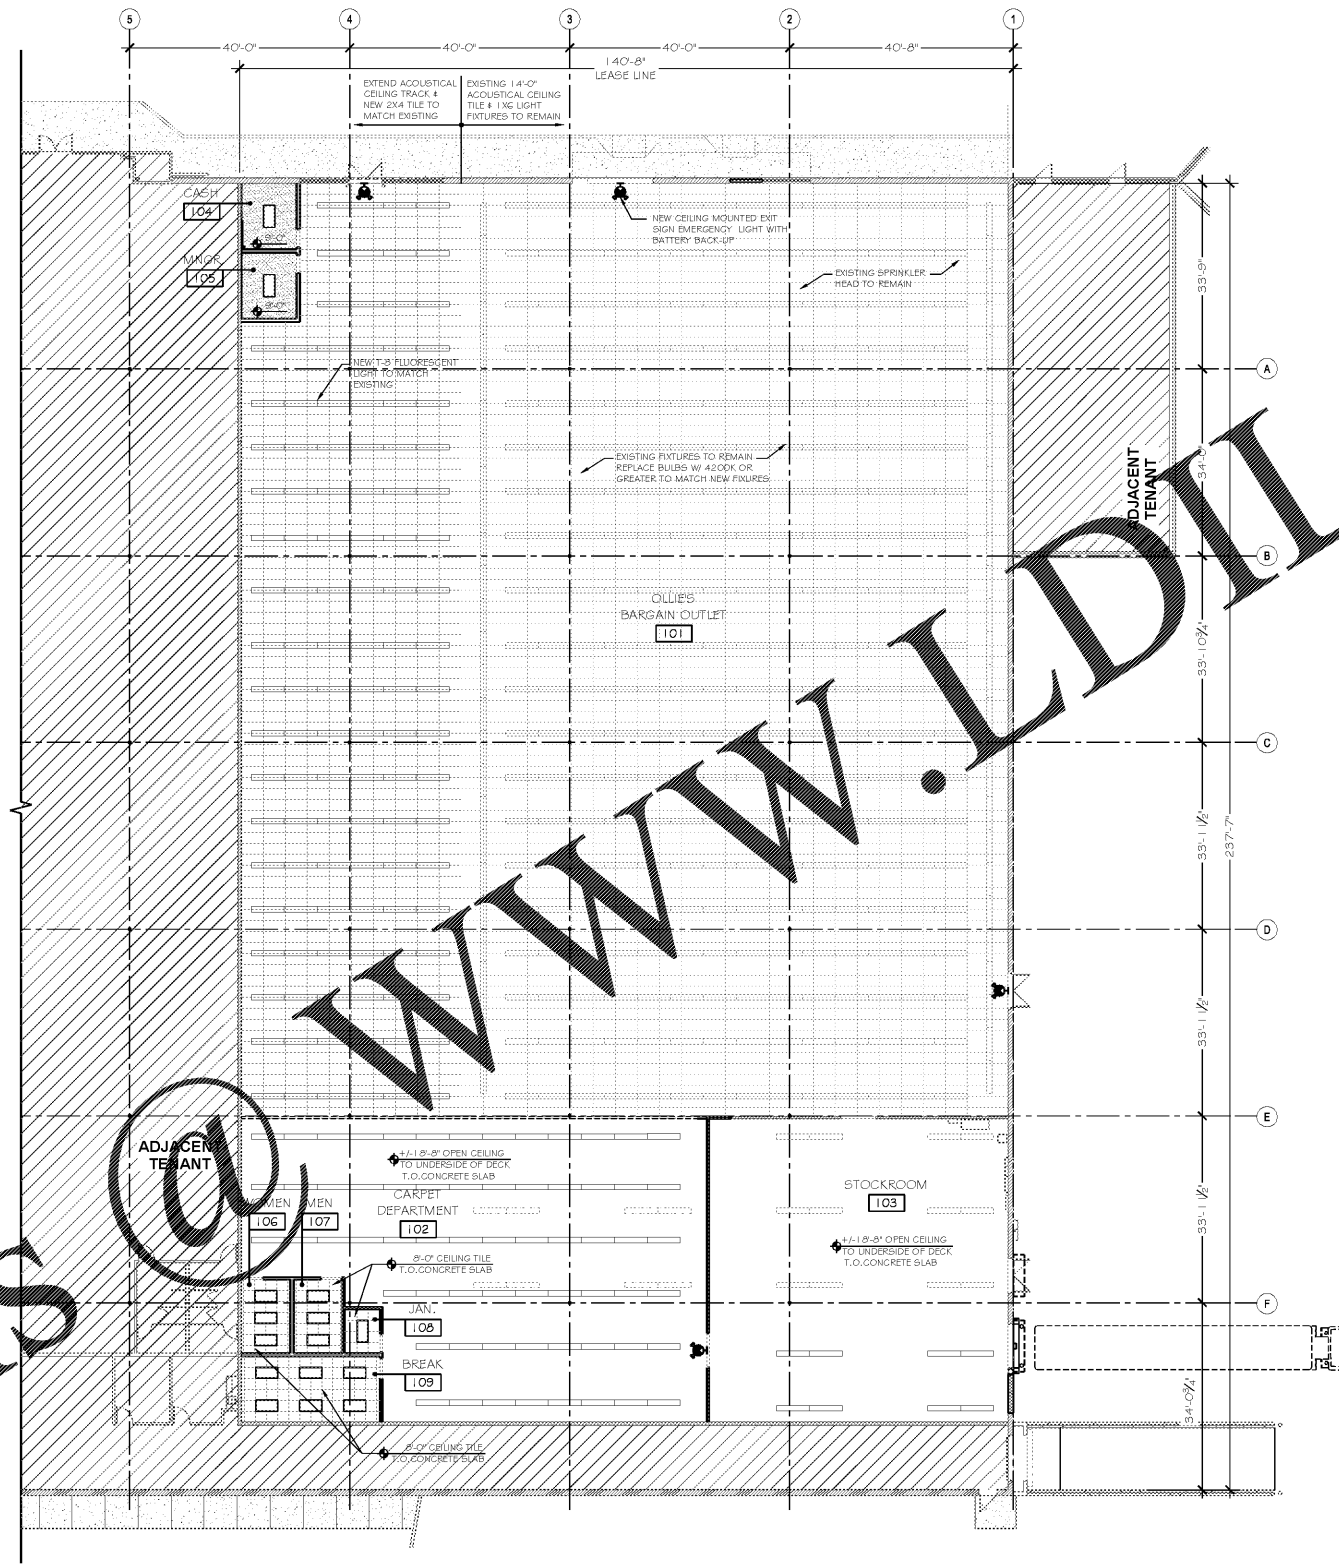

1 REFLECTED CEILING PLAN
1/16" = 1'-0"

WALL LEGEND

- NEW WALL
- EXISTING WALL
- EXISTING CMU WALL
- AREA NO WORK



JBG
JEFFERSON BROWNE
HAMPTON ARCHITECTS
1424 NORTH EXPRESSWAY, SUITE 146, 147A
GRIFFIN, GEORGIA 30203
PHONE: 770-433-1424
FAX: 770-433-1425

COORDINATION NOTE:
1. ELECTRICAL DRAWINGS SHALL TAKE PRECEDENCE OVER ARCHITECTURAL DRAWINGS. CONTRACTOR & ALL SUBCONTRACTORS ARE RESPONSIBLE FOR COORDINATING ARCHITECTURAL DRAWINGS WITH ELECTRICAL DRAWINGS. ANY DISCREPANCIES SHALL BE BROUGHT TO THE ATTENTION OF JEFFERSON BROWNE, INC. PRIOR TO ORDERING, FABRICATION OR INSTALLATION.

NOTE
SEE ELECTRICAL DRAWINGS FOR EMERGENCY LIGHTING AND SIGNAGE

SPECIFICATIONS:
CEILING TILE TYPE: 2x4 ARMSTRONG - CORTEGA
LIGHTS: T8 FLOURESCENT LIGHTS

CEILING LEGEND:

- 2x4' ARMSTRONG ACOUSTICAL CEILING GRID AND TILE
- GYPSON BOARD CEILING
- 2x4' T-8 FLUORESCENT LIGHT WITH ACRYLIC LENS
- GENERAL PURPOSE CHANNEL T-8 FLUORESCENT LIGHT TO REMAIN
- NEW GENERAL PURPOSE CHANNEL T-8 FLUORESCENT LIGHT
- GENERAL PURPOSE CHANNEL T-8 FLUORESCENT LIGHT TO BE REMOVED (SEE A-101 DEMOLITION PLAN)
- NEW CEILING MOUNTED EXIT SIGN EMLIGHT WITH BATTERY BACK UP
- EXHAUST FAN (SEE MECHANICAL DRAWINGS)
- SUPPLY (SEE MECHANICAL DRAWINGS)
- RETURN (SEE MECHANICAL DRAWINGS)

REVISIONS

| NO. | DESCRIPTION |
|-----|-------------|
| | |
| | |

OLLIE'S BARGAIN OUTLET
SPALDING VILLAGE
1424 NORTH EXPRESSWAY, SUITE 146, 147A
GRIFFIN, GEORGIA 30203

STATE OF GEORGIA
PAUL LEE GRESHAM
REGISTERED ARCHITECT
9/24/18
SEAL

SEPTEMBER 24, 2018
PERMIT DOCUMENTS
RELEASED FOR CONSTRUCTION
RELEASE DATE

REFLECTED CEILING PLAN

DRAWING TITLE
© COPYRIGHT 2018 JEFFERSON BROWNE GRESHAM ARCHITECTS INC. THIS DOCUMENT AS AN INSTRUMENT OF SERVICE REMAINS THE PROPERTY OF JEFFERSON BROWNE ARCHITECTS AND NO PART THEREOF MAY BE REPRODUCED IN ANY FORM WITHOUT WRITTEN PERMISSION FROM JEFFERSON BROWNE ARCHITECTS

Drawn By: _____
Checked By: _____
PROJECT # A-103
18-2671 SHEET 06 of 15