


PROJECT NO: 0419739-002
 DRAWN BY: CM
 CHECKED BY: RM

ISSUE:	DATE:
PERMIT SET	07-27-18
REVISION:	DATE:

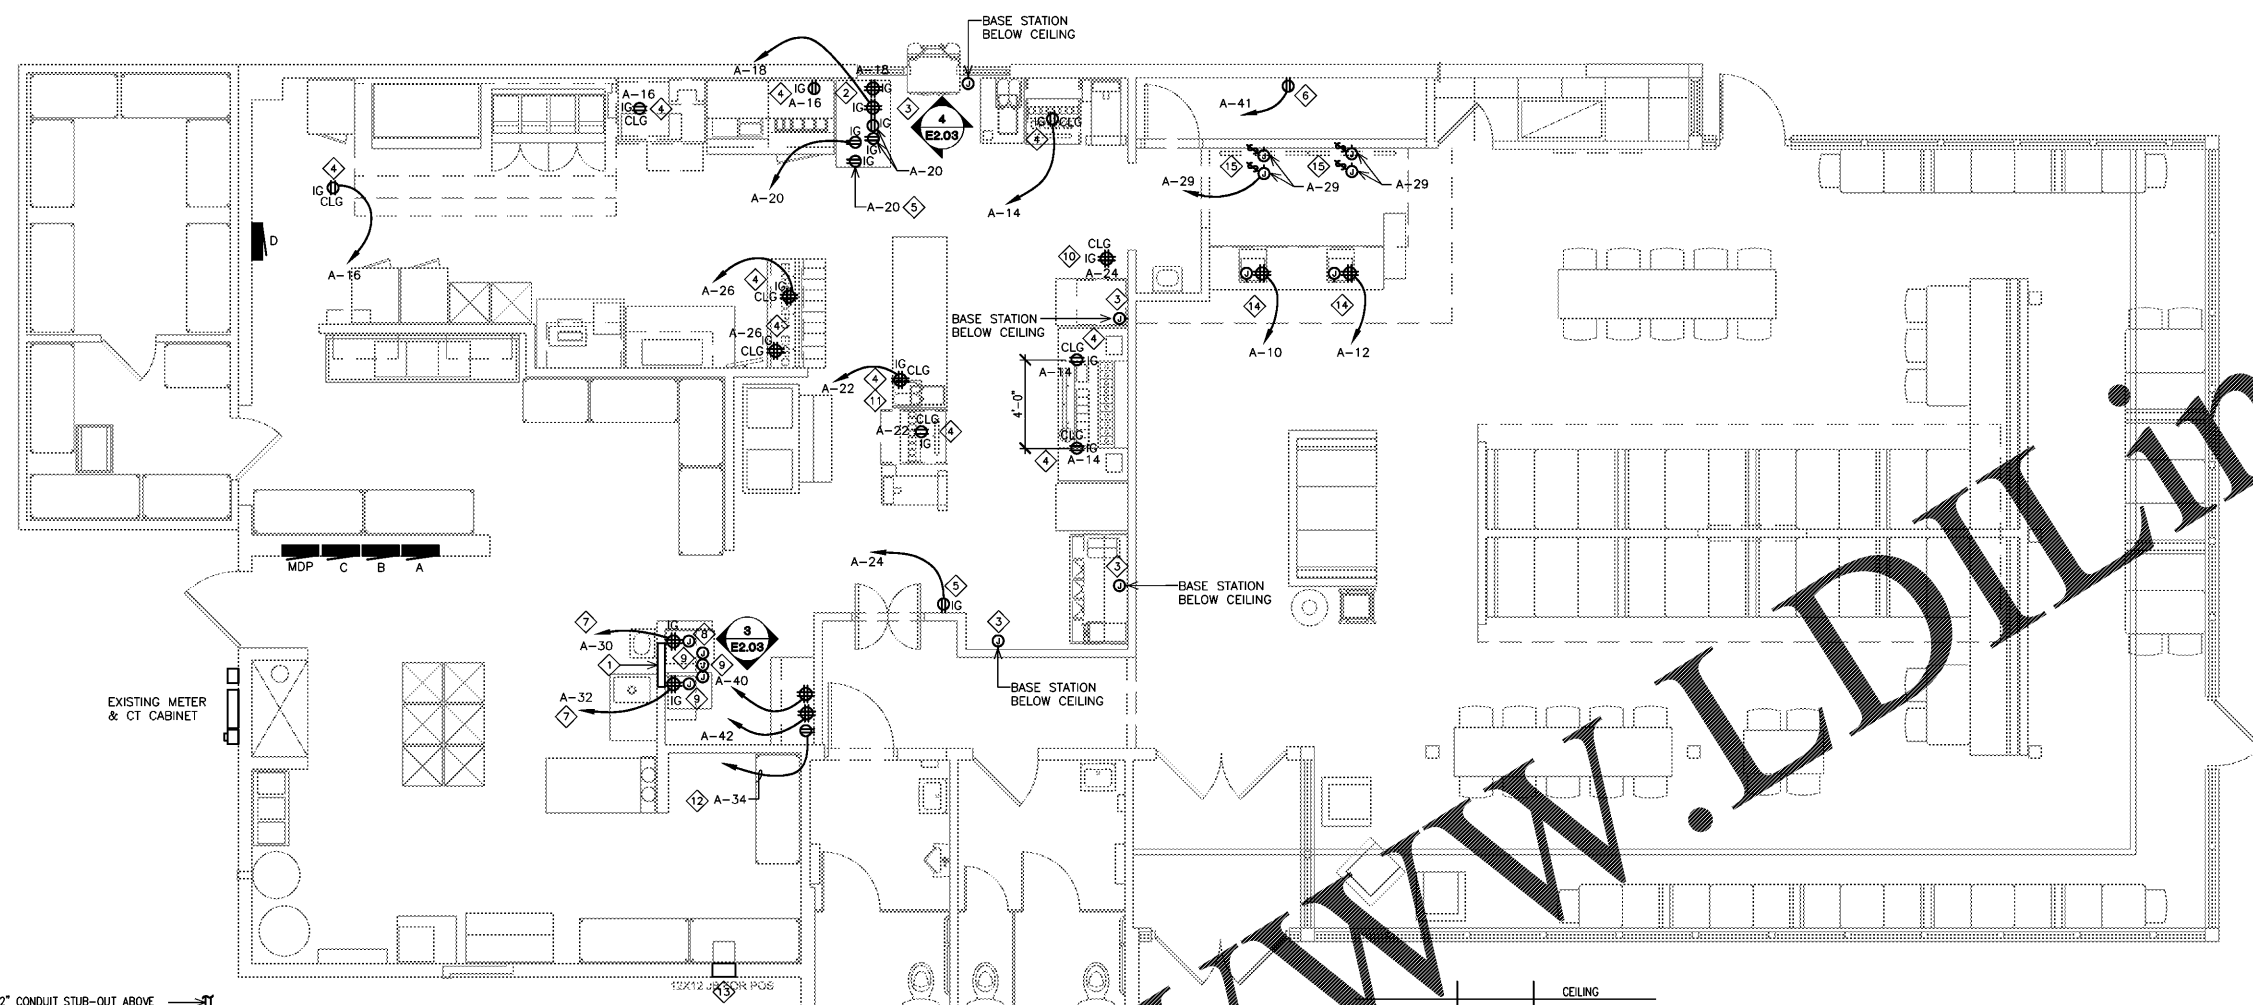

1 POS POWER PLAN
 E2.03 SCALE: 1/4"=1'-0"


POS Site Ready Criteria

Inside Store:

- Ceiling grid finished.
- Ceiling tile in grid where monitors and power is located.
- Power in place in walls and ceiling (Operating).
- Kitchen equipment/Furniture in place and set.
- Sonic management authority of store to confirm placement of all equipment.
- Telephone service operational.



Outside Store:

- Underground conduit in place and correct size.
- Canopy conduit in place and correct size.
- Canopy structure pointed.
- Menu housings bracket welded with MC power flex conduit in place & operational.
- All concrete for Canopies, patio, drive-thru complete.
- Label pull-strings (each end) on underground PVC conduit.

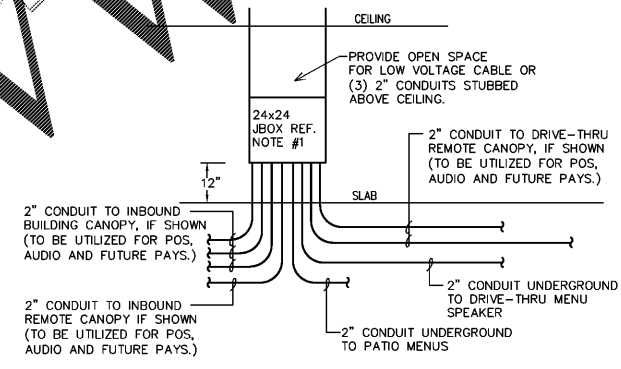


2 POS JBOX DIAGRAM
 E2.03 SCALE: NONE

- KEY NOTES:**
- INSTALL 24"Hx24"Wx4"D J-BOX 12" A.F.F. TO BOTTOM OF J-BOX WITH ACCESSIBLE COVER (1) 2" CONDUIT FED FROM MAX. 8 STALLS (ie: 22 STALLS = (3) 2" CONDUITS) FOR DATA CABLE. SEE SHEET E-1.01 FOR POWER PLAN TO CANOPIES. SEE DETAIL 2/E2.03. (1) 2" CONDUIT FED FROM SPEAKER PEDESTAL AT DRIVE THRU. SEE SHEET "E1.01" FOR POWER PLAN TO DRIVE THRU MENU BOARD. (1) 2" CONDUIT FED FROM PATIO MENUS. REFERENCE "E1.01" SITE PLAN.
 - PROVIDE POWER TO SCANNER/ PRINTER AT DRIVE THRU- ISOLATED GROUND TYPE ORANGE RECEPTACLE. CIRCUIT SHALL HAVE ISOLATED GROUND WIRE.
 - PROVIDE A JUNCTION BOX 8" BELOW FINISHED CEILING WITH A 1" CONDUIT STUBBED ABOVE ACCESSIBLE CEILING FOR WIRELESS BASE STATION.
 - PROVIDE POWER TO MONITORS - ISOLATED GROUND TYPE ORANGE DUPLEX OR QUAD RECEPTACLES AS SHOWN MOUNTED IN FACE OF CEILING PANELS OR WALL AS INDICATED. CIRCUIT SHALL HAVE ISOLATED GROUND WIRE. PROVIDE 4' TO 6' SLACK OF MC CABLE ABOVE CEILING. VERIFY EXACT PLACEMENT OF MONITORS.
 - PROVIDE WALL MOUNTED ISOLATED GROUND DUPLEX RECEPTACLE FOR SWITCHBOARD. MOUNT AT 48" A.F.F. CIRCUIT SHALL HAVE ISOLATED GROUND WIRE.
 - PROVIDE WEATHERPROOF J-BOX WITH CONDUIT STUBBED THROUGH WALL FOR PAY STATION AT 36" A.F.F. WITH A DUPLEX RECEPTACLE MOUNTED ON THE INTERIOR. VERIFY EXACT LOCATION AND REQUIREMENTS PRIOR TO ROUGH-IN.
 - PROVIDE POWER TO CPU RACK UNIT - ISOLATED GROUND TYPE ORANGE QUAD RECEPTACLES. CIRCUIT SHALL HAVE ISOLATED GROUND WIRE.
 - DEDICATED PHONE LINE FOR COMPUTER MODEM (36" AFF). RED COVER PLATE "COMPUTERS ONLY", ALSO PROVIDE STANDARD PHONE OUTLET (50" AFF).
 - PROVIDE J-BOX SIZED TO ACCEPT 2" CONDUIT. STUB 2" CONDUIT 8" ABOVE CEILING.
 - PROVIDE ISOLATED GROUND QUAD RECEPTACLE MOUNTED IN CEILING FOR SCANNER AND POS EQUIPMENT.
 - PROVIDE POWER TO PRINTER - ISOLATED GROUND TYPE ORANGE DUPLEX RECEPTACLE. CIRCUIT SHALL HAVE ISOLATED GROUND WIRE. PROVIDE 4' TO 6' SLACK IN MC CABLE. VERIFY EXACT LOCATION PRIOR TO INSTALLATION.
 - PROVIDE POWER FOR ROUTERS - ISOLATED GROUND TYPE ORANGE RECEPTACLES. CIRCUIT SHALL HAVE ISOLATED GROUND WIRE. MOUNT RECEPTACLE HORIZONTALLY AT 8'-6" A.F.F.
 - POS EXTERIOR JUNCTION BOX RECESSED IN WALL STUBBED UP ABOVE DROP CEILING APPROXIMATELY 103" A.F.F. FOR PAYS ANTENNA.
 - E.C. TO INSTALL EQUIPMENT FOR MENU BOARDS PER MFG. RECOMMENDATION.
 - PROVIDE QUAD RECEPTACLE AND DATA FOR POS. STUB DATA ABOVE KITCHEN CEILING. VERIFY ALL OTHER REQUIREMENTS WITH POS VENDOR PRIOR TO ROUGH-IN.

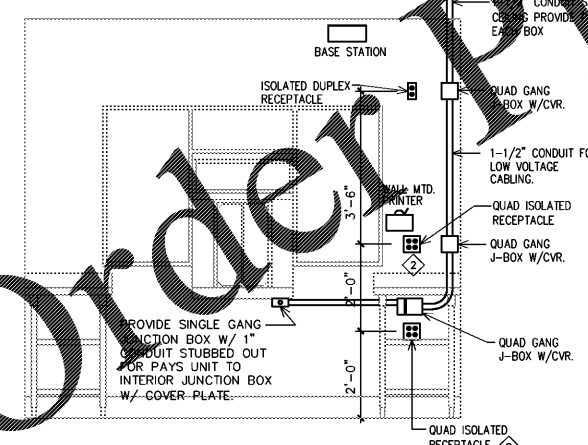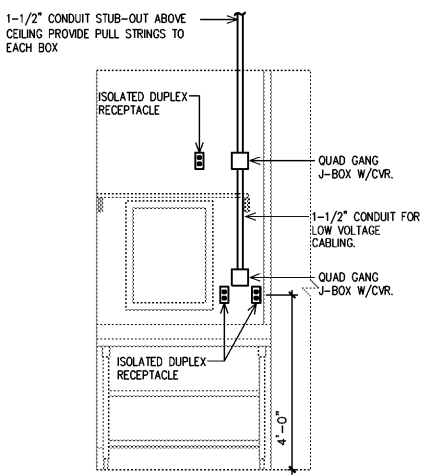

4 POS ELEVATION AT DRIVE THRU
 E2.03 SCALE: 1/2"=1'-0"

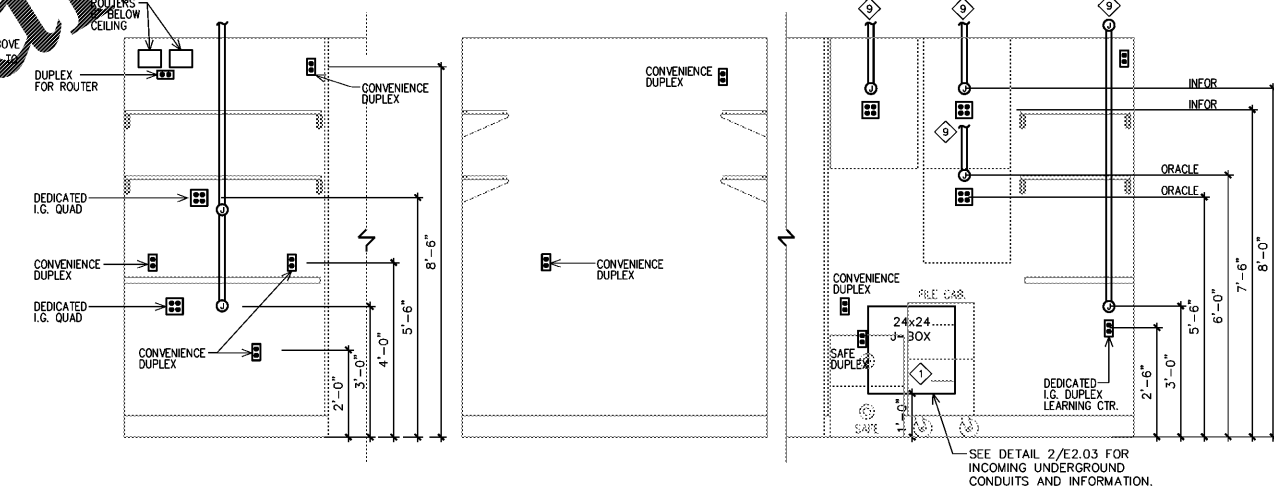

3 POS ELEVATIONS AT OFFICE
 E2.03 SCALE: 1/2"=1'-0"

Order Plans @

WWW.LDLINE.COM