

# KEYED NOTES:


- 1 400 AMP 120/208 3 PHASE ELECTRIC PANEL AND SERVICE  
1 1" TELEPHONE SERVICE CONDUIT STUBBED OUT
- 2 200 AMP 3 PHASE SERVICE AND PANEL  
1 1" TELEPHONE SERVICE CONDUIT STUBBED OUT
- 3 HOUSE PANEL  
100 AMP 120/208 V 3 PHASE PANEL
- 4 DEDICATED CIRCUIT TO SIGN ABOVE EACH DOOR -TYP
- 5 WATER PROOF SPEAKERS ATTACHED TO WALL
- 6 METER BANK
- 7 WATER PROOF OUTLET FOR HOLIDAY LIGHTS AT TRELLIS UP HIGH
- 8 REMOTE HEAD AT EACH EXTERIOR EXIT DOOR OFF OF COMBO INSIDE -BATTERY BACK UP

ENERGY CALCULATIONS SUBMITTED AS PART OF EACH TENANT BUILD OUT  
AS FINAL AC LOADS MAY CHANGE

LIGHT FIXTURE DESCRIPTION			
SYMB	MANF	PART #	DESCRIPTION
[Symbol]	LITHONIA	STLED ST SERIES	
[Symbol]	LITHONIA	ELMMT	
H1 WALL PACK	HUBBELL LAREDO OR EQUAL LCC -LED 42F8 42 W CFL FULL CUTOFF WALL PACK, BRONZE WITH BATTERY BACK UP FOR 90 MINUTES MIN. - SUBMIT SAMPLE FOR APPROVAL		
[Symbol]	ORION	MFEXIT2LPDUAL	EMERGENCY LIGHT/EXIT COMBO (2) HEADS
[Symbol]	LITHONIA	ECR-LED-M6	
[Symbol]	ARIEL SHADE H-1216 16" SHADE BURNT BRASS 88 WAREHOUSE-LIGHTING.COM- CONTRACTOR TO ACQUIRE LIGHT SAMPLE FOR CLIENTS APPROVAL		LED DECORATIVE GOOSE NECK
H11 UPPER WINDOW LIGHTS			LED LIGHT FIXTURE ON TIMER
[Symbol]	LITHONIA	LDN3 ROUND SERIES - 3" - BLACK COLOR	
[Symbol]	LITHONIA	LDN6 ROUND SERIES	6" DIA WHITE RECESSED CAN LED LIGHT

CONTRACTOR TO PROVIDE SPECS AND CUT SHEETS ON ALL EXTERIOR LIGHTS FOR ZONING AND BUILDING DEPARTMENT APPROVAL  
CONTRACTOR TO VERIFY WITH ELECTRICIAN THAT ALL LIGHTS ARE ACCEPTABLE AND ABLE TO BE INSTALLED WITH ISSUE PRIOR TO ORDERING

LEGEND	
SM	MOTION SENSOR SWITCH
[Symbol]	125V NEMA 5-20R DUPLEX. PANEL/CIRCUIT IN PANEL
A/23	125/250V NEMA L14-20-R 4 PRONG TWIST LOCK
[Symbol]	125V NEMA 5-20R QUAD.
[Symbol]	DISCONNECT
[Symbol]	BLACK MAGIC POWER POLE
[Symbol]	PHONE JACK @ REGISTER
[Symbol]	VOICE/DATA PORT = RJ-11, RJ-45 DATA JACK, PHONE COMBO @ OFFICE
A/23	PANEL/CIRCUIT IN PANEL
\$m	PROVIDE OCCUPANCY LIGHT SENSOR- LEVITON ODS10-IDW
\$	20 AMP TOGGLE SWITCH
NL	NIGHT LIGHT CIRCUIT

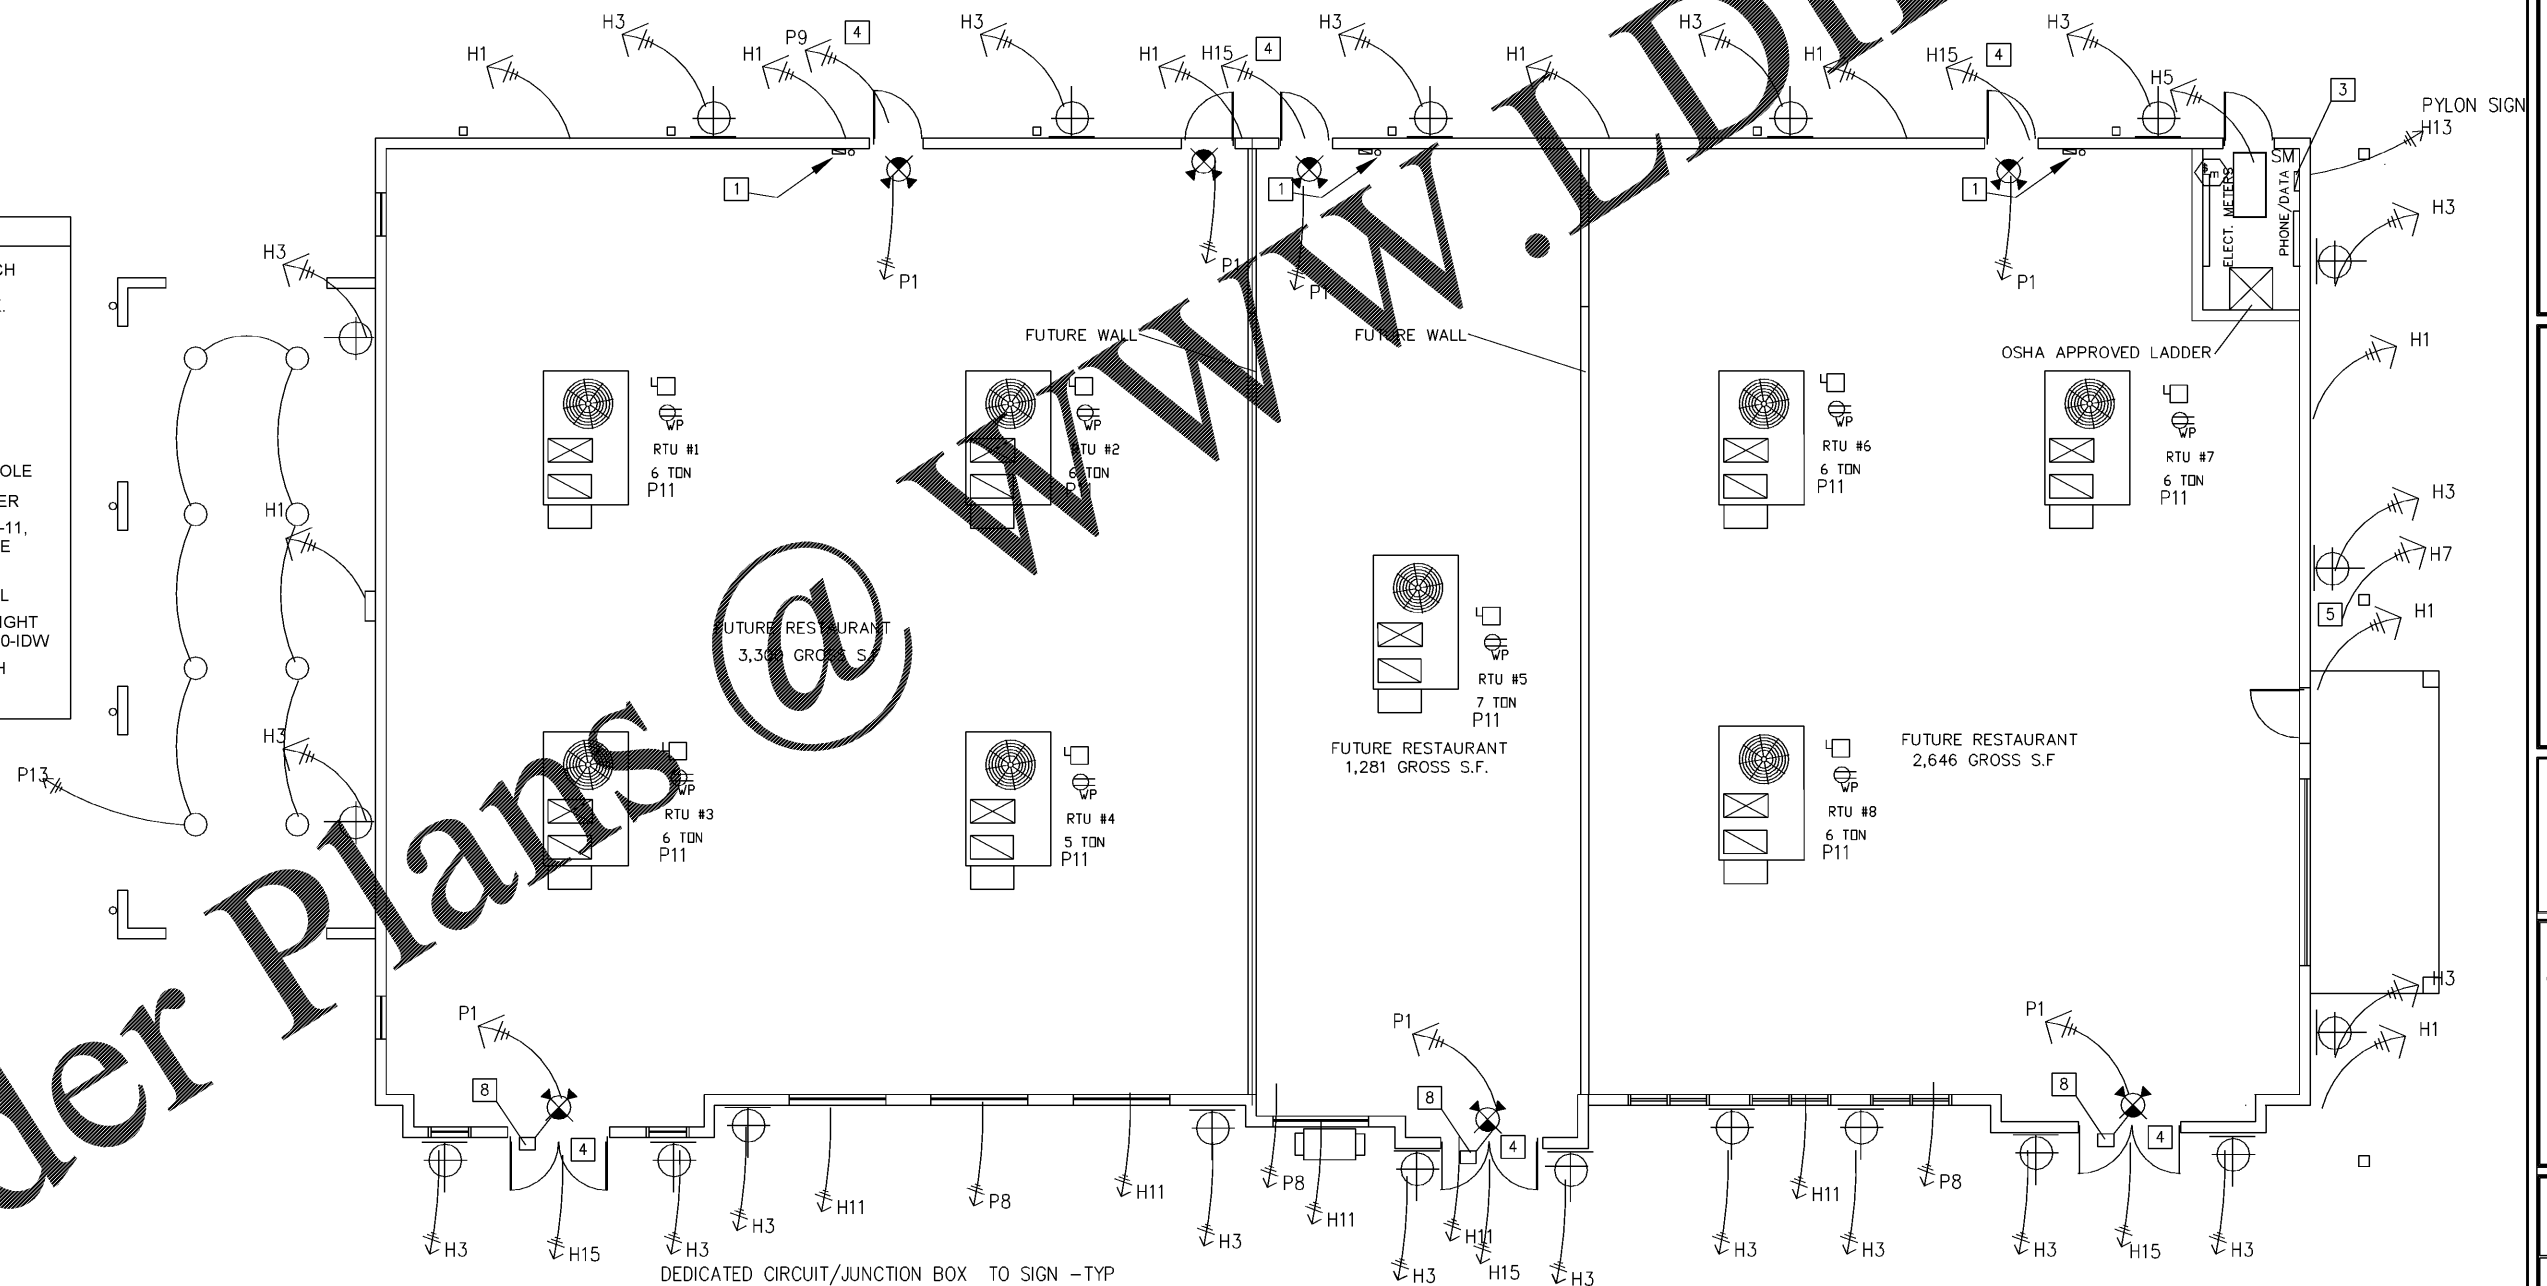

## POWER/LIGHTING PLAN - BUILDING 1

SERVICE OF KNIGHTS ELECTRICAL LLC  
KYLAN KNIGHT - DRAWN BY JW 904 334-9379  
ERI 301-5329  
324 N 6TH AVE N., JACKSONVILLE BEACH, FL., 32250

JOYCE DEVELOPMENT GROUP

BUILDING 1  
BRANAN FIELD WALK  
MIDDLEBURG, FLORIDA  
POWER AND LIGHTING PLAN

DATE	REVISIONS

Date: 10/1/2018  
Scale: 3/16" = 1'-0"  
Drawn:  
Checked:  
Sheet No:  
**E-1**  
- OF -