


MULHERIN CUSTODIAL HOME

2496 HALLS MILL ROAD
MOBILE, ALABAMA 36606



1000 Housley Street
Mobile, Alabama 36606
TEL: 251.433.9600

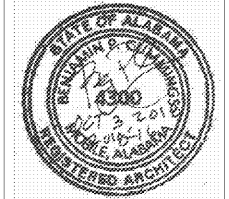


Mulherin Custodial Home
2496 Halls Mill Road
Mobile, AL 36606

INDEX OF DRAWINGS

NUMBER	SHEET NAME	NUMBER	SHEET NAME	NUMBER	SHEET NAME	NUMBER	SHEET NAME	NUMBER	SHEET NAME
T	TITLE SHEET	S7.0	SECTIONS AND DETAILS	A1.3	ATTIC PLAN & FINISH SCHEDULE	A5.3	INTERIOR ELEVATIONS	M7.0	HVAC DETAILS
BCS	BUILDING CODE SUMMARY	S8.0	SECTIONS AND DETAILS	A1.4	DIMENSION PLAN	A6.1	CASEWORK SECTIONS		
LSP	LIFE SAFETY PLAN	S9.0	SECTIONS AND DETAILS	A1.5	REFLECTED CEILING PLAN	A6.2	DOOR & WINDOW DETAILS	E1.0	ELECTRICAL LEGEND
				A1.6	ROOF PLAN	A7.1	DOOR AND WINDOW SCHEDULES	E2.0	ELECTRICAL SPECIFICATIONS
C1	COVER/INDEX	A0.1	ARCHITECTURAL SPECIFICATIONS	A2.1	EXTERIOR ELEVATIONS			E3.0	ELECTRICAL SITE PLAN
SURVEY	EXISTING CONDITIONS	A0.2	ARCHITECTURAL SPECIFICATIONS	A2.2	EXTERIOR ELEVATIONS	F1.0	PLUMBING SCHEDULES & NOTES	E4.0	NEW WORK LIGHTING PLAN
C2	EROSION CONTROL PLAN	A0.3	ARCHITECTURAL SPECIFICATIONS	A3.1	BUILDING SECTIONS	F2.0	FIRE SPRINKLER PLAN	E5.0	NEW WORK POWER PLAN
C3	PROPOSED SITE PLAN	A0.4	ARCHITECTURAL SPECIFICATIONS	A4.1	WALL SECTIONS	P3.0	PLUMBING RISERS AND DETAILS	E6.0	NEW WORK FIRE ALARM PLAN
C4	DETAILS	A0.5	ARCHITECTURAL SPECIFICATIONS	A4.2	WALL SECTIONS			E7.0	NEW WORK ATTIC PLAN
		A0.6	ARCHITECTURAL SPECIFICATIONS	A4.3	WALL SECTIONS	F1.0	FIRE SPRINKLER NOTES & DETAILS	E8.0	ELECTRICAL SCHEDULES
S0.0	STRUCTURAL NOTES	A0.7	ARCHITECTURAL SPECIFICATIONS	A4.4	WALL SECTIONS	F2.0	FIRE SPRINKLER PLAN	E9.0	ELECTRICAL DETAILS
S1.0	FOUNDATION PLAN	A0.8	ARCHITECTURAL SPECIFICATIONS	A4.5	WALL SECTIONS	F2.1	ATTIC FIRE SPRINKLER PLAN	E10.0	FIRE ALARM DETAILS
S2.0	CEILING/FLOOR FRAMING PLAN	A0.9	ARCHITECTURAL SPECIFICATIONS	A4.6	WALL SECTIONS				
S3.0	ROOF FRAMING PLAN	A0.10	ARCHITECTURAL SPECIFICATIONS	A4.7	WALL SECTIONS	M1.0	HVAC SCHEDULES & NOTES		
S4.0	SECTIONS AND DETAILS	A0.11	ARCHITECTURAL SPECIFICATIONS	A4.8	WALL SECTIONS	M2.0	HVAC PLAN		
S5.0	SECTIONS AND DETAILS	A1.1	EXISTING FLOOR PLAN	A5.1	INTERIOR ELEVATIONS	M2.1	ATTIC HVAC PLAN		
S6.0	SECTIONS AND DETAILS	A1.2	PROPOSED FLOOR PLAN	A5.2	INTERIOR ELEVATIONS	M3.0	HVAC DETAILS		



VICINITY MAP
NOT TO SCALE

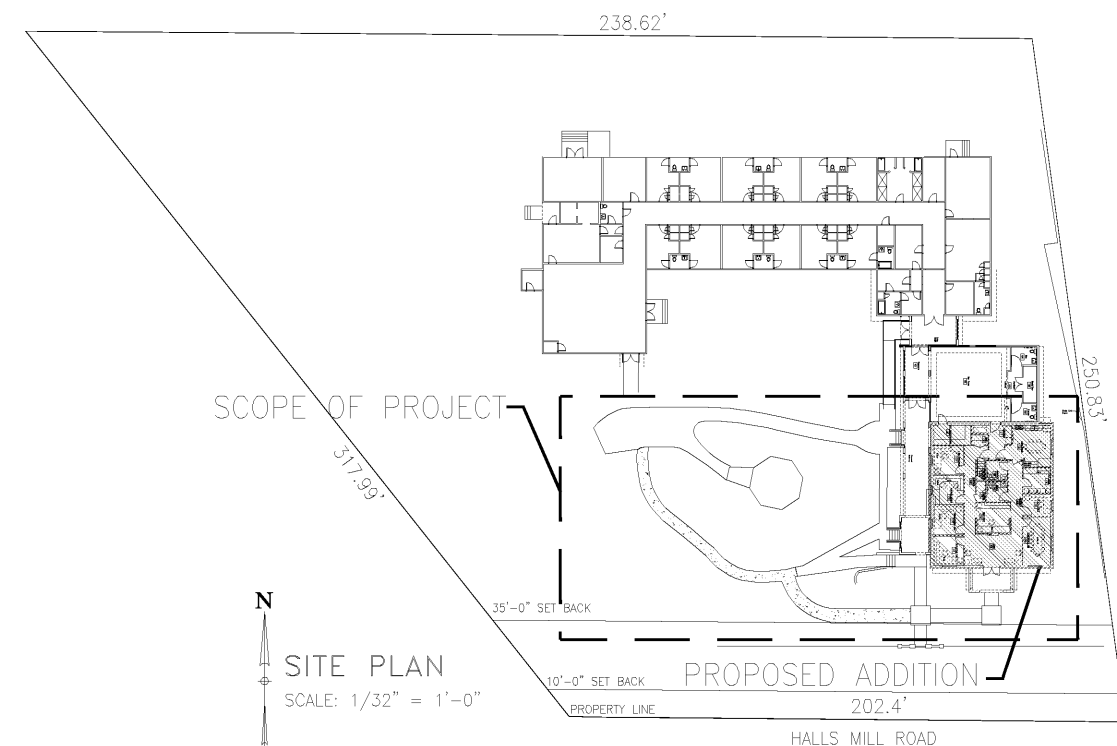

SITE PLAN
SCALE: 1/32" = 1'-0"

THIS DRAWING AND ITS REPRODUCTIONS ARE THE PROPERTY OF THE ARCHITECT AND MAY NOT BE REPRODUCED, PUBLISHED, OR USED IN ANY MANNER WITHOUT THE PERMISSION OF THE ARCHITECT.

REVISIONS	
MARK	DATE
SHEET NAME	
Title Sheet	
PROJECT NO. 2018-16	
DATE OCTOBER 3, 2018	
SHEET NO.	

T