




CUMMINGS ARCHITECTURE CORP

1000 Housley Street
Mobile, Alabama 36606
TEL: 251.433.9600

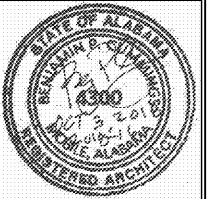

Mulherin Custodial Home
2496 Halls Mill Road
Mobile, AL 36606

THIS DRAWING AND ITS REPRODUCTIONS ARE THE PROPERTY OF THE ARCHITECT AND MAY NOT BE REPRODUCED, PUBLISHED, OR USED IN ANY MANNER WITHOUT THE PERMISSION OF THE ARCHITECT.


REVISIONS	
MARK	DATE

SHEET NAME
Life Safety Plan

PROJECT NO. 2018-16
DATE OCTOBER 3, 2018
SHEET NO.

LSP


LIFE SAFETY PLAN LEGEND	
	NEW FIRE EXTINGUISHERS. REFER TO SPECS FOR TYPE.
	INTERIOR EMERGENCY LIGHTS, REFER TO ELECTRICAL PLANS FOR TYPE.
	ILLUMINATED EXIT SIGN WITH BATTERY BACK UP, WITH DIRECTIONAL ARROW AS SHOWN, REFER TO ELECTRICAL PLANS FOR TYPE.
	INTERIOR EMERGENCY LIGHTS/EXIT SIGN COMBINATION, REFER TO ELECTRICAL PLANS FOR TYPE.
	EXTERIOR EMERGENCY LIGHTS, REFER TO ELECTRICAL PLANS FOR TYPE.
	TRAVEL DISTANCE
	INSTALL NEW SURFACE MOUNTED KNOX BOX, 3200 SERIES, COLOR BLACK. COORDINATE WITH FIRE DEPARTMENT.
	SMOKE DETECTOR

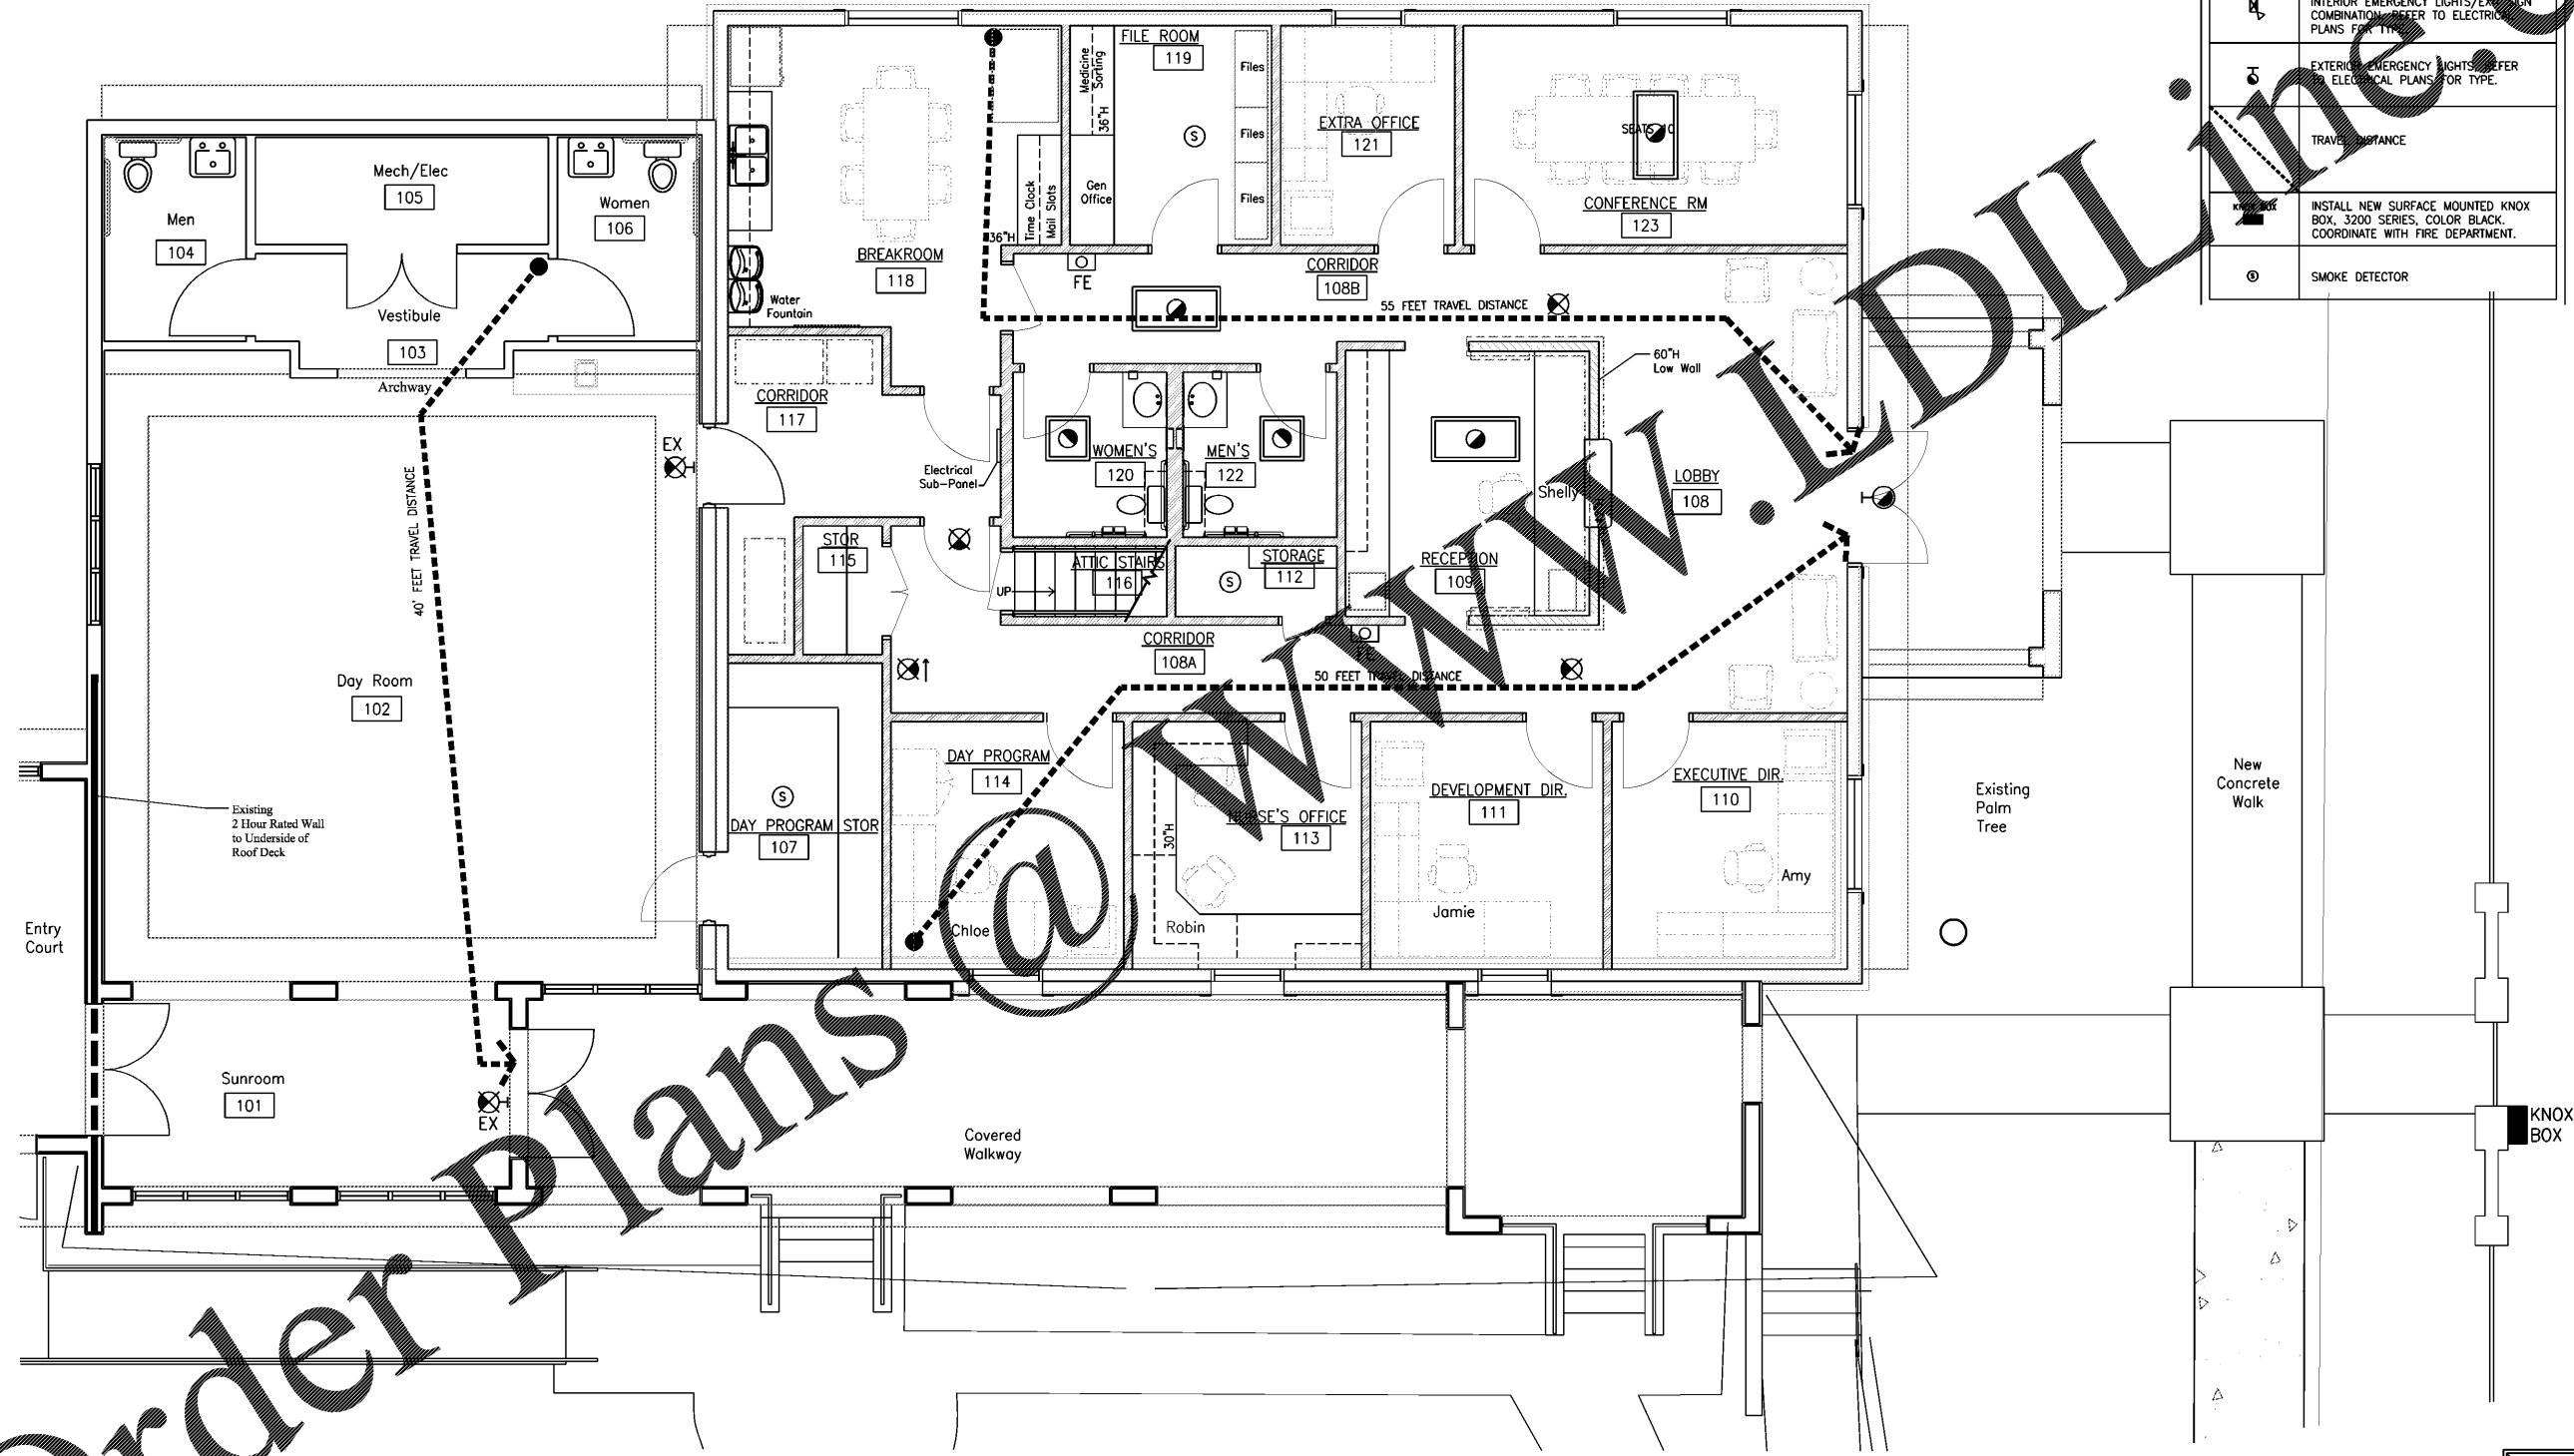

LIFE SAFETY PLAN
0 3' 6' 9' 12'
SCALE: 1/4" = 1'-0"

SEMI-RECESSED FIRE EXTINGUISHER CABINET REFER TO SPECS

NOTE REFER TO FLOOR PLAN FOR F.E.C. LOCATIONS

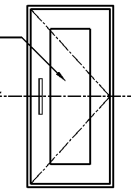

Order Plans

WWW.DIPLINE.COM