


SHEET NOTES

- 1 EXISTING SPRINKLER RISER IS LOCATED IN THIS ROOM. EXTEND AS NECESSARY FOR COVERAGE OF THE NEW BUILDING.
- 2 PROVIDE WET PIPE SPRINKLER COVERAGE FOR APPROXIMATELY 2,360 SF PER THE REQUIREMENTS OF NFPA 13.
- 3 PROVIDE COVERAGE WITH SIDEWALL COVERAGE SPRINKLER HEADS FOR THE APPROXIMATE 500 SF COVERED WALK WAY AREA FROM THE CONDITIONED ATTIC/CEILING SPACE OF THE NEW BUILDING.
- 4 PROVIDE COVERAGE WITH SIDEWALL COVERAGE SPRINKLER HEADS PER THE REQUIREMENTS OF NFPA 13 FOR THE APPROXIMATE 145 SF PORCH AREA FROM THE CONDITIONED ATTIC/CEILING SPACE OF THE NEW BUILDING.

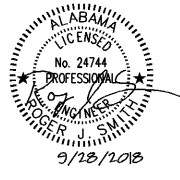


Mulherin Custodial Home
 2496 Halls Mill Road
 Mobile, AL 36606

THIS DRAWING AND ITS REPRODUCTIONS ARE THE PROPERTY OF THE ARCHITECT AND MAY NOT BE REPRODUCED, PUBLISHED, OR USED IN ANY MANNER WITHOUT THE PERMISSION OF THE ARCHITECT.

REVISIONS	
MARK	DATE

SHEET NAME
FIRE SPRINKLER PLAN
 PROJECT NO. 2018-16
 DATE SEPTEMBER 28, 2018
 SHEET NO.

F2.0

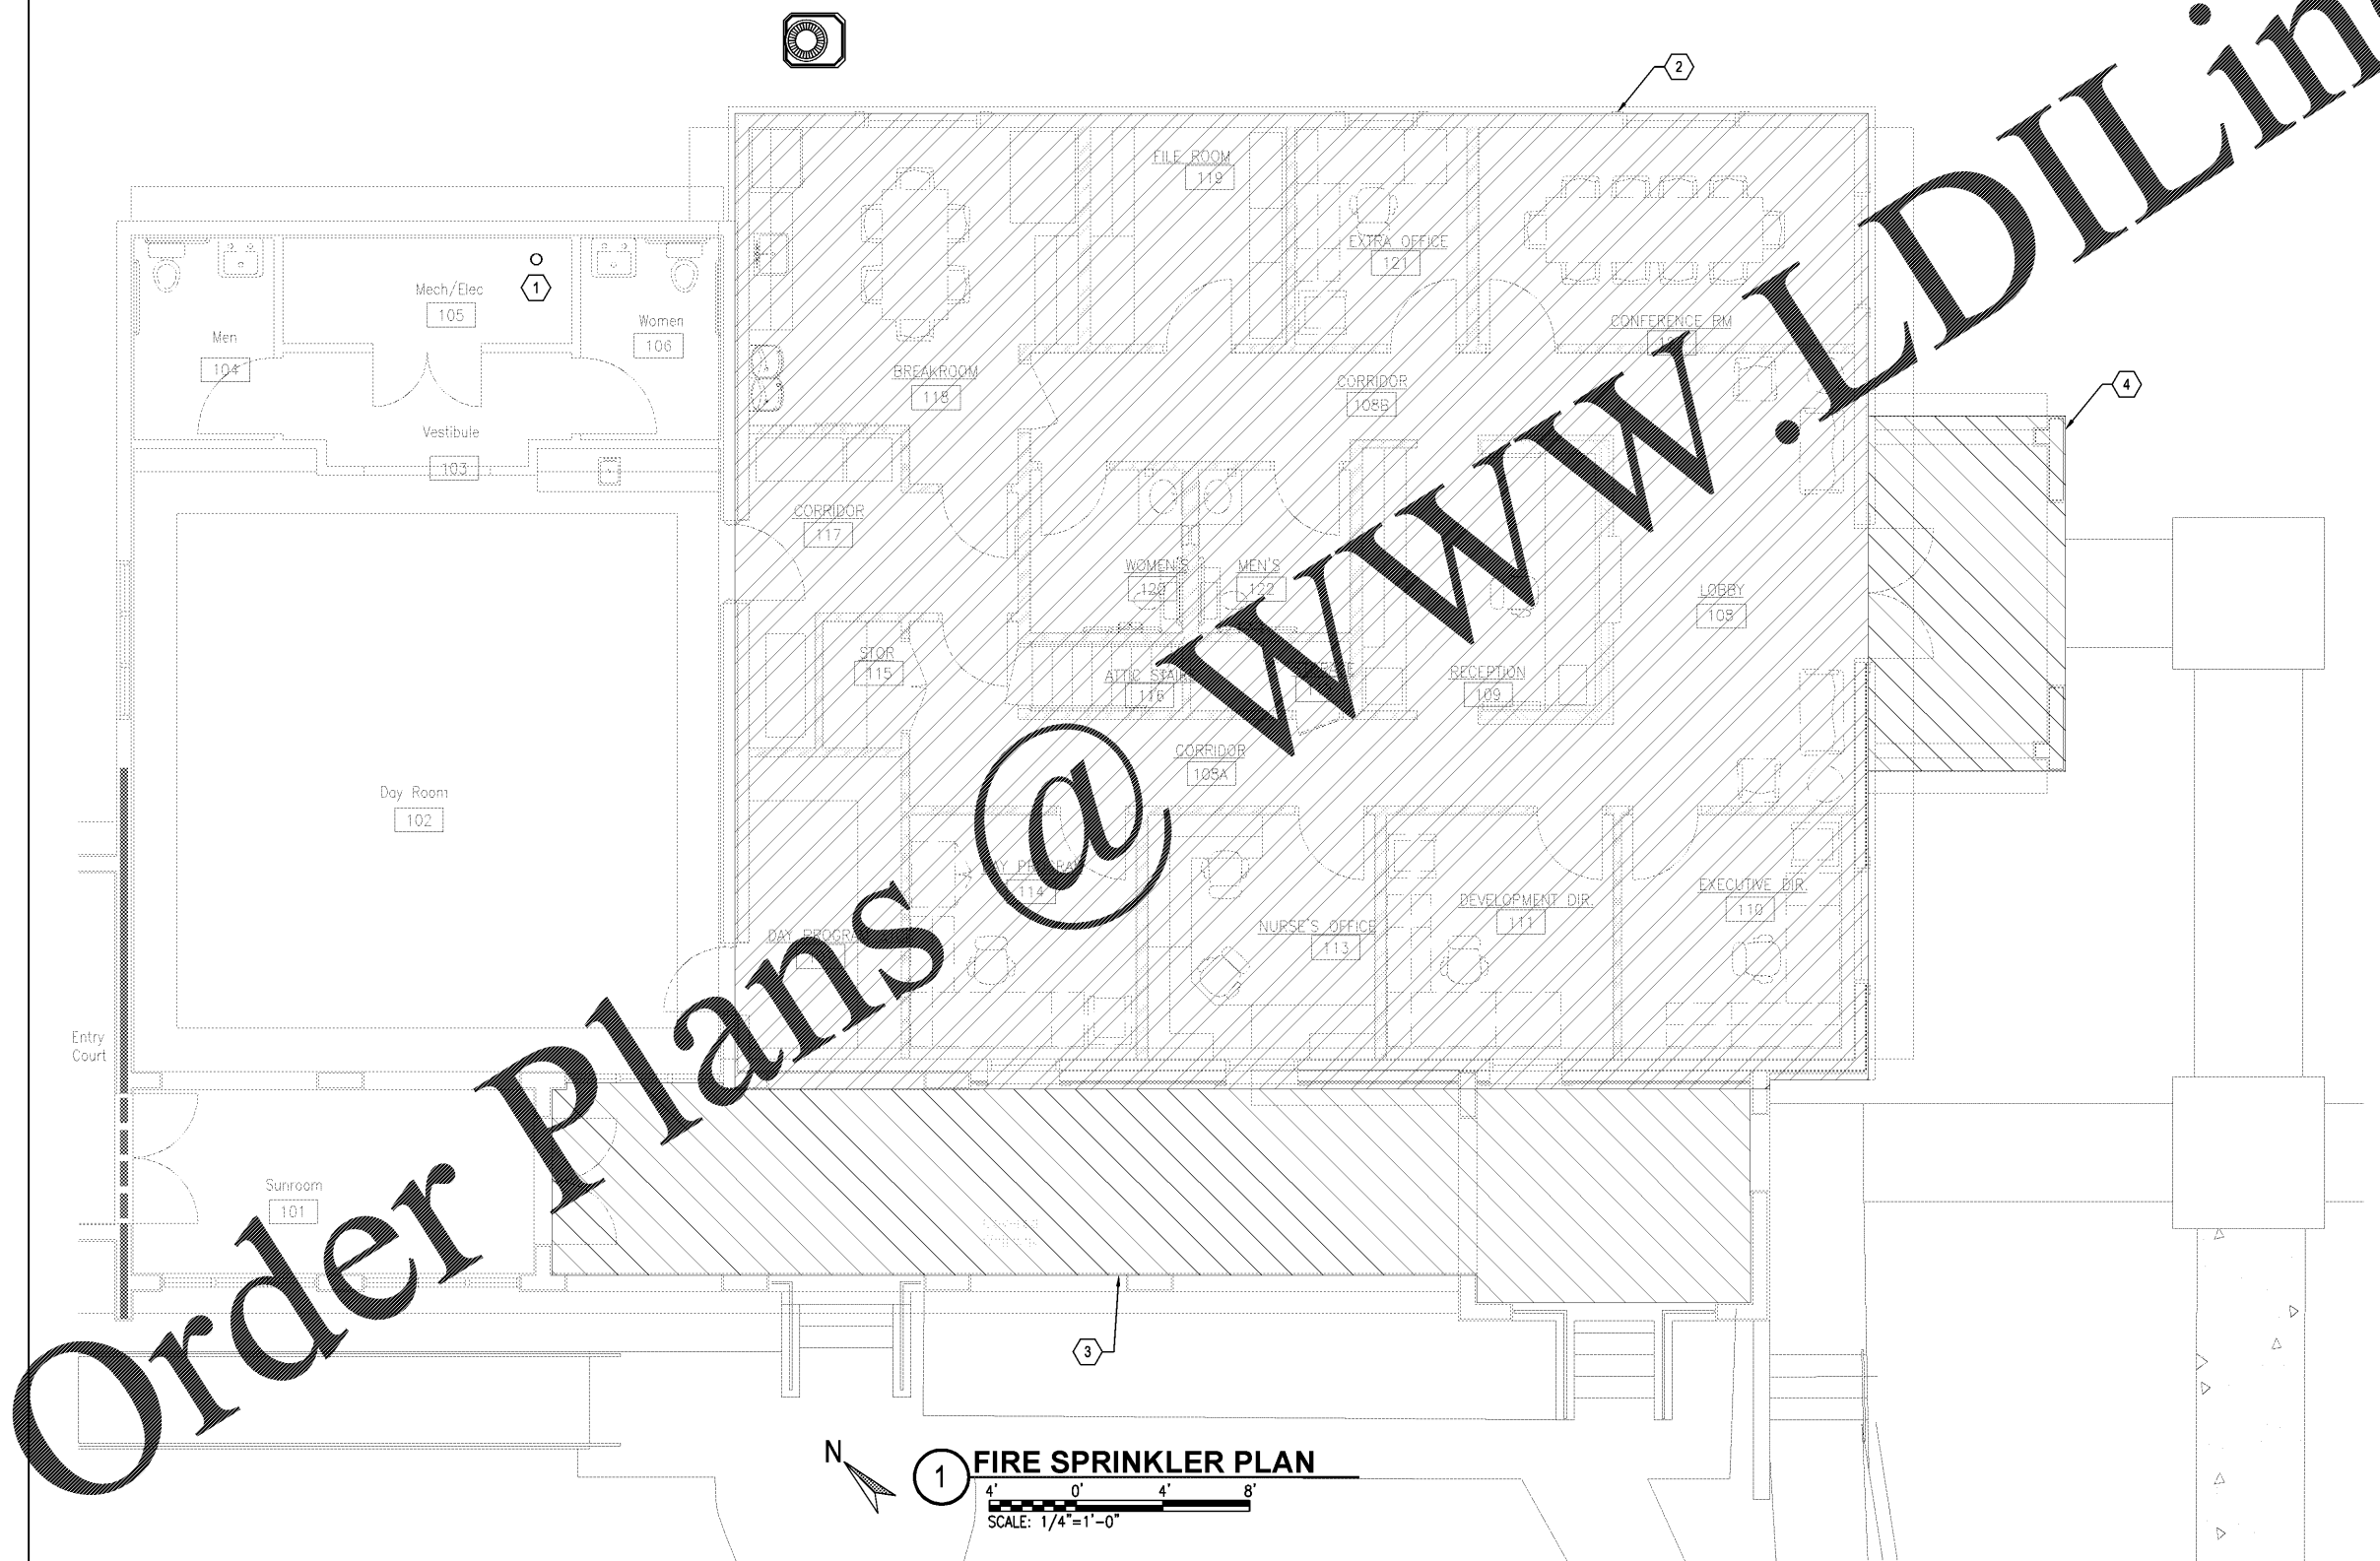

1 **FIRE SPRINKLER PLAN**
 SCALE: 1/4"=1'-0"

Order Plans @ www.LDLine.com