

SHEET NOTES

1 PROVIDE WET PIPE SPRINKLER COVERAGE FOR APPROXIMATELY 1,221 SF ATTIC SPACE PER THE REQUIREMENTS OF NFPA 13.



Mulherin Custodial Home
2496 Halls Mill Road
Mobile, AL 36606

THIS DRAWING AND ITS REPRODUCTIONS ARE THE PROPERTY OF THE ARCHITECT AND MAY NOT BE REPRODUCED, PUBLISHED, OR USED IN ANY MANNER WITHOUT THE PERMISSION OF THE ARCHITECT.

REVISIONS	
MARK	DATE


SHEET NAME
ATTIC FIRE SPRINKLER PLAN

PROJECT NO. 2018-16

DATE
SEPTEMBER 28, 2018

SHEET NO.

F2.1

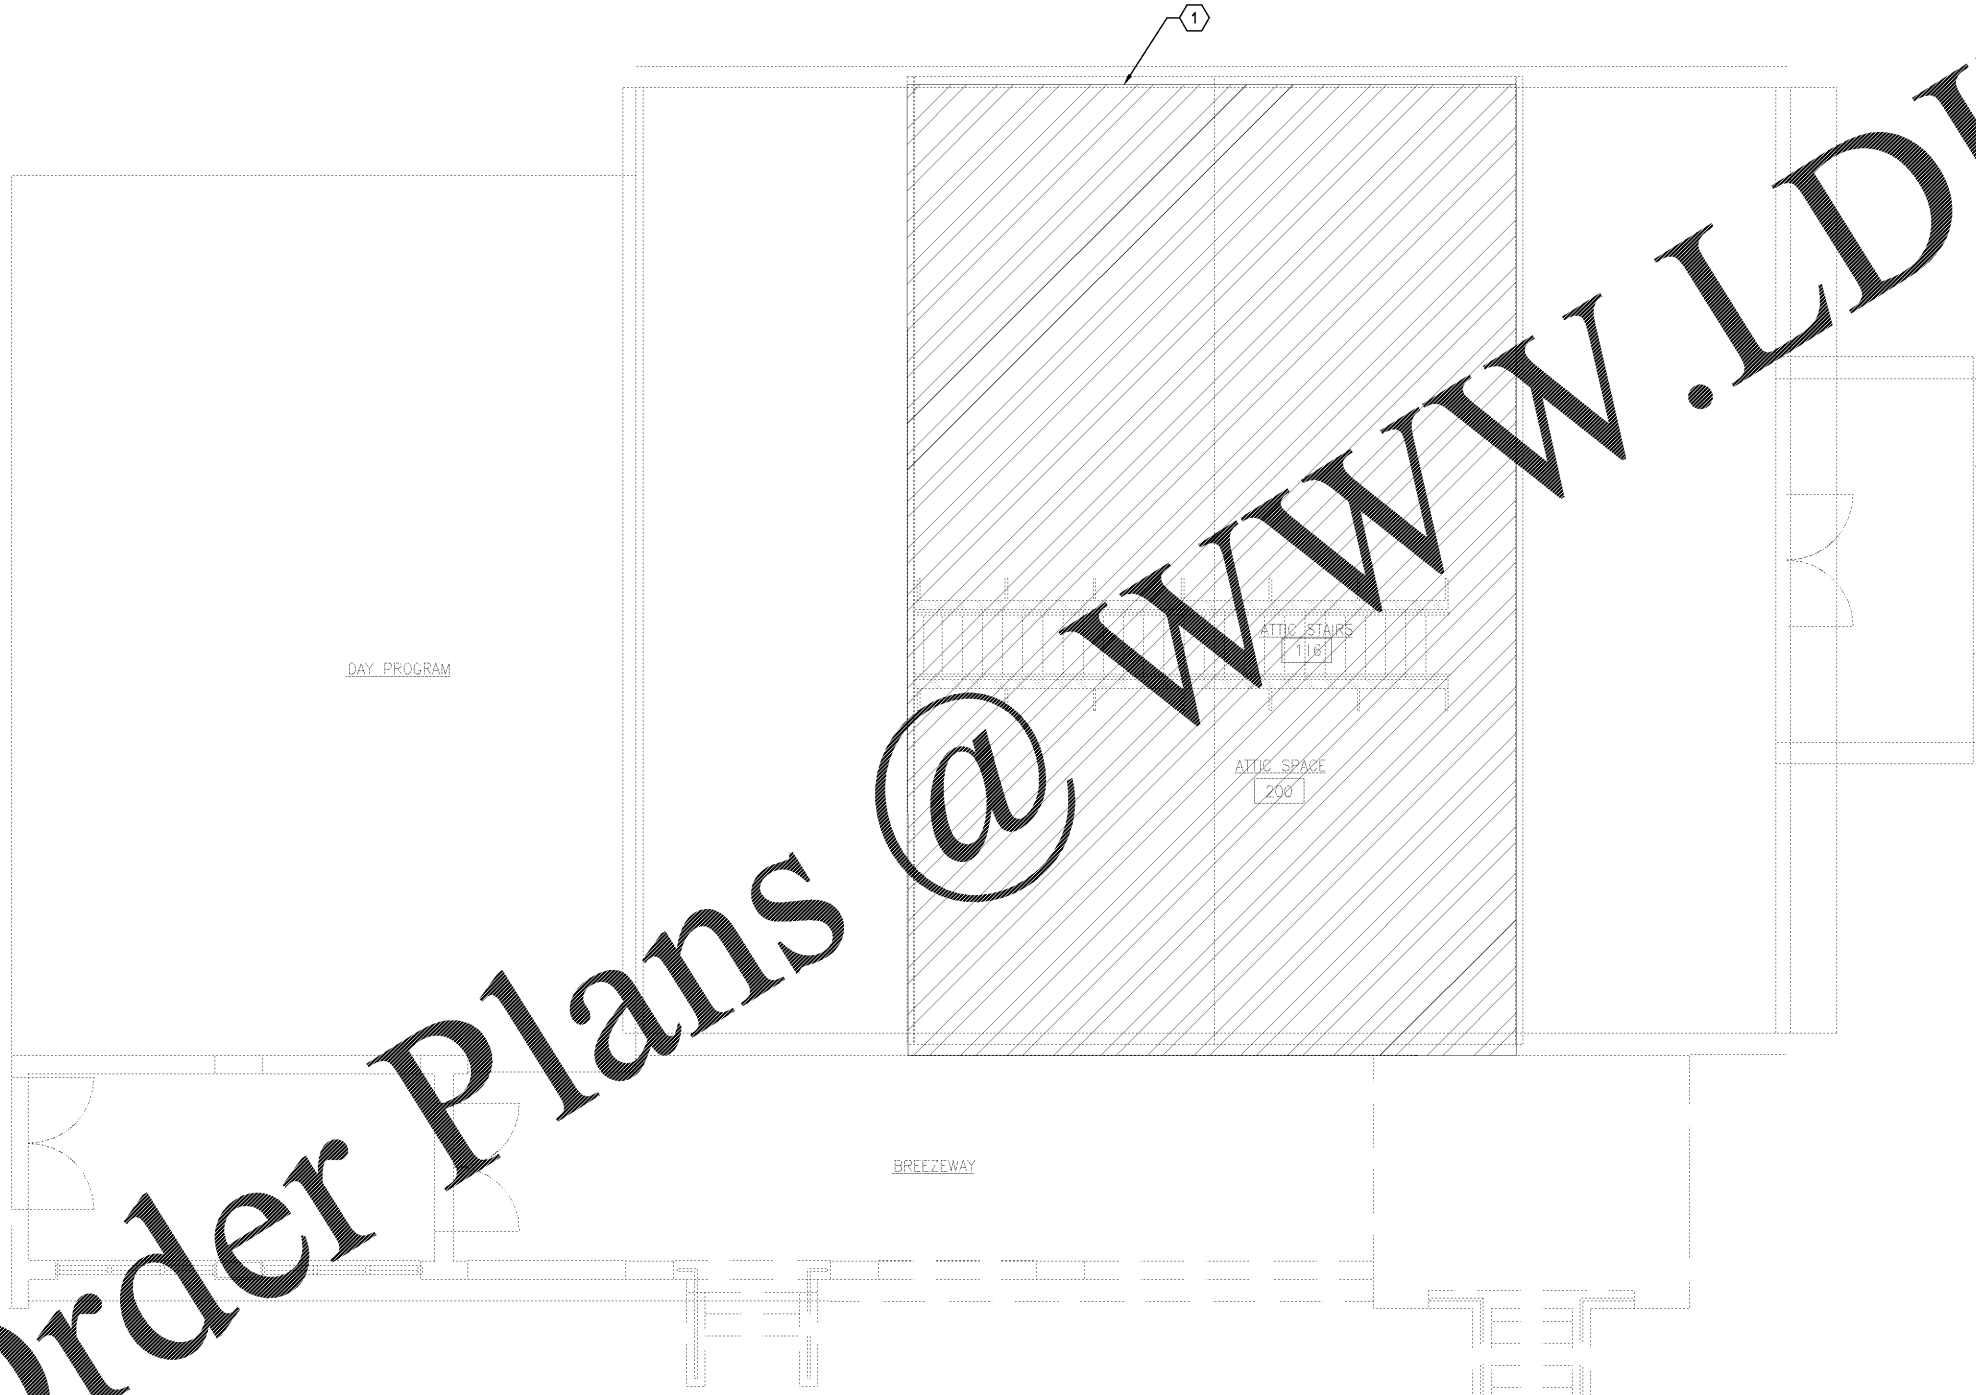

1 **ATTIC FIRE SPRINKLER PLAN**

SCALE: 1/4"=1'-0"

Order Plans @ WWW.LDILine.com