


SHEET NOTES

① RCP-1 AND ITS DISCONNECT ARE MOUNTED IN THE CEILING.

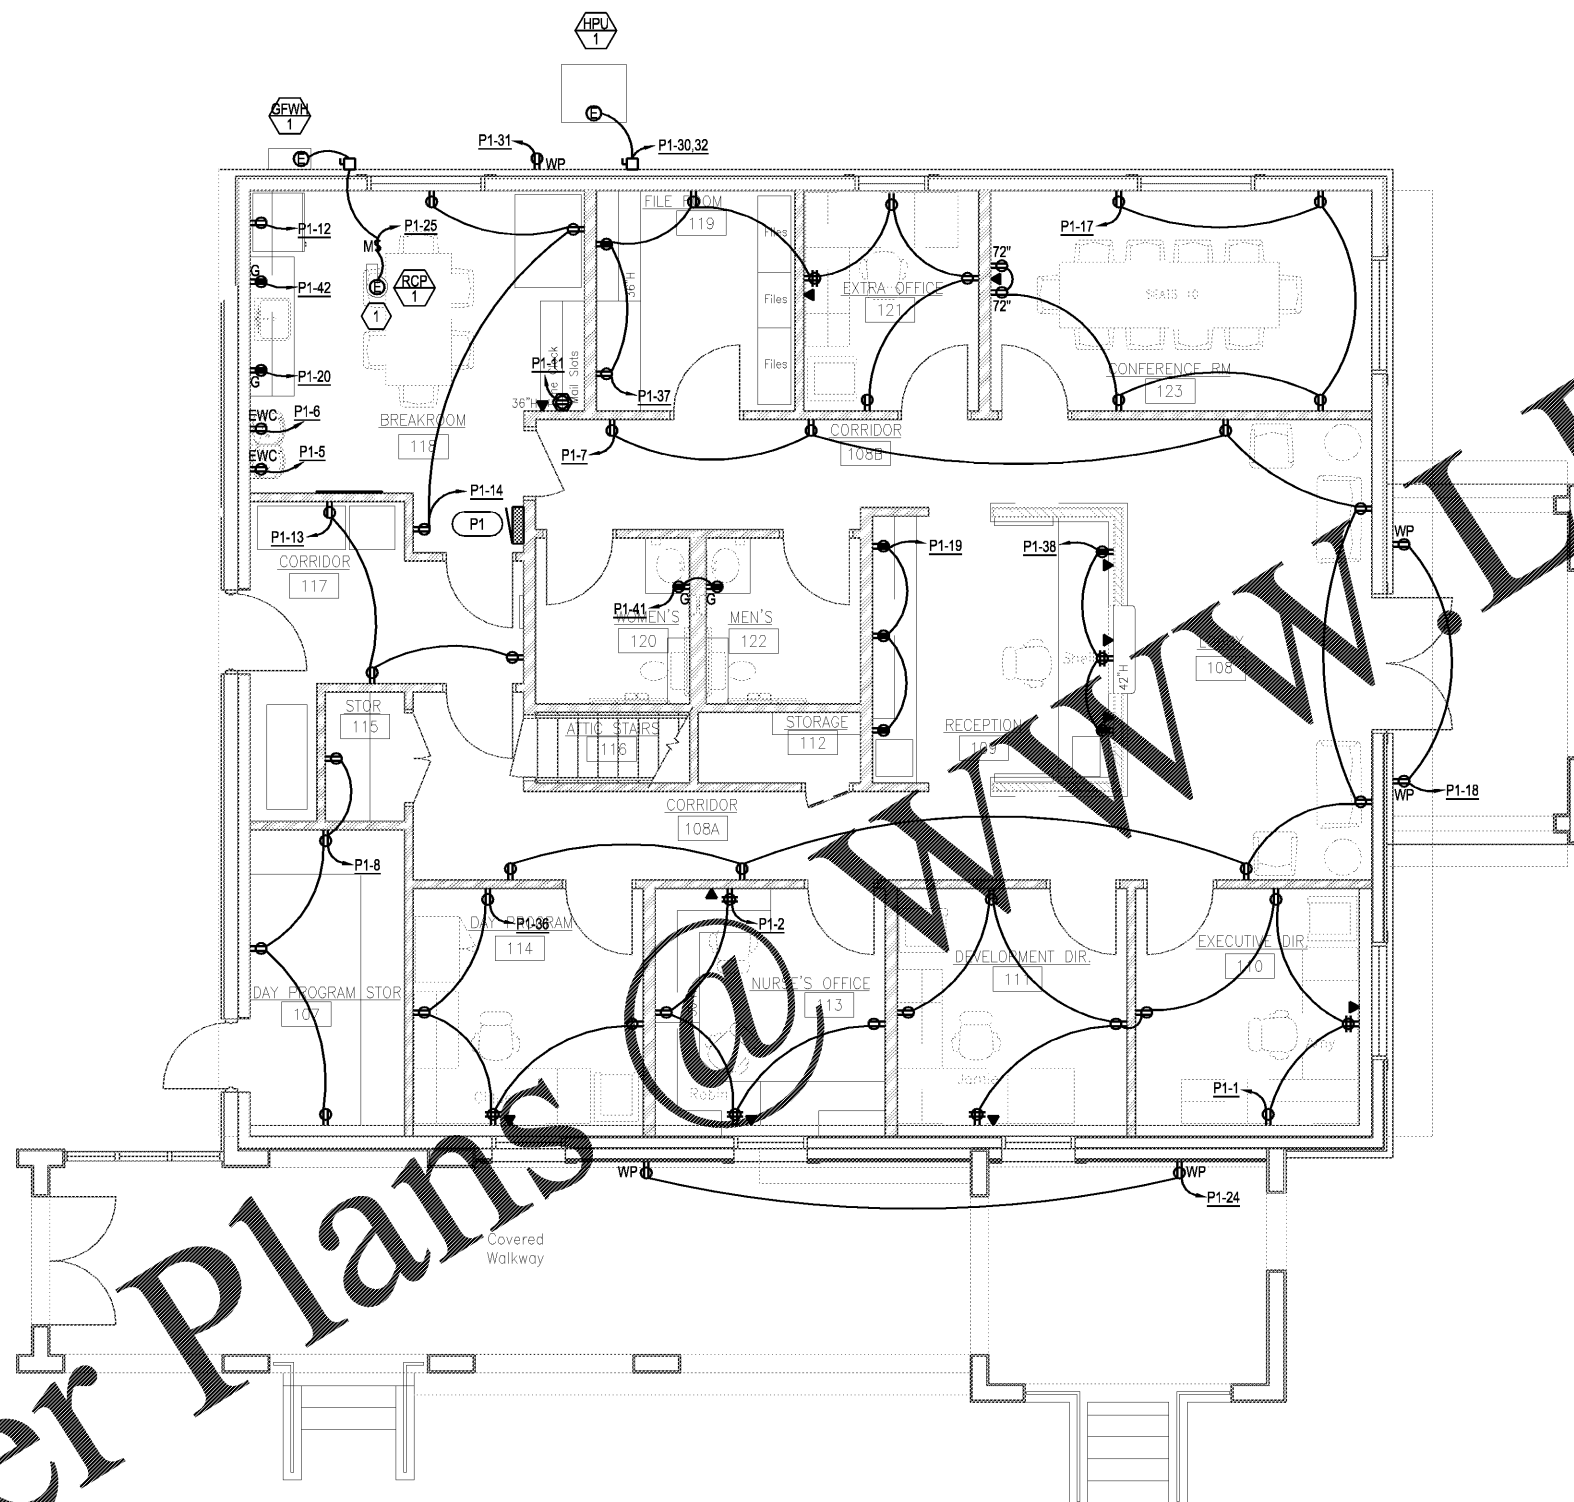

Mulherin Custodial Home
 2496 Halls Mill Road
 Mobile, AL 36606

THIS DRAWING AND ITS REPRODUCTIONS ARE THE PROPERTY OF THE ARCHITECT AND MAY NOT BE REPRODUCED, PUBLISHED, OR USED IN ANY MANNER WITHOUT THE PERMISSION OF THE ARCHITECT.

REVISIONS

MARK	DATE

 
SHEET NAME
NEW WORK POWER PLAN

PROJECT NO. 2018-16

DATE SEPTEMBER 28, 2018

SHEET NO.

E5.0



Order Plans