

**SHEET NOTES**

1 SWITCH FOR ATTIC LIGHTING SHALL BE INSTALLED ON THE FIRST FLOOR AND SHOWN ON THE NEW WORK POWER PLAN.



**Mulherin Custodial Home**  
 2496 Halls Mill Road  
 Mobile, AL 36606


THIS DRAWING AND ITS REPRODUCTIONS ARE THE PROPERTY OF THE ARCHITECT AND MAY NOT BE REPRODUCED, PUBLISHED, OR USED IN ANY MANNER WITHOUT THE PERMISSION OF THE ARCHITECT.

REVISIONS	
MARK	DATE

SHEET NAME  
**NEW WORK ATTIC PLAN**

PROJECT NO. 2018-16  
 DATE SEPTEMBER 28, 2018  
 SHEET NO.

**E7.0**

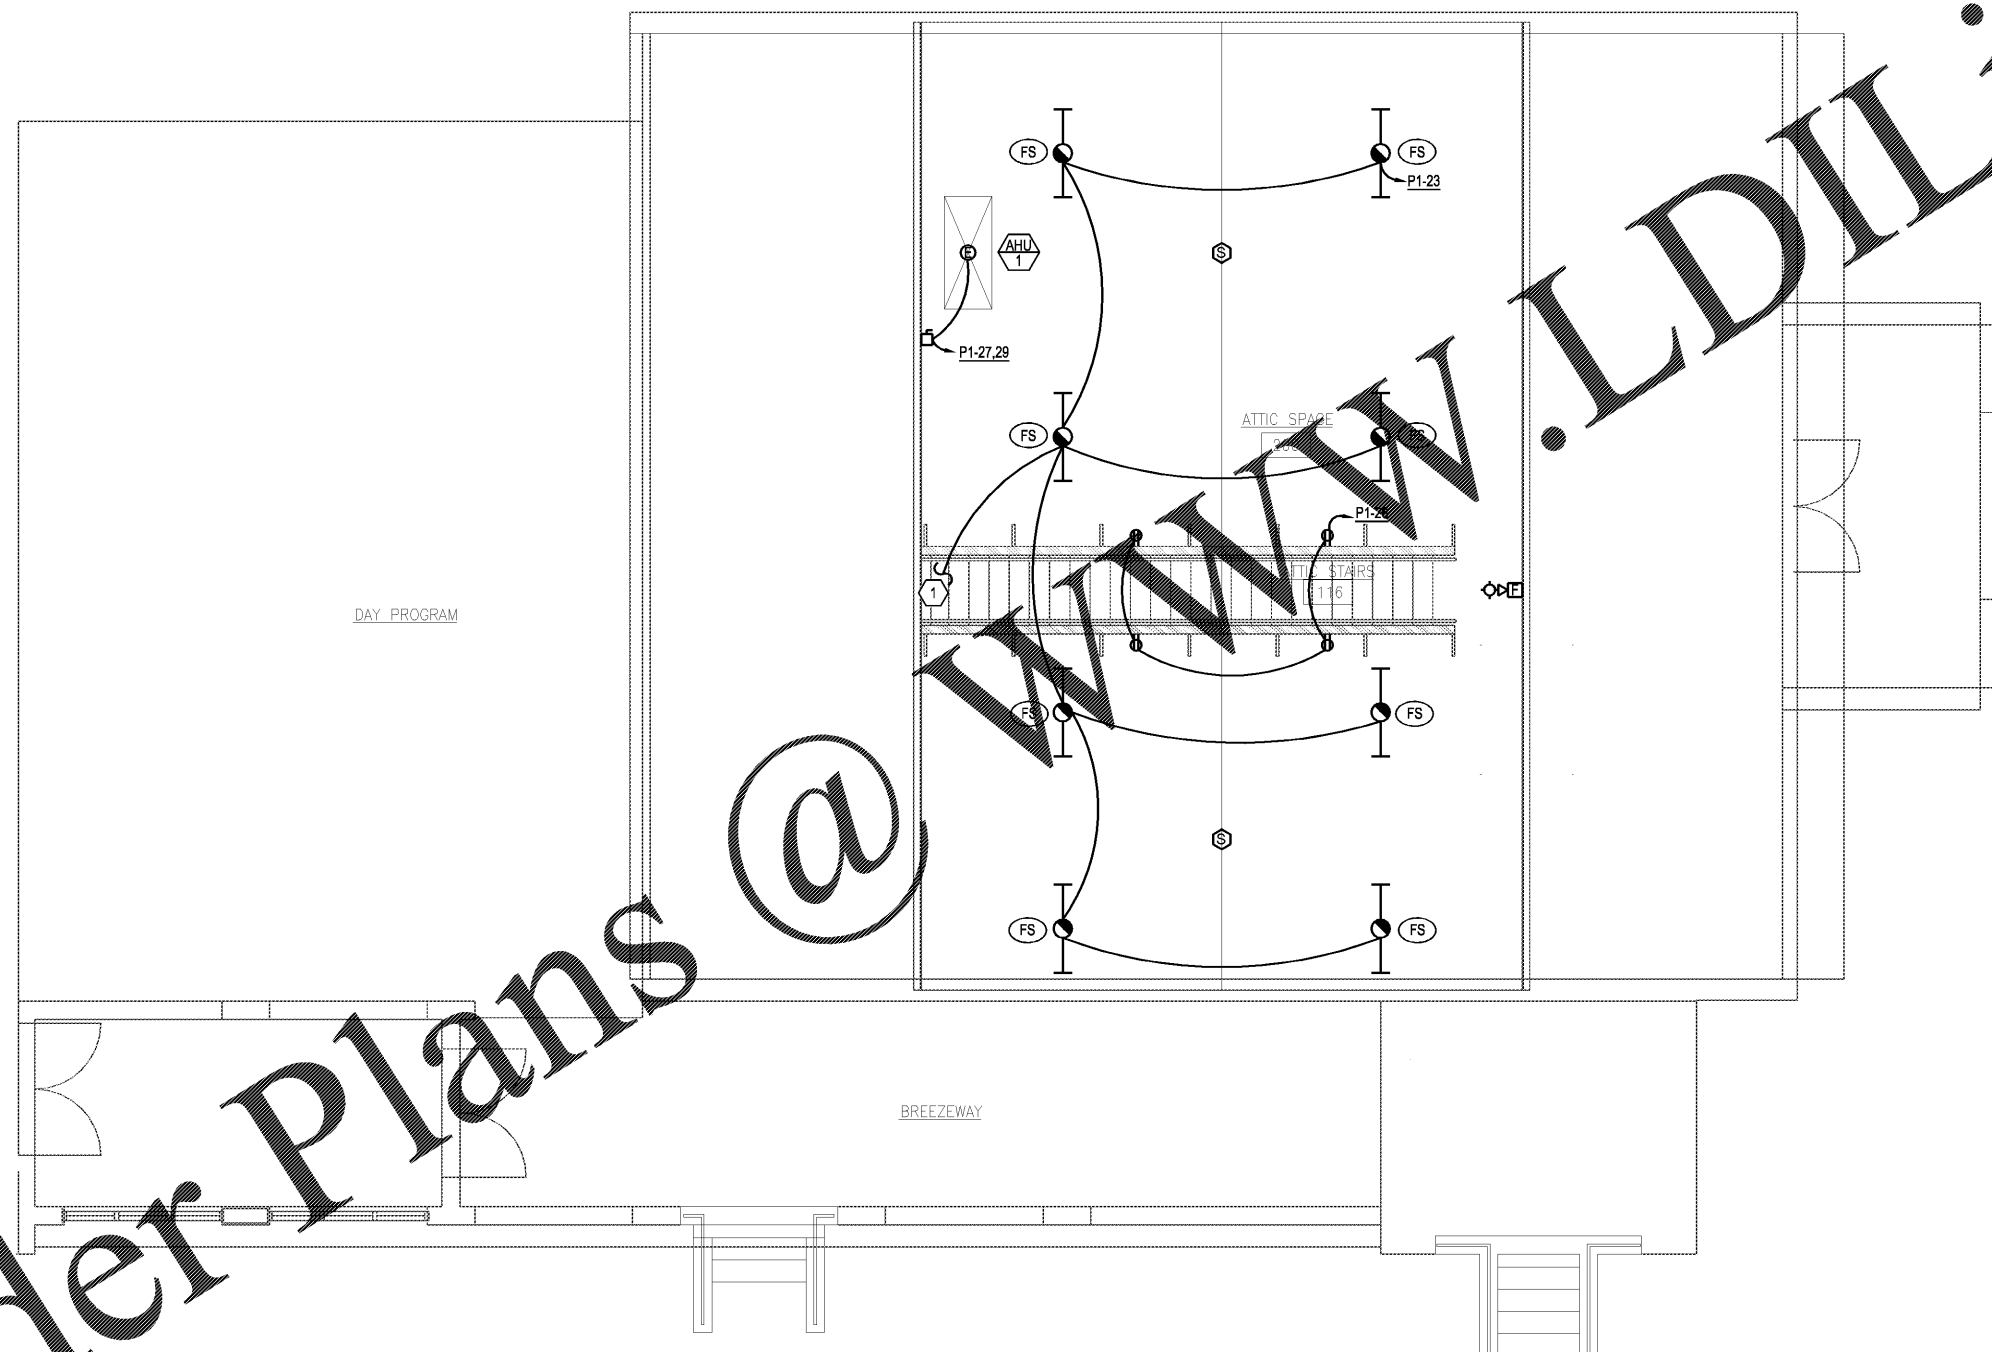

Order Plans @ [www.LDILine.com](http://www.LDILine.com)