


Order Plans @ www.dlLine.com

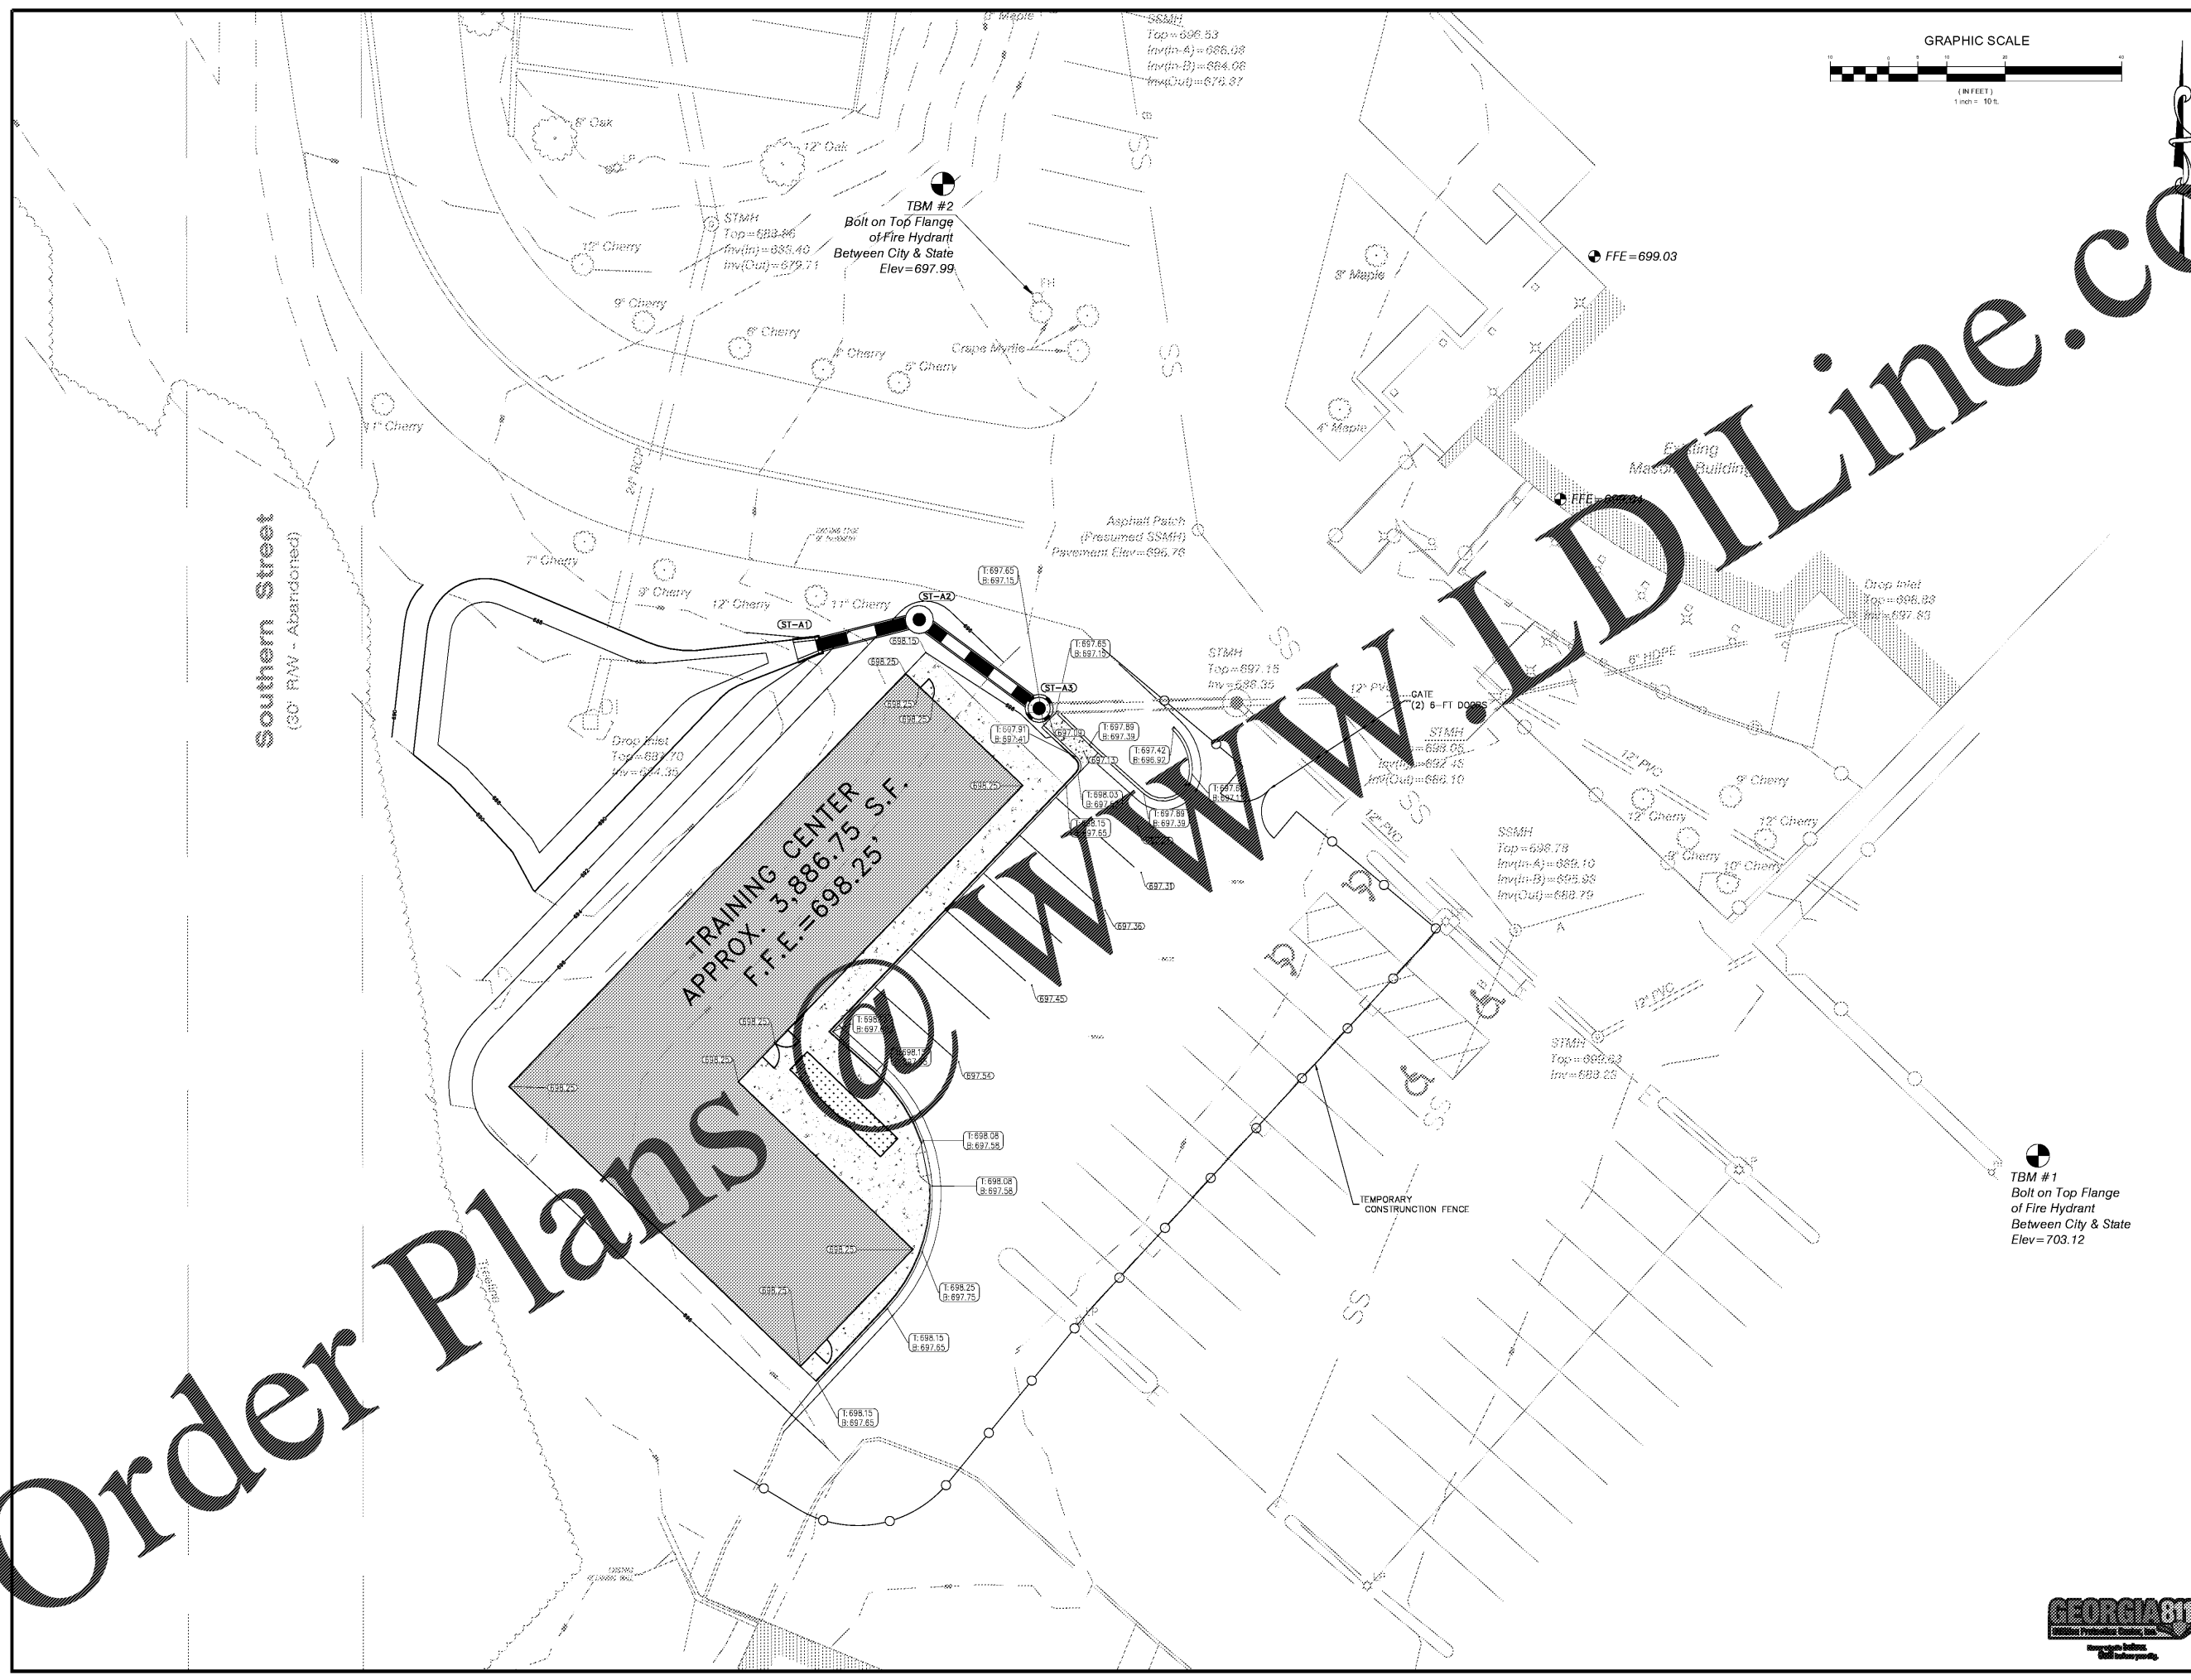

PROJECT NO.:	18090
DATE:	07-19-18
REVISIONS:	
XX/XX/XXXX	SUBMITTER TO
XX	

SOUTHLAND ENGINEERING
 CIVIL ENGINEERS - LAND SURVEYORS - LAND PLANNERS
 114 OLD MILL ROAD, CARTERSVILLE, GEORGIA 30120
 PHONE: 770-387-0440
 FAX: 770-607-5151

CITY OF ROME
FLOYD COUNTY JAIL TRAINING CENTER
 LAND LOT(S) 193, 23rd DISTRICT, 3rd SECTION,
 CITY OF ROME, FLOYD COUNTY, GEORGIA

GSWCC NO. 3422
 SHEET TITLE:
GRADING PLAN

DRAWING NO.:

C401

