




**PEACOCK ARCHITECTS**  
 2526 NEW CALHOUN HIGHWAY N.E.  
 ATLANTA, GEORGIA 30328  
 404-254-5200 PHONE  
 404-214-5208 FAX

RELOCATED TRAINING CENTER  
 FOR  
 THE FLOYD COUNTY JAIL  
 2526 NEW CALHOUN HIGHWAY N.E.  
 ROME, GEORGIA 30161

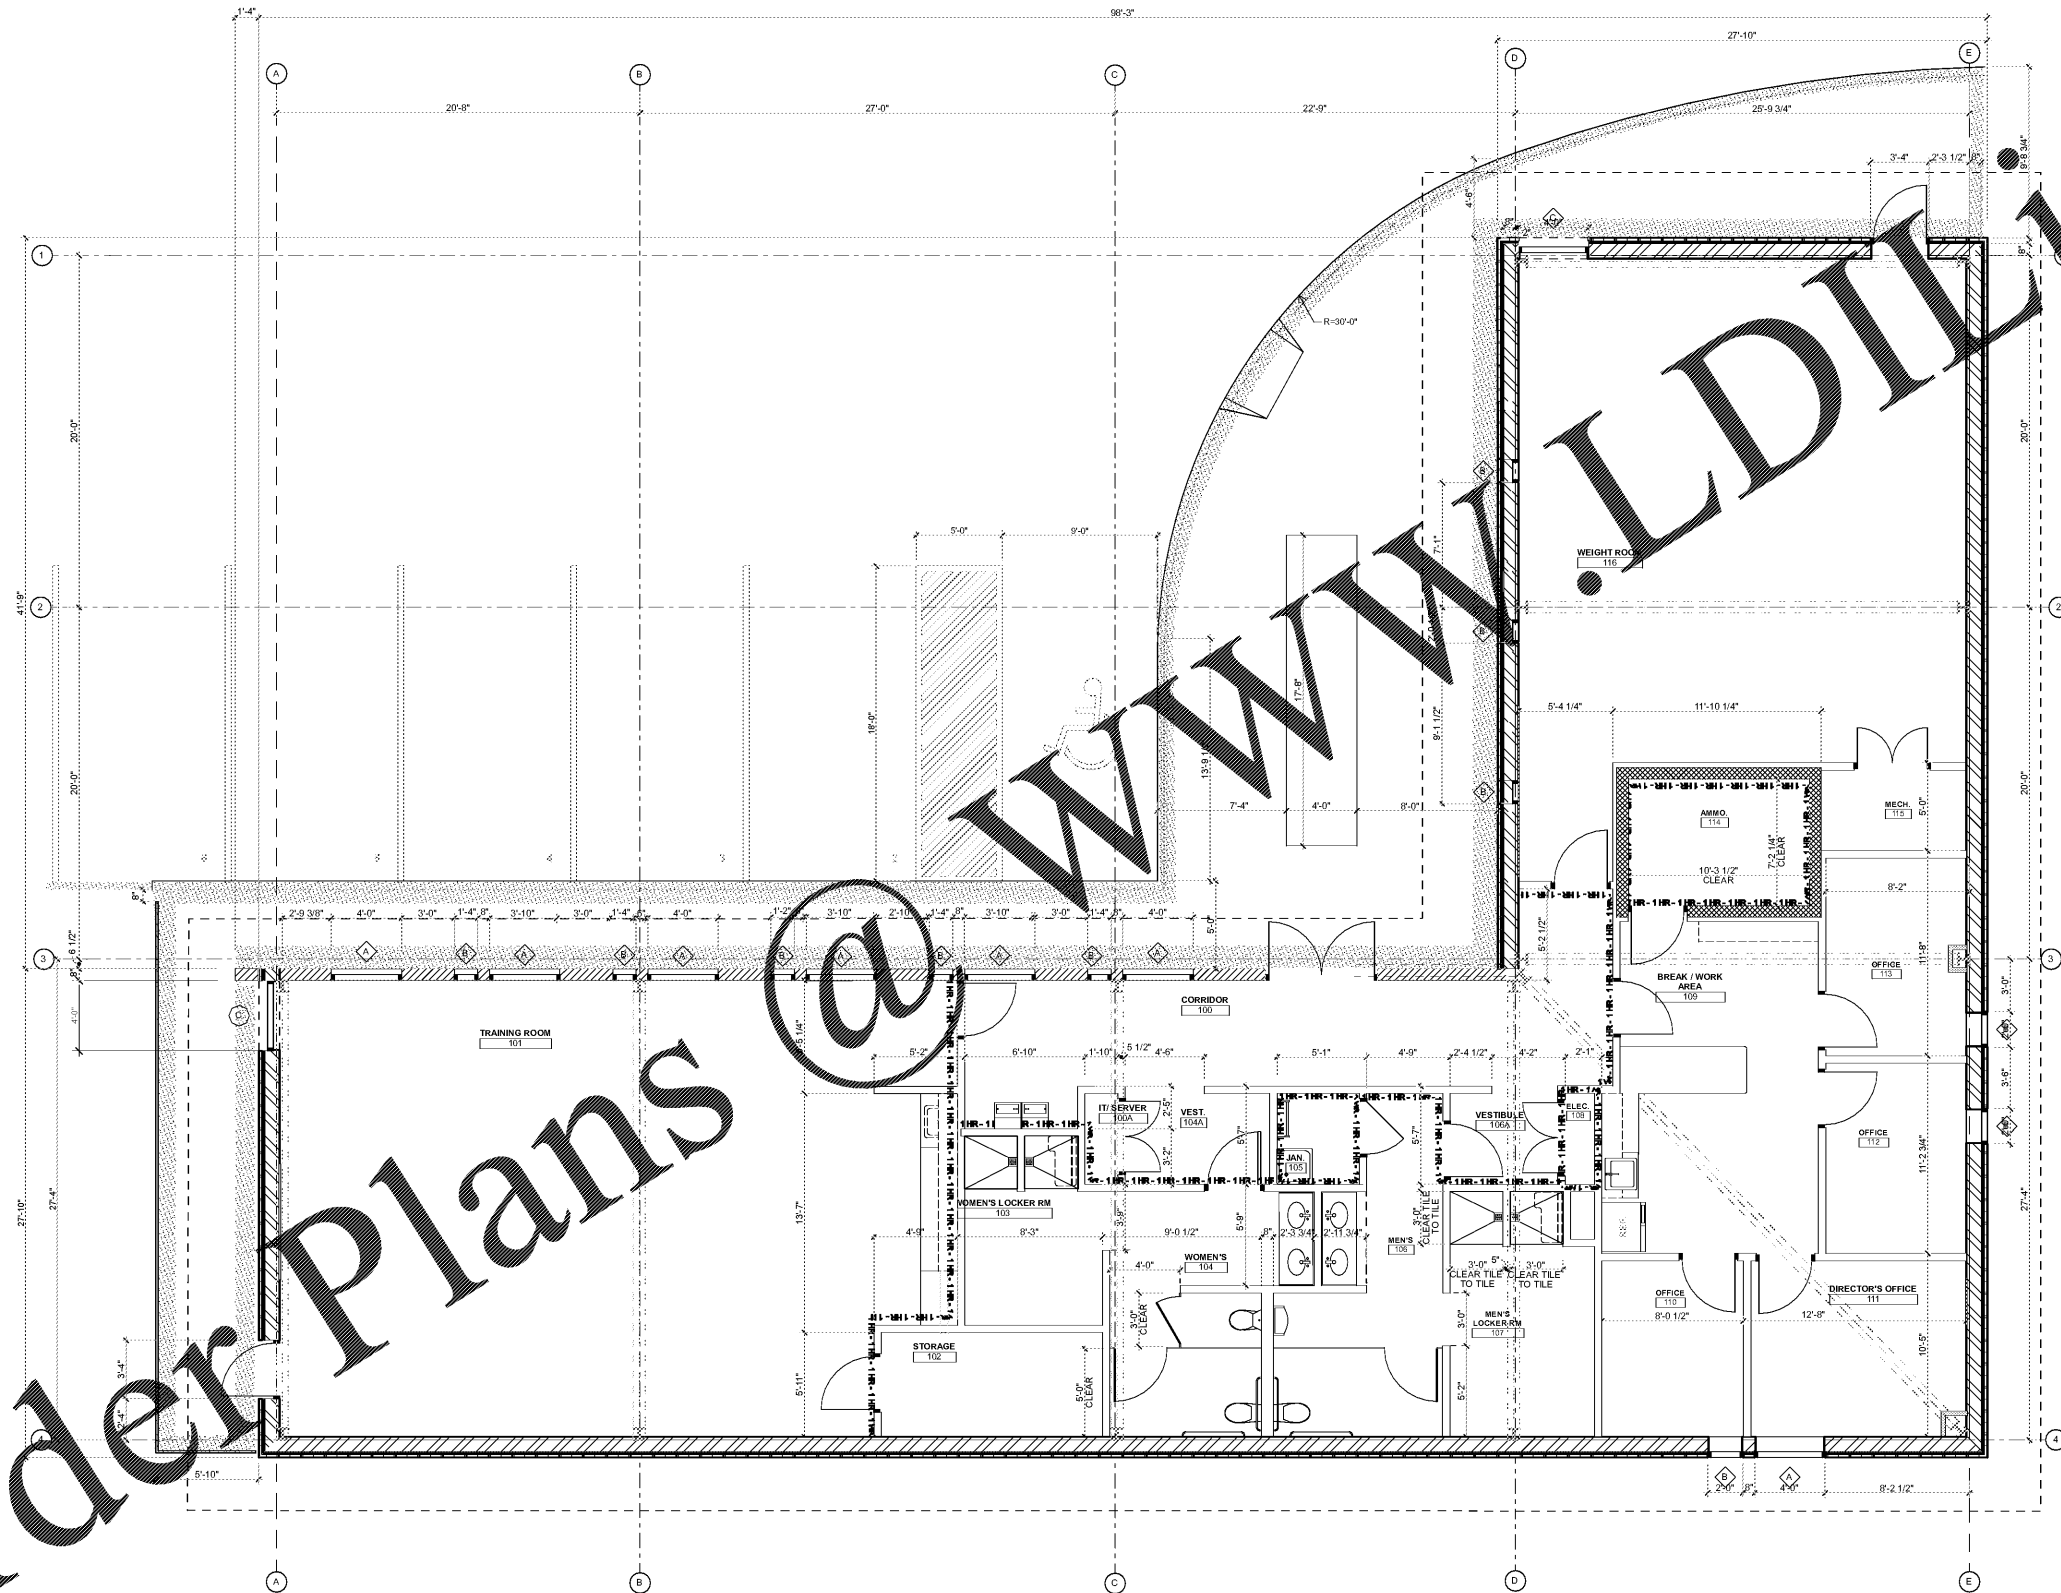

BIM Server: PEA... Server 2\1420.03.01 Floyd Co Training Facilities

Order Plans @

**A3.10** DIMENSION FLOOR PLAN  
 SCALE: 1/4" = 1'-0"

DATE	REVISION

PROJECT NO:  
420.03.01  
 DATE:  
JULY 17, 2018  
 DRAWING TITLE:  
DIMENSION FLOOR PLAN

**A3.10**

THIS DRAWING AND ANY REPRODUCTIONS THEREOF ARE THE PROPERTY OF PEACOCK ARCHITECTS, INC. AND MAY NOT BE REPRODUCED OR TRANSMITTED IN ANY FORM OR BY ANY MEANS WITHOUT THE EXPRESS WRITTEN PERMISSION OF PEACOCK ARCHITECTS, INC.