




EAOC ARCHITECTS
 2526 NEW CALHOUN HIGHWAY N.E.
 ROME, GEORGIA 30161
 404-214-5200 PHONE
 404-214-5208 FAX


GENERAL NOTES :

1. TYPE STANDARD DRYWALL PARTITIONS SHALL BE CONSTRUCTED OF 3/8" STUDS WITH 5/8" "X" DRYWALL ON EACH SIDE UNLESS NOTED OTHERWISE.
2. RESERVED
3. CAULKING WILL BE PROVIDED BETWEEN THE TOP OF THE DRYWALL PARTITION AND THE CEILING WHERE APPLICABLE.
4. INTERIOR PARTITIONS SHALL BE 5/8" TYPE "X" GWB EACH SIDE OF 3/8" 18 GA. METAL STUDS UNLESS OTHERWISE NOTED. RATED WALLS ARE DESCRIBED ON LIFE SAFETY SHEET.
5. CONTRACTOR SHALL PERMANENTLY IDENTIFY ALL FIRE-RESISTANCE-RATED WALLS (AND CORRESPONDING FIRE RESISTANCE RATING) INCLUDING FIRE BARRIER WALLS, SMOKE BARRIER WALLS AND PARTITIONS, FIRE WALLS EITHER BY INSTALLING SIGNS OR BY STENCILING IN UNPAINTED SPACES THE FOLLOWING: (1) HOUR FIRE AND SMOKE BARRIER - PROTECT ALL OPENINGS. IDENTIFICATION SHALL BE SPACED NO MORE THAN TWELVE FEET CENTER WITH A MINIMUM LETTER SIZE OF TWO INCHES IN HEIGHT ON A CONTRASTING BACKGROUND. (SBC SECTION 703.5 OF THE 2002 GA STATE AMENDMENTS).
6. RESERVED
7. COORDINATE RATED PARTITION TYPES WITH LIFE SAFETY PLANS AND GENERAL NOTES SHEET.
8. WATER RESISTANT TYPE "X" GWB SHALL BE USED AROUND ALL PLUMBING FIXTURES.
9. WHERE STEEL BEAMS AND/OR JOISTS PENETRATE FIRE AND/OR SMOKE RATED WALLS, PROVIDE FIRE SAPHO AT INTERSECTION OF BEAM AND/OR JOISTS AND METAL ROOF DECK. SEE SPECS.
10. AT THE INTERSECTION OF RATED WALLS, THE HIGHER PRIORITY WALL SHALL PASS THRU THE LESSER PRIORITY WALL. RATED WALLS ARE TO BE BUILT FIRST. NON-RATED FRAMED INTO THEM.
11. SEAL ALL CONDUITS, PIPES, DUCTWORK, ETC. PASSING THRU FIRE RATED WALLS WITH APPROVED FIRE RATED MATERIALS AS PER THE REQUIRED ASSEMBLIES. ALL PENETRATIONS SHALL CONFORM TO ASTM E-814 AND U.L. DESIGN ASSEMBLIES USED.

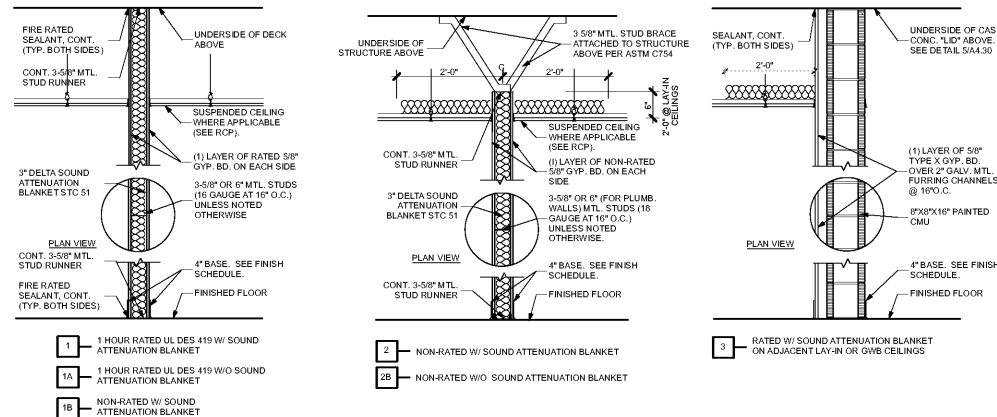

2 PARTITION TYPES
 SCALE: 3/4" = 1'-0"

1 REFERENCE PLAN
 SCALE: 1/4" = 1'-0"

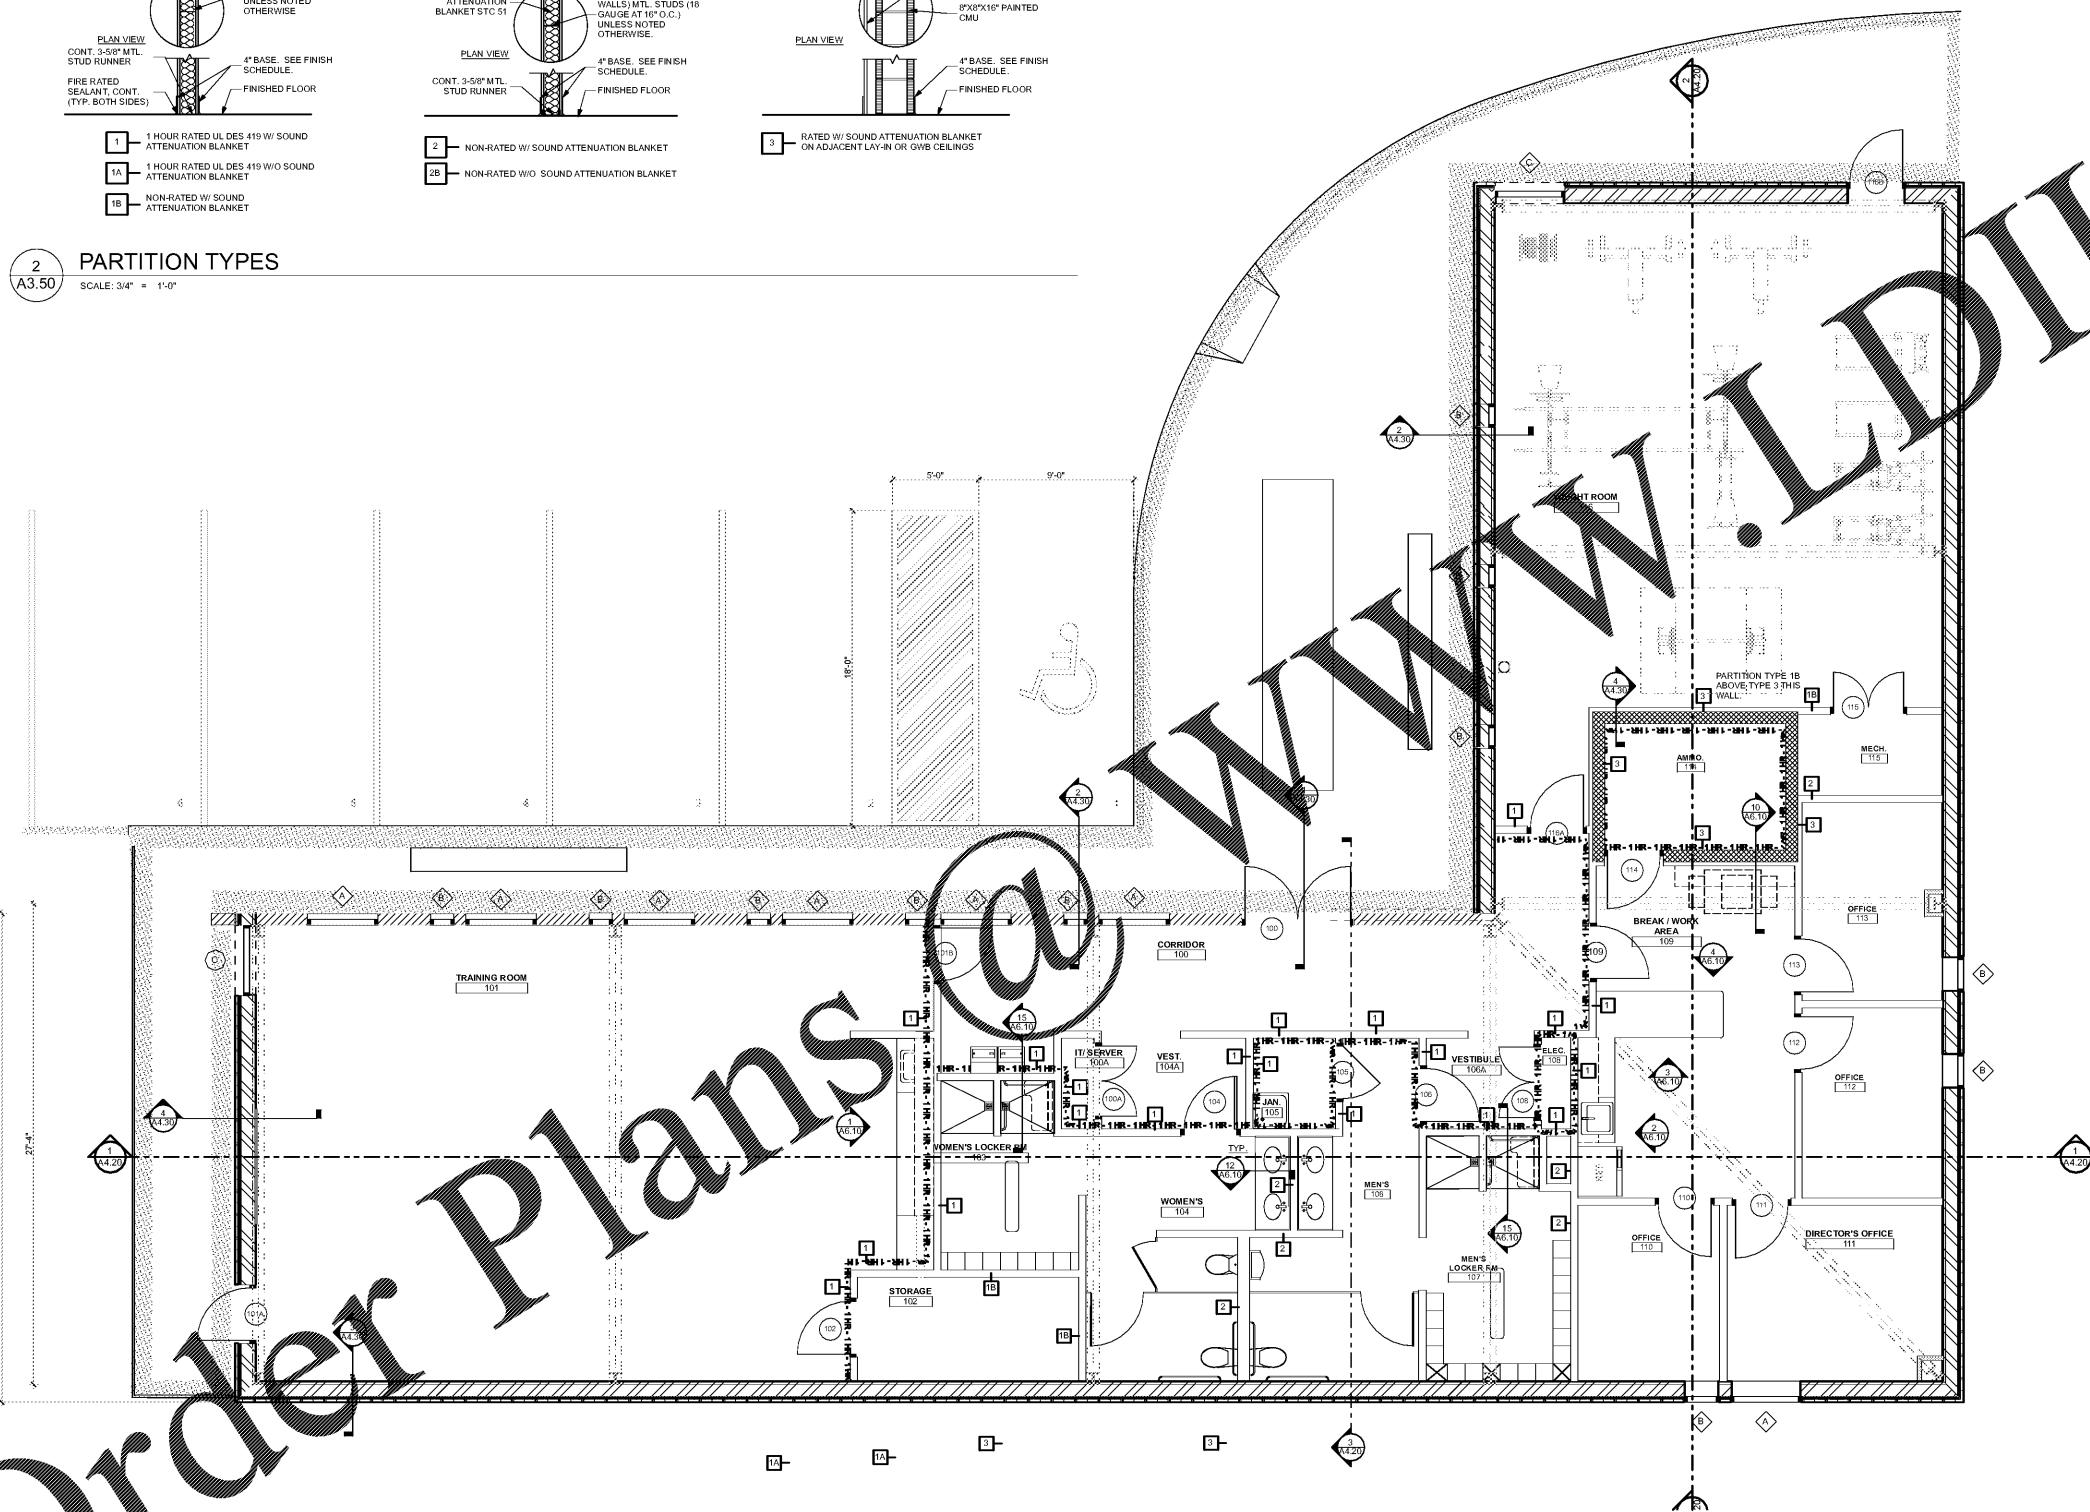

**RELOCATED TRAINING CENTER
 FOR
 THE FLOYD COUNTY JAIL**
 2526 NEW CALHOUN HIGHWAY N.E.
 ROME, GEORGIA 30161

DATE	REVISION

PROJECT NO:
420.03.01
 DATE:
JULY 17, 2018
 DRAWING TITLE:
REFERENCE PLAN

A3.50

THIS DRAWING AND ANY REPRODUCTIONS THEREOF ARE THE PROPERTY OF EAOC ARCHITECTS, INC. AND MAY NOT BE REPRODUCED OR TRANSMITTED IN ANY FORM OR BY ANY MEANS, ELECTRONIC OR MECHANICAL, WITHOUT THE EXPRESS WRITTEN PERMISSION OF EAOC ARCHITECTS, INC.

BIM Server: PEA Server 2\420.03.01 Floyd Co Training Facilities