




5525 Interstate North Pkwy
Suite 200
Atlanta, GA 30328
404-965-1287 tel
404-601-9859 fax
cauliga@westside-engineering.com



BEACOCK ARCHITECTS
5525 INTERSTATE NORTH PKWY
ATLANTA, GEORGIA 30328
404-214-5200 PHONE
404-214-5208 FAX

KEYNOTES:

- ① LEGRAND TVSYN5 3 GANG RECESSED TV BOX. COORDINATE MOUNTING HEIGHT OF CATV, DATA, RECEPTACLE DEVICE WITH ARCHITECT.
- ② RECEPTACLE SHALL BE DUPLEX NEMA 5-20 WITH DEDICATED NEUTRAL FOR FITNESS EQUIPMENT.
- ③ MOUNT JUNCTION BOX AND RECEPTABLES IN CEILING FOR PROJECTOR, COORDINATE LOCATION WITH A/V PROVIDER.
- ④ COORDINATE REQUIREMENTS AND SWITCH LOCATION FOR PROJECTION SCREEN WITH A/V PROVIDER. SCREEN LOCATED IN SOFFIT ABOVE.
- ⑤ HAND DRYER, 12.2A, 120V, 1PH. COORDINATE MOUNTING HEIGHT WITH ARCHITECTURAL ELEVATIONS.
- ⑥ FLOOR BOXES IN THE TILE/CARPET AREA TO BE WIREMOLD WALKER "OMNIBOX" OR APPROVED EQUAL. FLOOR BOX SHALL BE WITH ALL REQUIRED DEVICES AND ACCESSORIES FOR A PROPER INSTALLATION.
- ⑦ DATA/TELEPHONE/CATV/CONTROLS CONDUIT(S) TO BE WITHIN SLAB. CONTROLS CONDUIT TO BE RUN OVERHEAD TO PROJECTOR LOCATION. COORDINATE EXACT REQUIREMENTS IN FIELD.
- ⑧ SURFACE MOUNT OUTLETS & RACEWAY WITHIN THIS ROOM.
- ⑨ PROVIDE GROUND BUS WITH #6G TO MAIN ELECTRICAL SERVICE GROUND. PROVIDE (1) 4" TO EXTERIOR FOR LOW VOLTAGE.
- ⑩ PROVIDE 2" FROM PROJECTOR TO FLOOR BOX FOR A/V CONNECTION.

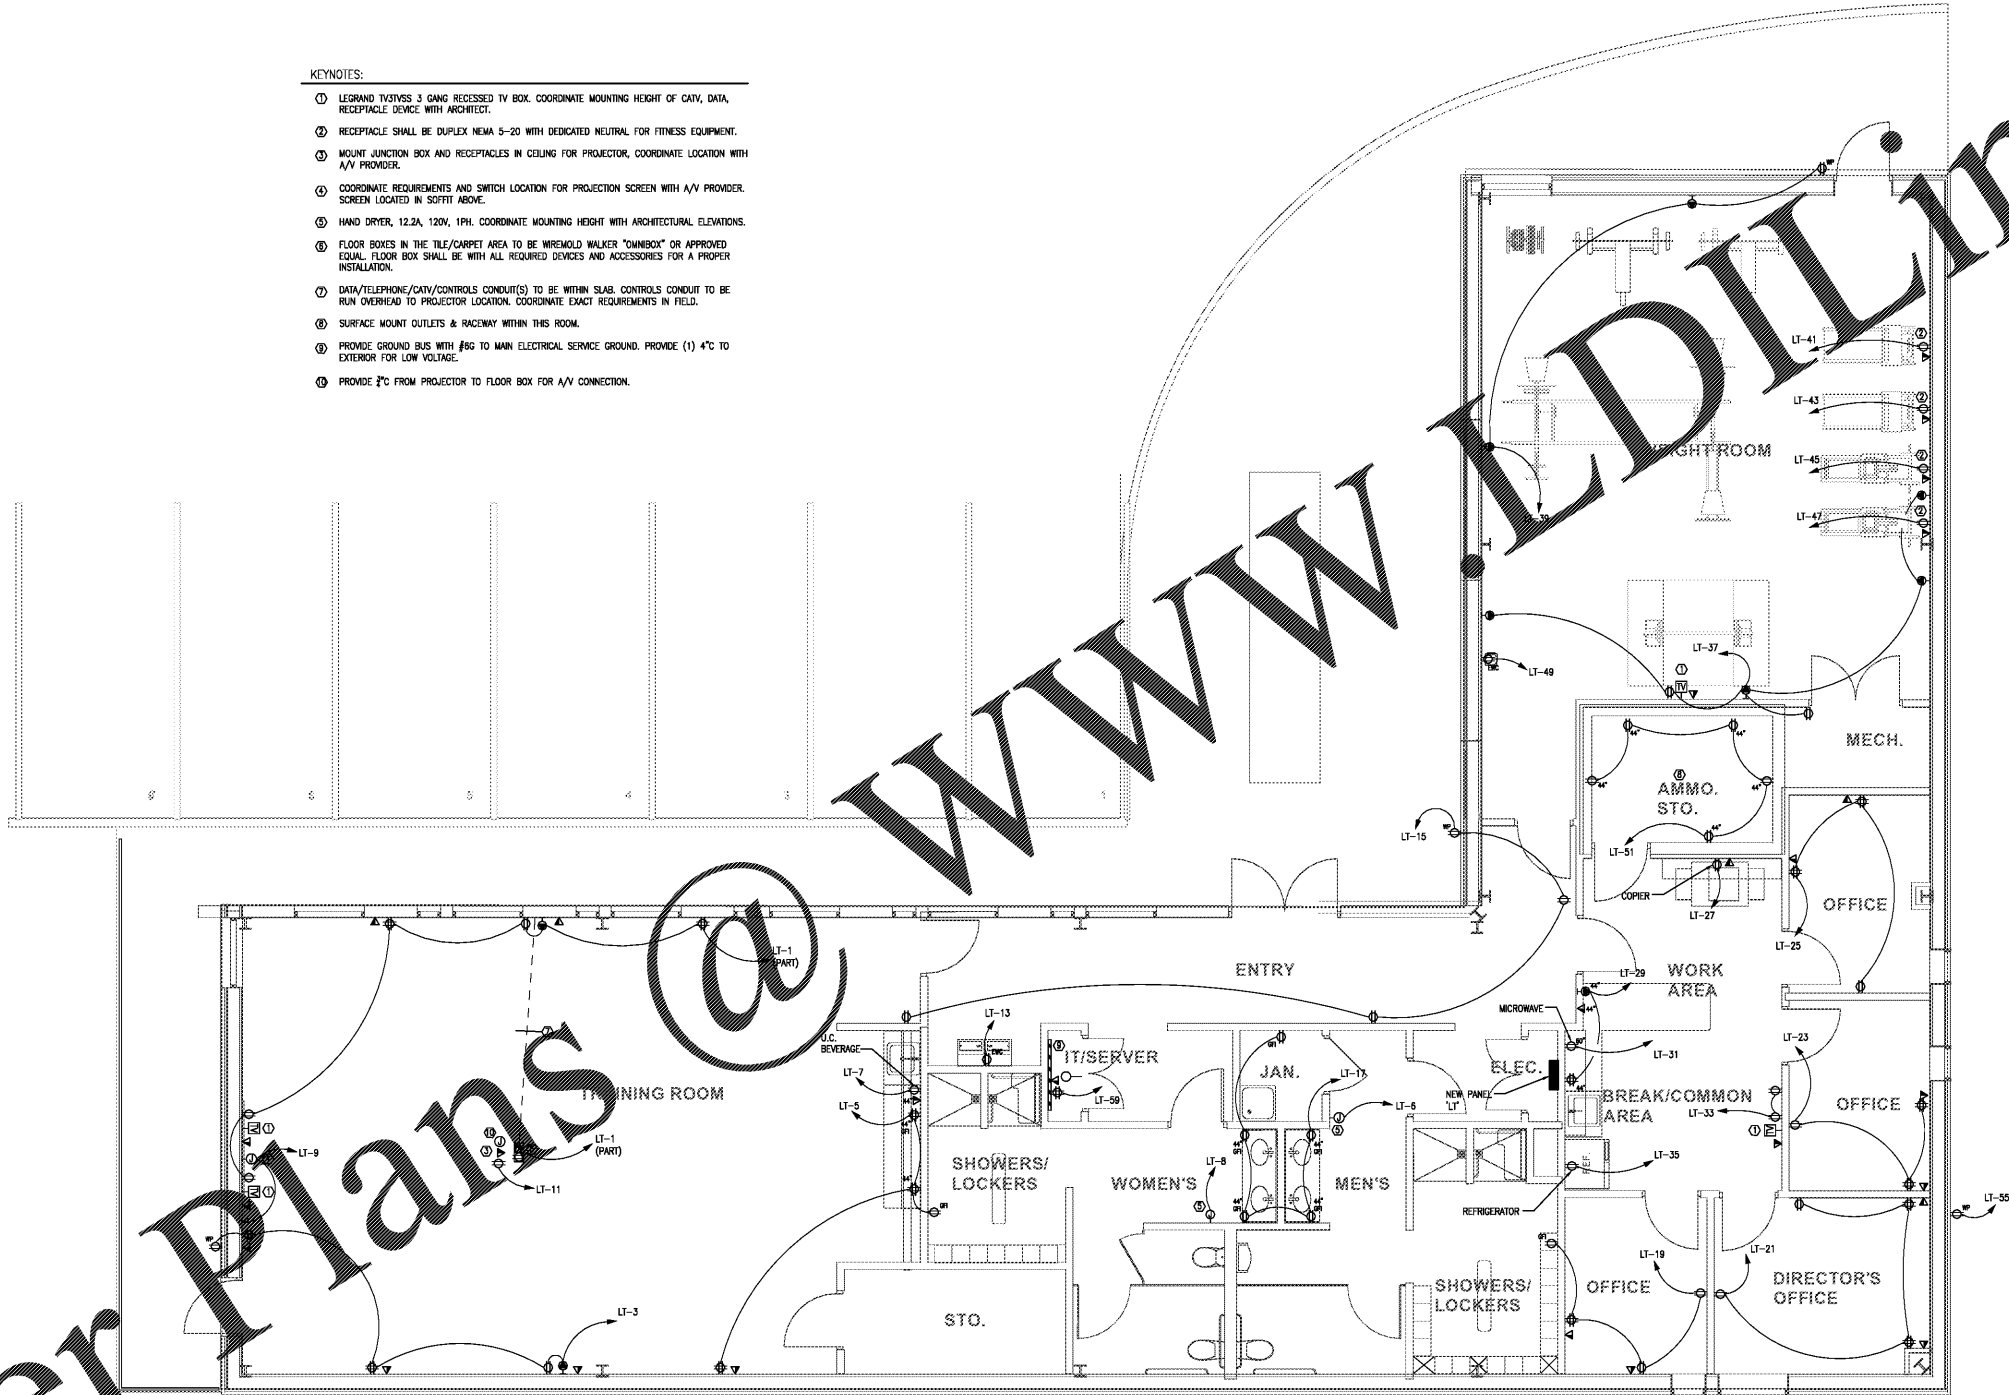

Order Plans @

WWW.LDILine.com

RELOCATED TRAINING CENTER
FOR
THE FLOYD COUNTY JAIL
2526 NEW CALHOUN HIGHWAY N.E.
ROME, GEORGIA 30161



DATE	REVISION

PROJECT NO:
420 03 01
DATE:
JULY 17, 2018
DRAWING TITLE:
ELECTRICAL POWER PLAN

1
E1.10 ELECTRICAL POWER PLAN
SCALE: 1/4" = 1'-0"

E1.10

THIS DRAWING AND ANY REPRODUCTIONS ARE THE PROPERTY AND COPYRIGHT OF BEACOCK ARCHITECTS, INC. AND MAY NOT BE USED IN ANY MANNER WITHOUT THE EXPRESSED WRITTEN PERMISSION OF BEACOCK ARCHITECTS, INC.