


Order Plans @

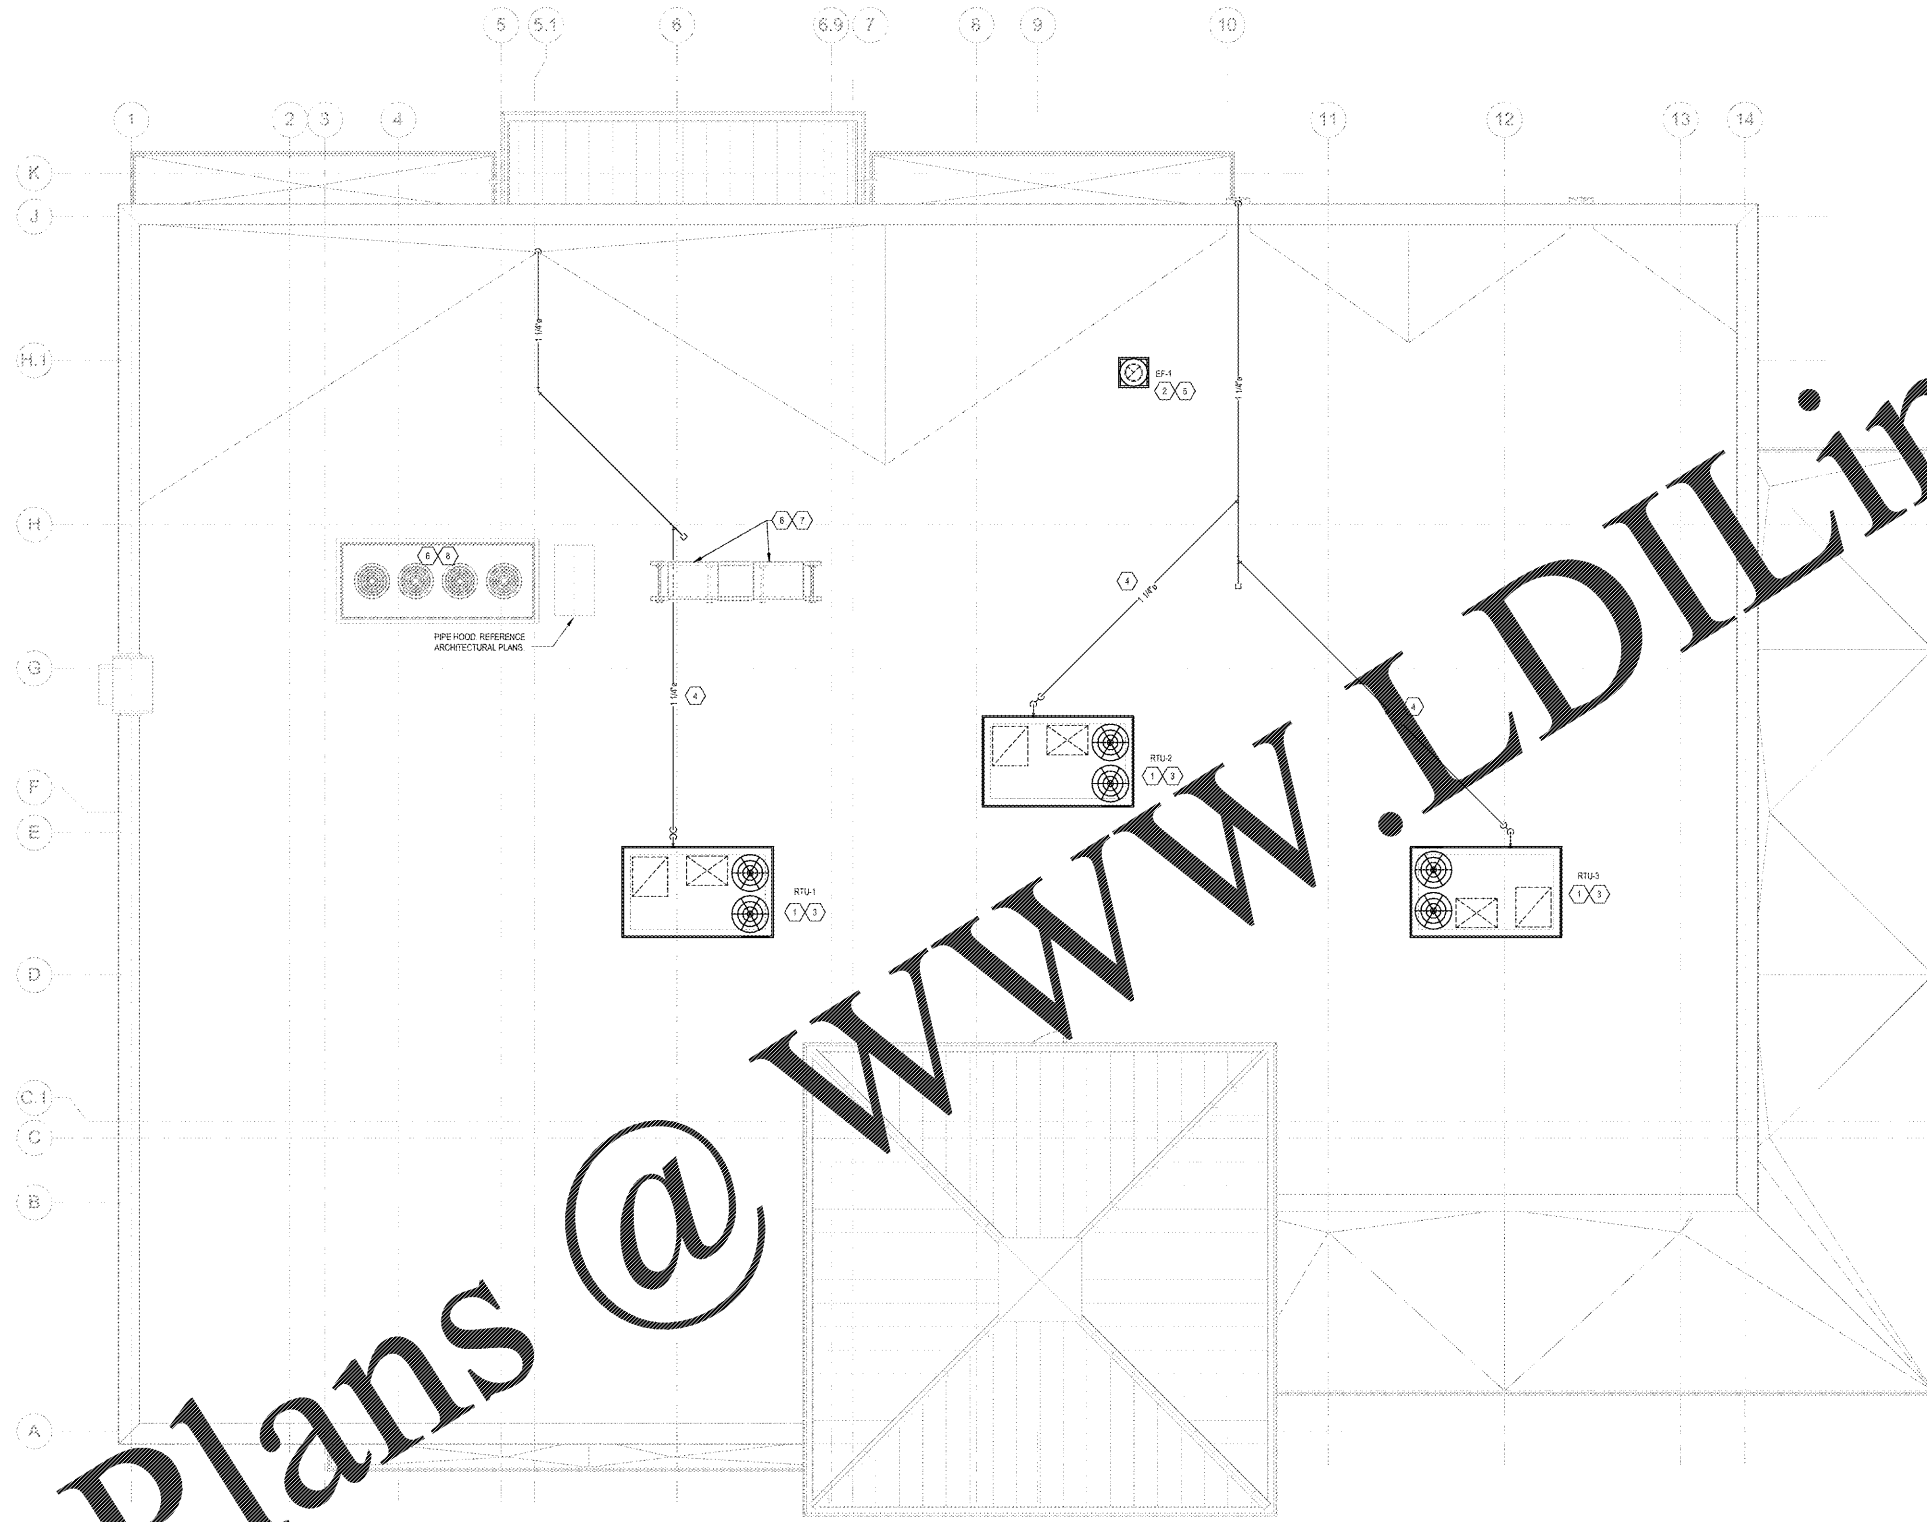

HVAC ROOF PLAN
1/4" = 1'-0"

- KEY NOTES:**
- 1 FACTORY INSTALLED SMOKE DETECTOR IN MAIN SUPPLY AND RETURN OF EACH ROOF FAN UNIT.
 - 2 INSTALL ROOF MOUNTED EXHAUST FAN PER DETAIL SHEET M3. COORDINATE EXACT LOCATION OF PENETRATION WITH ARCHITECTURAL ROOF PENETRATION CALL OUTS. PROVIDE AS NECESSARY FROM FAN INTO CEILING/CLOSET SPACE. SEE SHEET M1 FOR CONTINUATION.
 - 3 PROVIDE FLEXIBLE CONNECTION BETWEEN DUCTWORK AND MECHANICAL UNITS.
 - 4 ROUTE SOIL GAS PVC CONDENSATE DRAIN PIPING ALONG ROOF. SUPPORT AND DETAIL ON SHEET M3.
 - 5 HANGTAG A MINIMUM 18" FROM OUTSIDE OF UNITS AND EXHAUST FANS ON ROOF.
 - 6 FOOD SERVICE REFRIGERATION EQUIPMENT PROVIDED BY OTHERS.
 - 7 FOOD SERVICE REFRIGERATION EQUIPMENT MOUNTED ON ENGINEERED RACK. REFER TO "CONDENSING COILS" SUPPORT DETAIL ON ARCHITECTURAL SET FOR FLORIDA PRODUCT APPROVAL INFORMATION.
 - 8 FOR SPECIFIC WIND LOADING REQUIREMENTS NOT TO EXCEED 180 MPH. SEE STRUCTURAL DRAWINGS.
- SHEET GENERAL NOTE:**
CONTRACTOR RESPONSIBLE FOR USING CURBS PLUS CLIPS ON ALL RTUs. CLIPS ARE DELIVERED TO SITE AS SEPARATE PACKAGE.

Cutler & Peterson
Engineers
Architects
Interior Designers
15000 Westchase Avenue, Suite 100
Houston, TX 77060
Tel: 281.465.1100
Fax: 281.465.1101
www.cutlerandpeterson.com

CLIENT NAME:
WAWA
280 WEST BALTIMORE PIKE
WAWA, PENNSYLVANIA 19053

PROJECT NAME:
WAWA F85FB 2018.01 STORE #5275-LIT
9021 STATE ROAD 52
HUDSON, FL 34689

SHEET TITLE:
HVAC ROOF PLAN

Revision Schedule	
No.	Description
1	PRELIMINARY
2	PRELIMINARY
3	PRELIMINARY
4	PRELIMINARY
5	PRELIMINARY
6	PRELIMINARY
7	PRELIMINARY
8	PRELIMINARY
9	PRELIMINARY
10	PRELIMINARY
11	PRELIMINARY
12	PRELIMINARY
13	PRELIMINARY
14	PRELIMINARY
15	PRELIMINARY
16	PRELIMINARY
17	PRELIMINARY
18	PRELIMINARY
19	PRELIMINARY
20	PRELIMINARY
21	PRELIMINARY
22	PRELIMINARY
23	PRELIMINARY
24	PRELIMINARY
25	PRELIMINARY
26	PRELIMINARY
27	PRELIMINARY
28	PRELIMINARY
29	PRELIMINARY
30	PRELIMINARY
31	PRELIMINARY
32	PRELIMINARY
33	PRELIMINARY
34	PRELIMINARY
35	PRELIMINARY
36	PRELIMINARY
37	PRELIMINARY
38	PRELIMINARY
39	PRELIMINARY
40	PRELIMINARY
41	PRELIMINARY
42	PRELIMINARY
43	PRELIMINARY
44	PRELIMINARY
45	PRELIMINARY
46	PRELIMINARY
47	PRELIMINARY
48	PRELIMINARY
49	PRELIMINARY
50	PRELIMINARY

PROJECT NO.: 210102
DATE: 03/24/2017
DESIGNER: JLD
DRAWN: JLD

M2