


GSA

GENERAL SERVICES ADMINISTRATION  
PUBLIC BUILDING SERVICE  
DESIGN & CONSTRUCTION DIVISION  
77 FORSYTH STREET, SUITE G4  
ATLANTA, GA 30303



**AKEA INC.**  
3603 NW 98th Street, STE B  
Gainesville, FL 32606  
Phone: (352) 474-6124  
COA: FL #26693

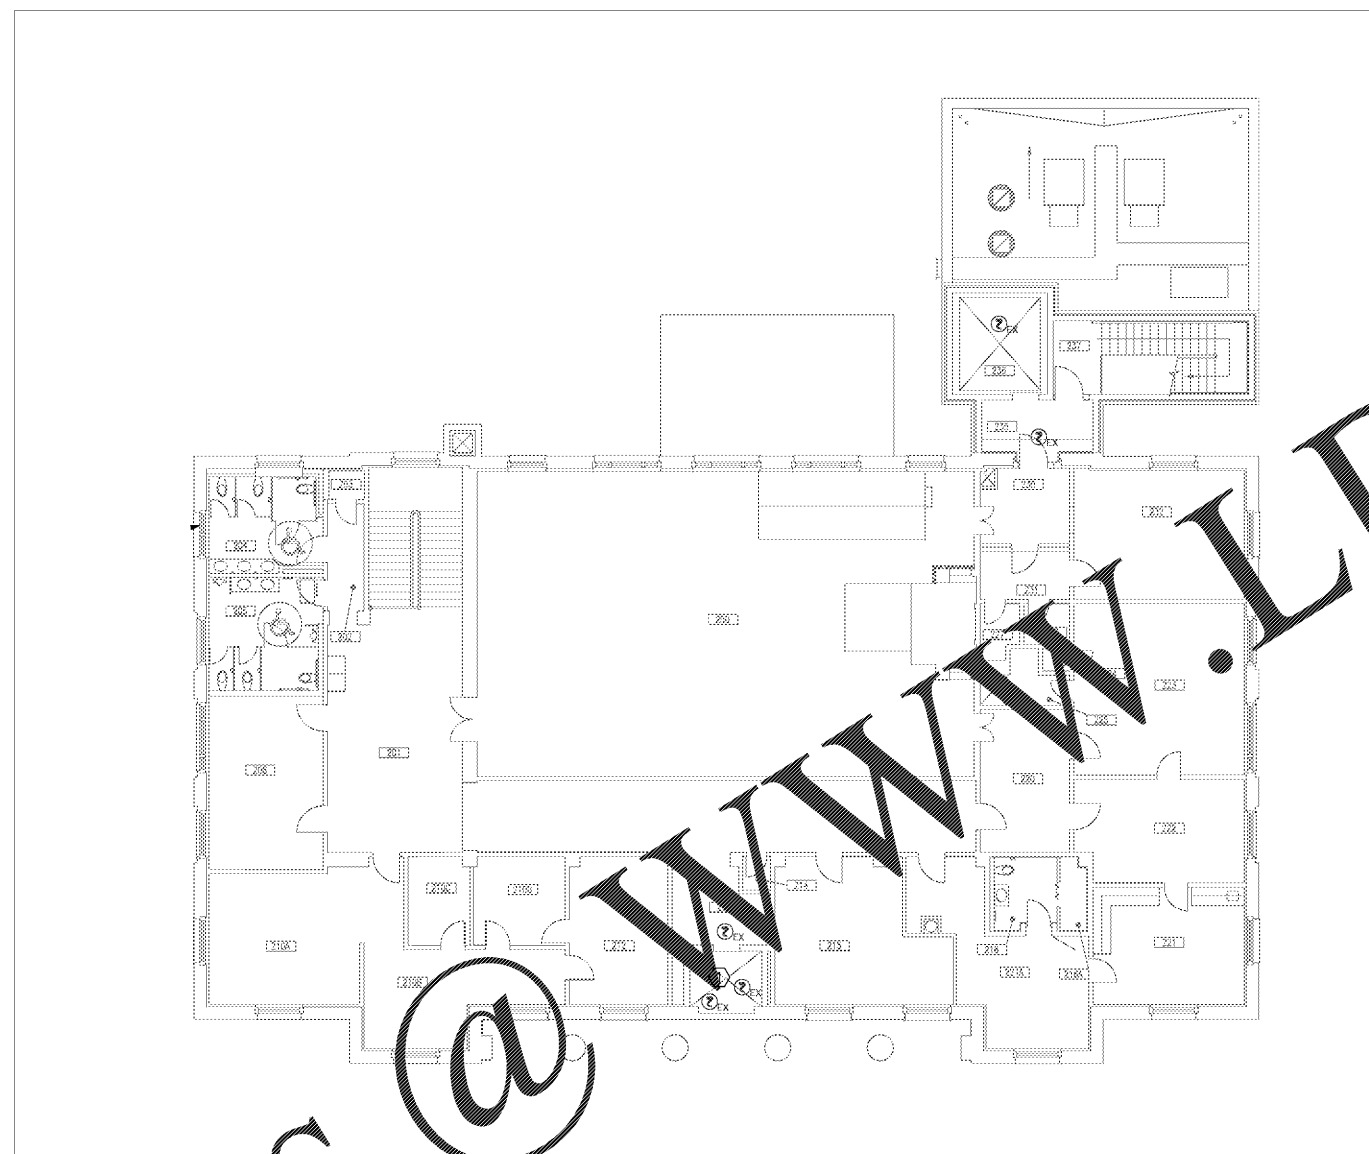

2ND FLOOR - PARTIAL FIRE ALARM LAYOUT

0 8' 16'  
SCALE: 1/8"=1'-0"


**SHEET NOTES**

 1. THERE ARE CURRENTLY TWO (2) SMOKE DETECTORS AT THE TOP OF THE ELEVATOR SHAFT WHICH ARE NOT IN-SERVICE. DETECTORS SHALL BE REMOVED PER NFPA 72, 21.3.6. ASSURE ALL FIRE ALARM WIRING IN THE ELEVATOR SHAFT IS INSTALLED IN RIGID CONDUIT PER THE REQUIREMENTS OF NFPA 70 & 72. THE UNUSED SMOKE DETECTORS AND RELATED WIRING/CONDUIT SHALL BE COMPLETELY REMOVED.


Order Plans @

WWW.LDILine.com

KEY PLAN



CAD FILE INFORMATION

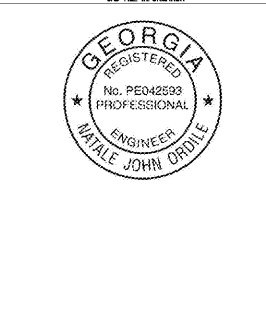

REVISION NUMBER	REVISION DESCRIPTION	REVISION DATE

GRAPHIC SCALE

CONTIN. A/E	GS-04P-16-EX-C-7070
CONSTRUCT.	EQ4PC1-16-5002
PRIME A/E	AKEA, INC.
ADDRESS	3603 NW 98TH STREET GAINESVILLE FL 32606
PRIME A/E	JAMEY CLAYTON
SUB A/E	NEPTUNE FIRE PROTECTION ENG. LLC
ADDRESS	60 OCEAN BLVD., STE. 6 ATLANTIC BEACH FL 32233
SUB A/E	
ADDRESS	
NAME	J. ROY ROWLAND CT
ADDRESS	300 NORTH FRANKLIN ST. DUBLIN GA 31021
BLDG NO.	GAD0336ZZ
ADDT. FACILITY	
TITLE	INSTALL FIRE SPRINKLER SYSTEM
DESCRIPTION	DESIGN-BUILD (DB) FIRE SPRINKLER SYSTEM
PERMISSION	100% DRAWINGS SUB. DATE 3/07/2018
PROJ. MGR.	MICHAEL POPE
SEAL ENCL.	ARNOLD J. HEDT, III
PROJ. NO.	VG400038 / EQ4PC1-16-5002
DRAWN BY	CEG DATE DRAWN 3/06/2018
CHKD BY	NJO DATE CHKD 3/06/2018
FILE NAME	FP_DRAWINGS.DWG
FLOOR NO.	2ND FLOOR
TITLE	2ND FLOOR - PARTIAL FIRE ALARM LAYOUT
NUMBER	12 of 20
FA-4	
DISCIPLINE	SHEET TYPE
	SEQUENCE

MARCH 7, 2018  
100% DRAWINGS  
APPROVED FOR CONSTRUCTION