


**INSTALLATION NOTES**


1. INTERIOR PIPING BEGINS WITH BACKFLOW PREVENTER.
2. ALL INTERIOR PIPING IS SHOWN ON FP DRAWINGS

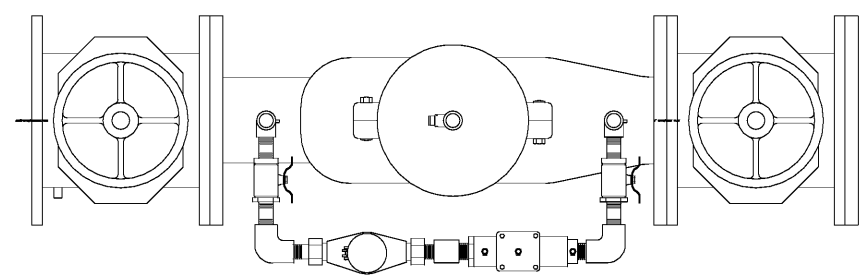

4" BACKFLOW PREVENTER  
SCALE: N.T.S.

**NOTES**

1. EQUIPMENT DETAIL, MANUFACTURER, AND INSTALLATION AND OPERATING INSTRUCTIONS WILL BE APPROVED BY PRODUCT SUBMITTAL
2. SEE FP DRAWINGS

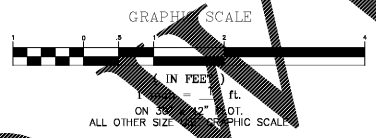

LEGEND	
	NEW ASPHALT PAVEMENT
	EXISTING ASPHALT PAVEMENT
	EXISTING CONCRETE
	EXISTING SANITARY
	EXISTING WATER LINE
	EXISTING GAS LINE

**UTILITY NOTES**

1. CONTRACTOR TO PHYSICALLY LOCATE AND EXPOSE ALL UTILITIES PRIOR TO COMMENCEMENT OF CONSTRUCTION TO ENSURE THERE ARE NO CONFLICTS OF NEW CONSTRUCTION WITH EXISTING UTILITIES. CONTRACTOR SHALL RE-VERIFY EXISTING UTILITIES DURING EXCAVATION ACTIVITIES.

**INTERIOR SUPPLY PLAN**

SCALE: 1" = 1' ON 30" x 42" PLOT

**NOTES**

1. ALL INTERIOR FIRE LINE PIPING SHOWN ON FIRE PROTECTION DRAWINGS. SEE FP DRAWINGS.
2. ALL WALL PENETRATIONS SHALL BE PROPERLY CONSTRUCTED AND SEALED WITH LINK SEAL OR APPROVED EQUAL.

**GSA**  
GENERAL SERVICES ADMINISTRATION  
PUBLIC BUILDING SERVICE  
DESIGN & CONSTRUCTION DIVISION  
77 FORSYTH STREET, SUITE G4  
ATLANTA, GA 30303

**AKEA INC.**  
3603 NW 98th Street, STE B  
Gainesville, FL 32606  
Phone: (352) 474-6124  
COA: FL #26693 EXP 02/28/19  
Project Number: 121-16

REVISION NUMBER	REVISION DESCRIPTION	REVISION DATE

NO.	DATE	BY	DESCRIPTION

NO.	DATE	BY	DESCRIPTION

CONTIN.	GS-04P-16-EX-C-7070
CONSTRUCT.	FQ4PC1-16-5002
PRIME A/E	AKEA, INC.
ADDRESS	3603 NW 98TH STREET
	GAINESVILLE FL 32606
PRIME A/E	JAMEY CLAYTON
SUB A/E	NEPTUNE FIRE PROTECTION ENG. LLC
ADDRESS	80 OCEAN BLVD., STE. 15
	ATLANTIC BEACH FL 32233
SUB A/E	
ADDRESS	
CITY	
STATE	
ZIP	
NAME	J. ROY ROWLAND CT
ADDRESS	300 NORTH FRANKLIN ST.
	DUBLIN
	GA
ZIP	31021
BLDG. NO.	GAD03362Z
ADJ. FACILITY	OTHER FACILITY NAME
TITLE	INSTALL FIRE SPRINKLER SYSTEM
DESCRIPTION	DESIGN-BUILD (DB)
	FIRE SPRINKLER SYSTEM
SUBMISSION	100%
DATE	11/17/2017
PROJ. MGR.	MICHAEL POPE
DESIGNER	ARNOLD J. HEDDT, III
PROJ. NO.	VG400038 / FQ4PC1-16-5002
DRAWN BY	MDT
DATE DRAWN	11/17/2017
CHK BY	MDT
DATE CHK	11/17/2017
FILE NAME	C200
FLOOR NO.	GROUND
TITLE	UTILITY PLAN-INTERIOR FIRE SUPPLY
NUMBER	C300 16 of 20
DISCIPLINE	
SHEET TYPE	
SEQUENCE	

MARCH 9, 2018  
100% DESIGN SUBMITTAL  
NOT APPROVED FOR CONSTRUCTION