


DRAWING ISSUE RECORD		
DATE	REVISIONS	NO.
11-1-18	ISSUE TO BID	

HARMONY LELAND-COOPER
 REPLACEMENT ELEMENTARY SCHOOL
 6326 FACTORY SHOALS DRIVE
 HABLETON, GA 30226
 FOR COBB COUNTY SCHOOL DISTRICT
 CCSD PROJECT NO. 0-0094 / DOE FACILITY CODE 0186


DATE: JUL 16, 2018
 JOB NO. 58-1-2001-18
 DRAWN BY: AK
 CHECKED BY: CK
 CUNNINGHAM, FOREHAND, MATTHEWS & MOORE, ARCHITECTS, INC. - 2011 MANCHESTER STREET, N.E. - ATLANTA, GEORGIA 30324 - PHONE (404) 873-2152

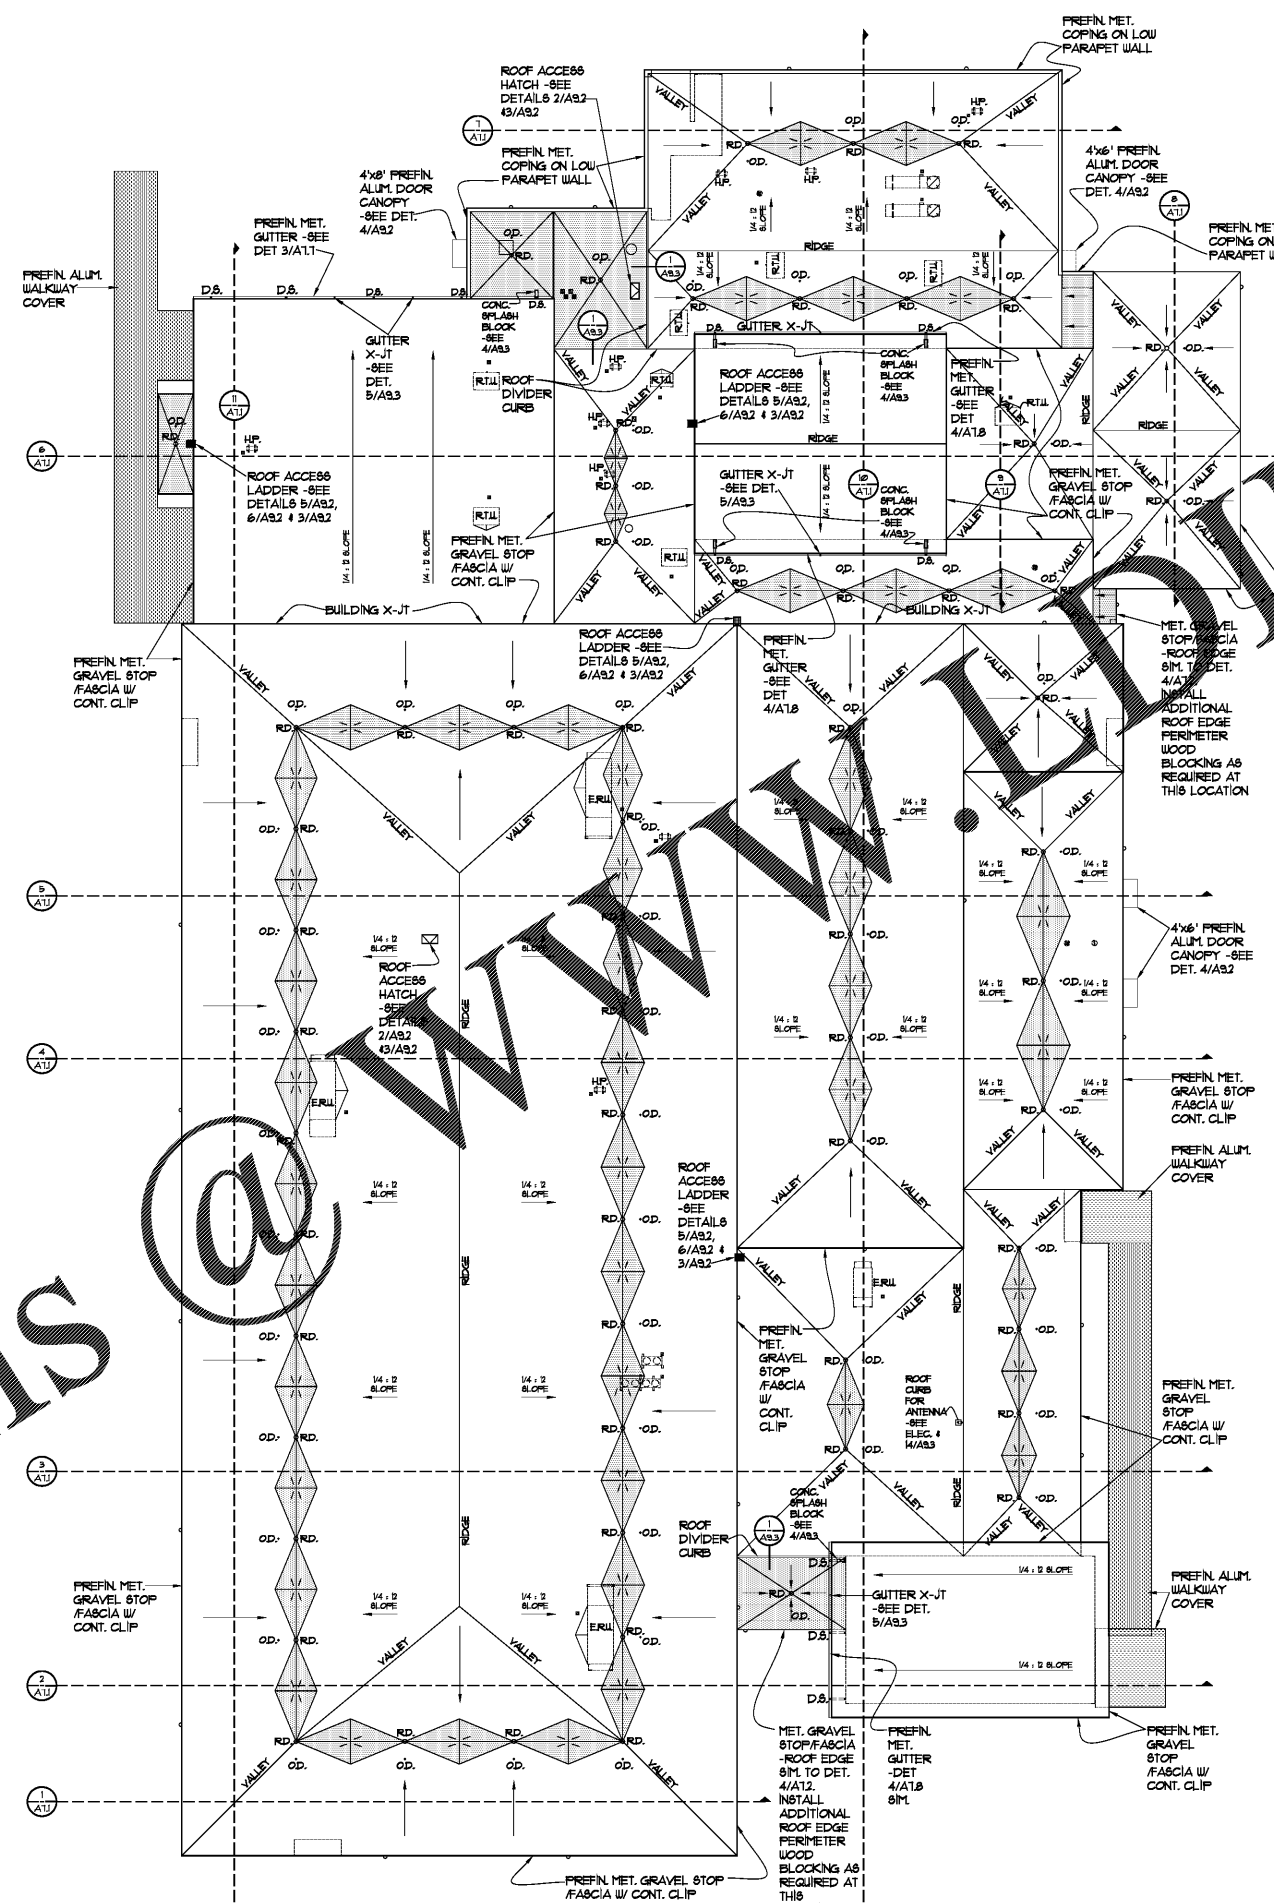

- GENERAL NOTES:**
- QUANTITIES AND LOCATIONS OF ROOF TOP MECHANICAL EQUIPMENT ARE APPROXIMATE. GEN. CONTRACTOR MUST COORDINATE EXACT ITEMS AS WELL AS SIZE AND LOCATIONS OF OPENINGS FOR STRUCTURAL SUPPORT AND ROOF PENETRATIONS. VERIFY CLEARANCES REQUIRED FOR ALL EQUIPMENT OPENINGS.
 - CONTRACTOR TO PROVIDE POSITIVE DRAINAGE AROUND ALL ROOF TOP EQUIPMENT AS NECESSARY. PROVIDE CRICKETS AS NECESSARY.
 - CONTRACTOR TO PROVIDE POSITIVE DRAINAGE TO ALL ROOF DRAINS AND GUTTERS AS SHOWN.
 - FITCH PANS ARE NOT ACCEPTABLE FOR ANY PENETRATION OF THE ROOF MEMBRANE. CONTRACTOR SHALL PROVIDE ROOF PENETRATION CURBS FOR ANY ITEMS PENETRATING ROOF.
 - ALL GAS OR ELECTRIC PIPES OR CONDUIT PENETRATING THE ROOF MEMBRANE MUST CONFORM TO DETAIL 1/A93.
 - DO NOT ALLOW PLUMBING VENT STACKS TO BE WITHIN 18\"/>

- ROOF PLAN LEGEND**
- X-JT - EXPANSION JOINT
 - B.U. - BUILT UP (ROOFING)
 - R.D. - ROOF DRAIN (SEE PLUMBING 4 DET. 12/A93)
 - O.D. - OVERFLOW DRAIN (SEE PLUMBING 4 DET. 13/A93)
 - S.B. - CONCRETE SPLASH BLOCK (SEE DET. 4/A93)
 - ER.U. - ENERGY RECOVERY UNIT (SEE MECH. AND DETAIL 5/A93)
 - R.H.V. - ROOFTOP HEATING AND VENTILATION UNIT (SEE MECH. AND DETAIL 9/A93)
 - D.S. - DOWNSPOUT AND LEADER SEE 2/A93
 - D.S.N. - STORM OVERFLOW DISCHARGE NOZZLE. SEE 6/A93
 - E.F. - ROOFTOP EXHAUST FAN (SEE MECH. 4 DET. 8/A93)
 - S.F. - ROOFTOP SUPPLY FAN (SEE MECH.)
 - I.C. - ROOFTOP INTAKE CAP (SEE MECH.)
 - C.U. - ROOFTOP CONDENSING UNIT (SEE MECH.)
 - H.P. - ROOFTOP HEAT PUMP (SEE MECH.)
 - V.T.R. - VENT TO ROOF (SEE PLUMBING- 11/A93)
 - - INDICATES AREA OF TAPERED INSULATION

1 ROOF OVERALL PLAN
 A91 7-20-18

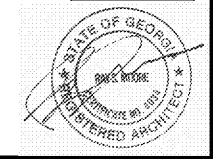

Order Plans

cunningham forehand matthews moore