

DRAWING ISSUE RECORD		
DATE	REVISIONS	NO.
11-1-18	ISSUE TO B'D	


HARMONY LELAND-CITY SCHOOL  
REPLACEMENT ELEMENTARY SCHOOL

6526 FACTORY SCHOOLS RD., NW  
MABLETON, GA 30126  
FOR COBB COUNTY SCHOOL DISTRICT  
COBB COUNTY, GA  
CCSD PROJECT NO. A047 / DDE FACILITY CODE

DATE: JUL 16, 2019  
JOB NO. B-L-2007-18  
DWG. BY G.S.H.  
CHK. BY G.L.K.

ITEM	DESCRIPTION	VOLT.
A	FREEZER	120/208-3φ 40.0
B	COOLER	120/208-3φ 11.1
25	PROOFING CABINET	120V 14.5
26	SLICER	120V 1.2
27	FOOD WARMER	120V 19.8
28	CONNECTED OVEN (DBL. STACK)	120V 204.4
29	10 GAL. KETTLE	120V 10.0
30	SECTION CUTTER	120V 1.0
31	ICE CREAM MAKER	6AS -
34	PASSOVER WARMER	120/208-1φ 10.2
35	PASSOVER REFRIGERATOR	120V 8.9
36	MILK COOLER	120V 7.1
38	20 QT. MIXER WITH STAND	120V 8.2
38	MILK COOLER	120V 8.9
39	HOT FOOD COUNTER	120/208-1φ 16.8
40	HOT FOOD COUNTER	120/208-1φ 12.0
41	COLD FOOD COUNTER	120V 8.9
42	FLAT TOP COUNTER	120V 1.0
43	CASHER'S STAND	120V 1.5
44	ICE MACHINE	120V 19.0
47	SONIC STEAMER	208-1φ 28.0
51	FLY FAN	120V 4.8
52	WASHER	120V 1.2
53	DRYER	120/208V 14.5
68	MILK COOLER	120V 14.4
73	12 GAL. KETTLE	480-3φ 15.1
77	ICE CREAM COUNTER	120V 4.6

- REFERENCED NOTES (SHEETS E2.8 & E2.4)
1. PROVIDE CONNECTIONS TO KITCHEN EQUIPMENT AS RECOMMENDED BY MANUFACTURER. EXACT LOCATIONS OF OUTLETS SHALL BE AS DIRECTED BY KITCHEN SUPPLIER'S SHOP DRAWINGS IF DIFFERENT THAN SHOWN ON PLANS.
  2. PROVIDE A CORD AND PLUG FOR ALL EQUIPMENT NOT SHIPPED WITH CORD AND PLUG BUT REQUIRES CONNECTION TO A RECEPTACLE. PLUG SHALL MATCH RECEPTACLE INSTALLED, AND CORD SHALL BE SIZED PER N.E.C.
  3. ALL 120V SERVING LINE RECEPTACLES & RECEPTACLES ON CONDUIT STUB-UP IN KITCHEN AREA SHALL BE SERVED WITH GFI BREAKERS (SEE PANEL SCHEDULES).
  4. RUN 120V FROM LIGHTING CIRCUIT THRU EMERGENCY SHUT-OFF CONTACT IN SUPPRESSION SYSTEM TO SHUNT TRIP MAIN BREAKERS IN UDS.
  5. CONNECT TO UDS AS DIRECTED BY SUPPLIER'S SHOP DRAWINGS.
  6. VERIFY PLUG TYPES ON ALL KITCHEN EQUIPMENT BEFORE PURCHASING AND INSTALLING RECEPTACLES. PROVIDE RECEPTACLE TO MATCH PLUG PROVIDED ON EQUIPMENT.
  7. CIRCUITING OF WALK-IN FREEZER AND COOLER SUPPLIED MAY NOT BE THE SAME AS SHOWN. PROVIDE WIRING AS SHOWN ON SUPPLIER'S SHOP DRAWINGS.
  8. SEAL CONDUIT BETWEEN HOT AND COLD AREAS - SEE 4/E2.4.
  9. INSTALL AND CONNECT TO LIGHT FIXTURES, DOOR HEATERS AND SWITCHES FURNISHED WITH WALK-IN FREEZER/COOLER.
  10. INSTALL RECEPTACLE AT 84" AFF FOR FAN AND SWITCH CIRCUIT WITH SWITCH INSTALLED AT 48" AFF.
  11. SEE MECH. EQUIP. LEGEND ON SHEET E6.2 FOR CONDUCTOR SIZES.
  12. EMERGENCY SHUT-OFF - RED MUSHROOM PUSH-BUTTON W/ SINGLE POLE, MOMENTARY CONTACT, 120V, CONTACT BLOCK IN FLUSH OUTLET BOX. INSTALL RED PLASTIC SIGN ABOVE SWITCH READING "BOILER EMERGENCY SHUT-OFF". CONNECT TO BOILER CONTROL SHUNT TRIP CIRCUIT BREAKERS.
  13. ALL RECEPTACLES IN SERVING LINE KNEE WALL SHALL HAVE WEATHERPROOF IN-USE COVERS.
  14. CONNECT TO HEAT TAPE AND WATER LEVEL SENSOR. SEE MECHANICAL AND PLUMBING FOR LOCATIONS.
  15. MOUNT ALL DEVICES IN KITCHEN OFFICE 42" AFF TO BE ABOVE COUNTER SURFACE.
  16. ROUTE ALARM BELL CIRCUIT THROUGH FLOW SWITCHES (GTY.=S) IN PARALLEL SO THAT ANY FLOW SWITCH ACTIVATES BELL.

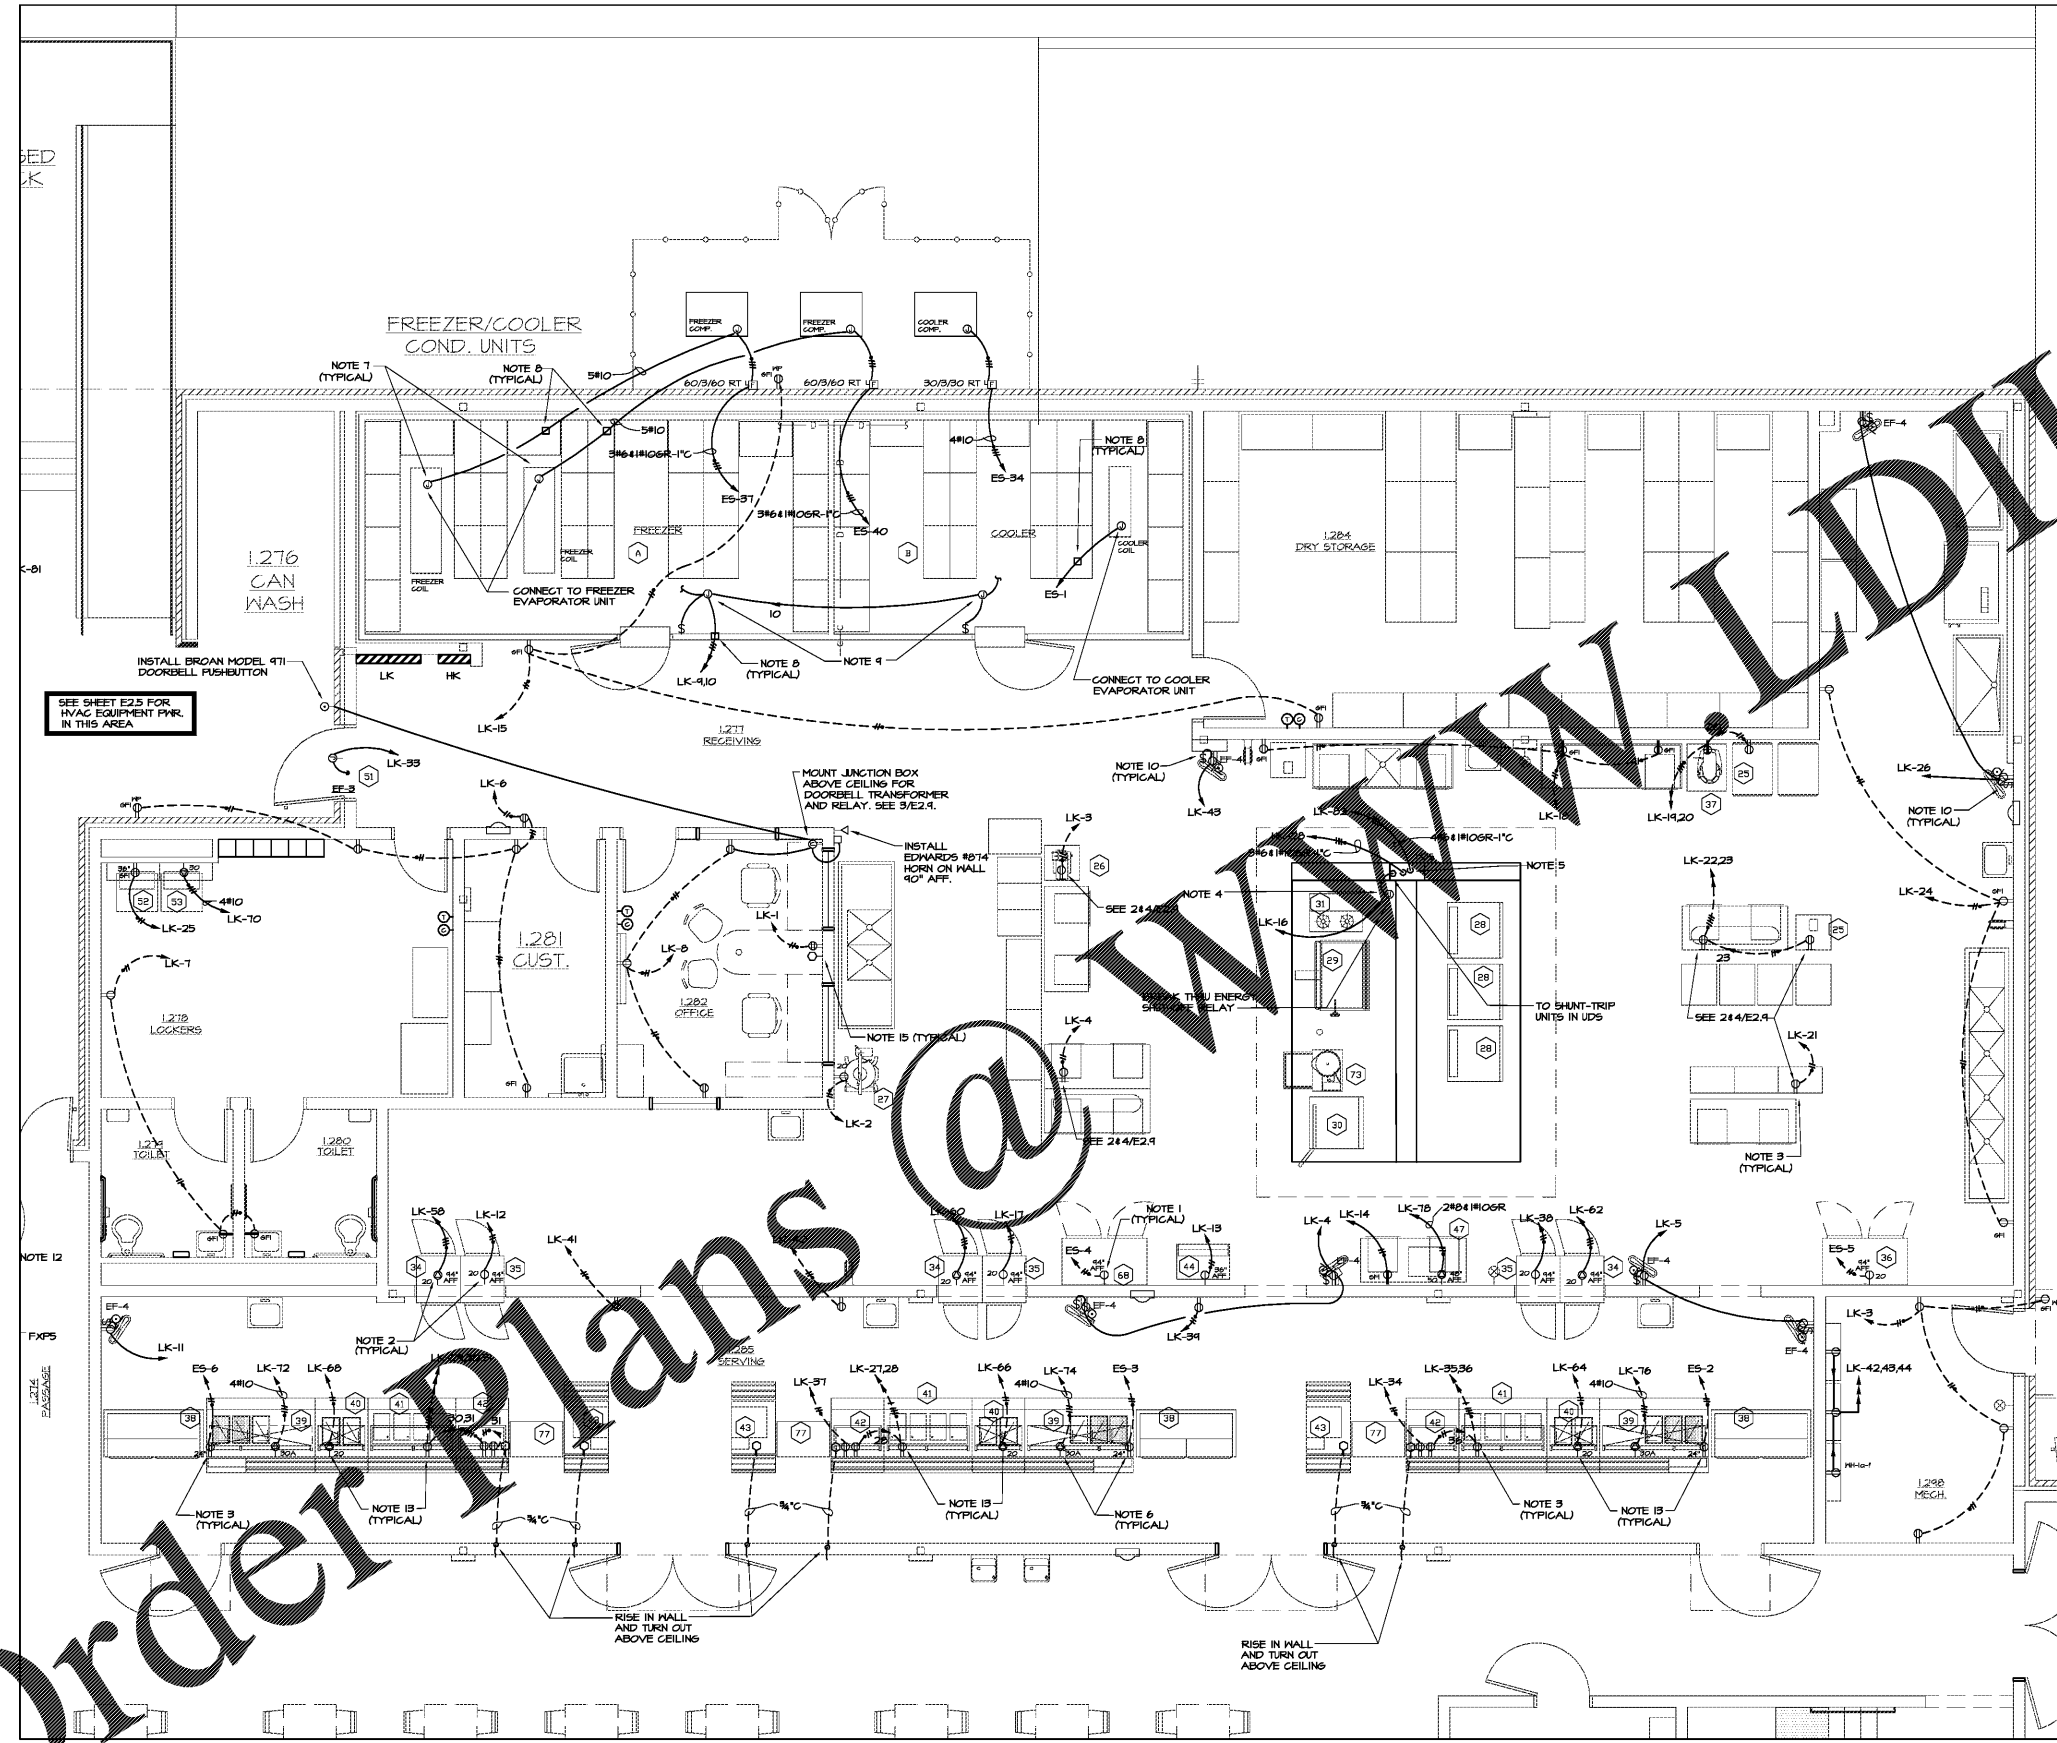

1 ENLARGED KITCHEN FLOOR PLAN - POWER  
E2.7 1/8"=1'-0"



cunningham forehand matthews moore

cunningham, forehand, matthews & moore, architects, inc. - 2011 manchester street, n.e. - atlanta, georgia 30324 - phone (404) 873-2152