


| DRAWING ISSUE RECORD |              |     |
|----------------------|--------------|-----|
| DATE                 | REVISIONS    | NO. |
| 11-1-18              | ISSUE TO B'D |     |
|                      |              |     |
|                      |              |     |
|                      |              |     |

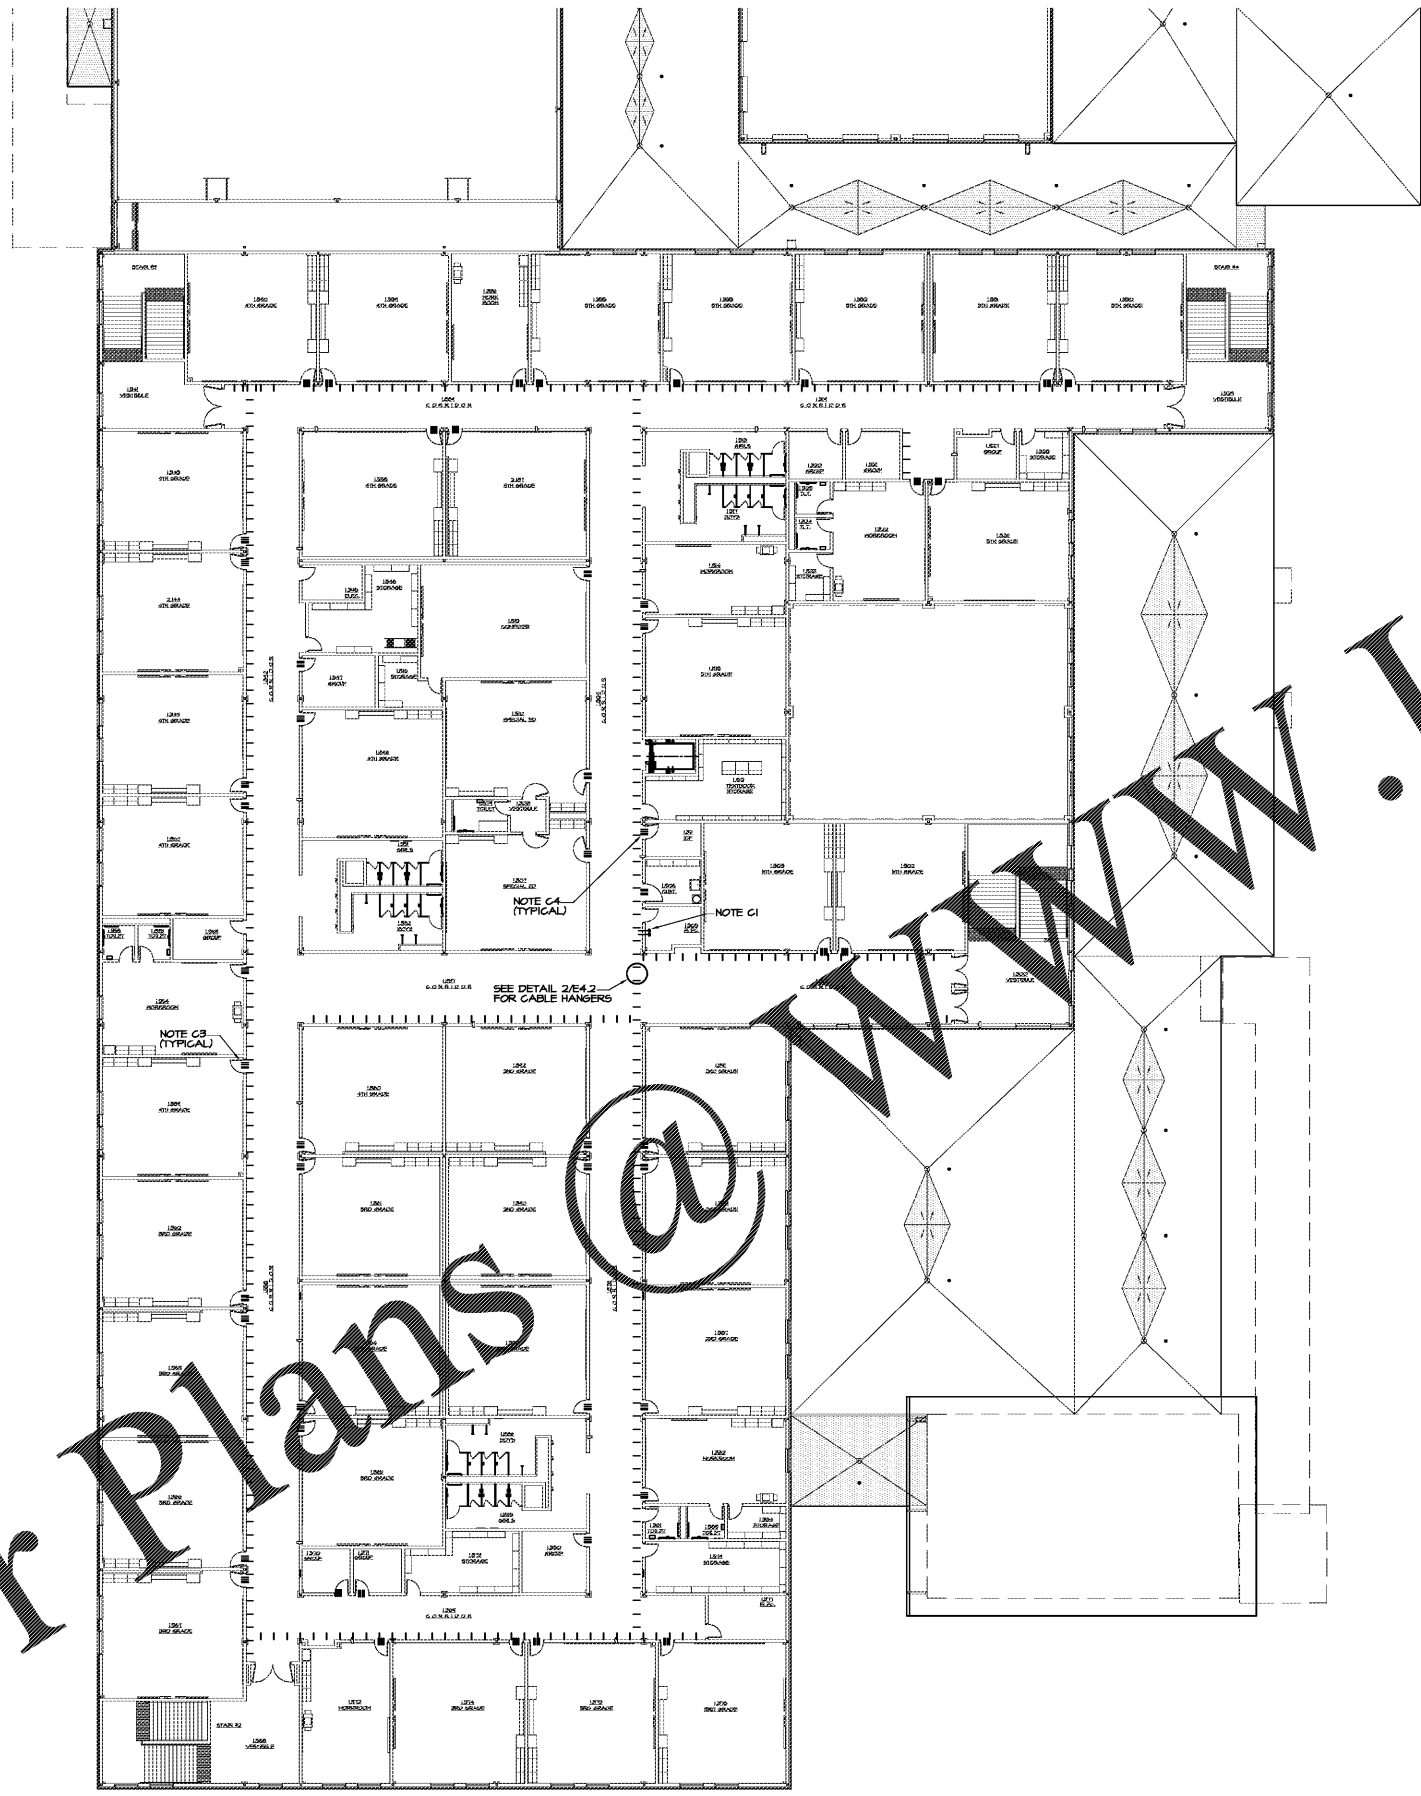

SEE SHEET E4.2 FOR REFERENCE NOTES.

1 UPPER LEVEL FLOOR PLAN - CABLE HOOKS  
E4.3 1/16"=1'-0"



**SPURLOCK & ASSOCIATES, INC.**  
consulting engineers  
2970 Clairmont Rd., Suite 420 | Atlanta, GA 30329  
P: 404.433.0245 | F: 404.433.1736  
JOB NO. 1822

HARMONY LELAND-CITY SCHOOL  
REPLACEMENT ELEMENTARY SCHOOL  
6526 FACTORY SQUARE RD., NW  
MABLETON, GA 30126  
FOR COBB COUNTY SCHOOL DISTRICT  
COBB COUNTY, GA  
CCSD PROJECT NO. A008 / ODE FACILITY CODE

**cunningham forehand matthews moore**

cunningham, forehand, matthews & moore, architects, inc. - 2011 manchester street, n.e. - atlanta, georgia 30324 - phone (404) 873-2152

DATE: JULY 16, 2018  
JOB NO.: B-L-1007-18  
DWG. BY: G.S.H.  
CHK. BY: G.L.K.