


DRAWING ISSUE RECORD		
DATE	REVISIONS	NO.
11-1-18	ISSUE TO B'D	

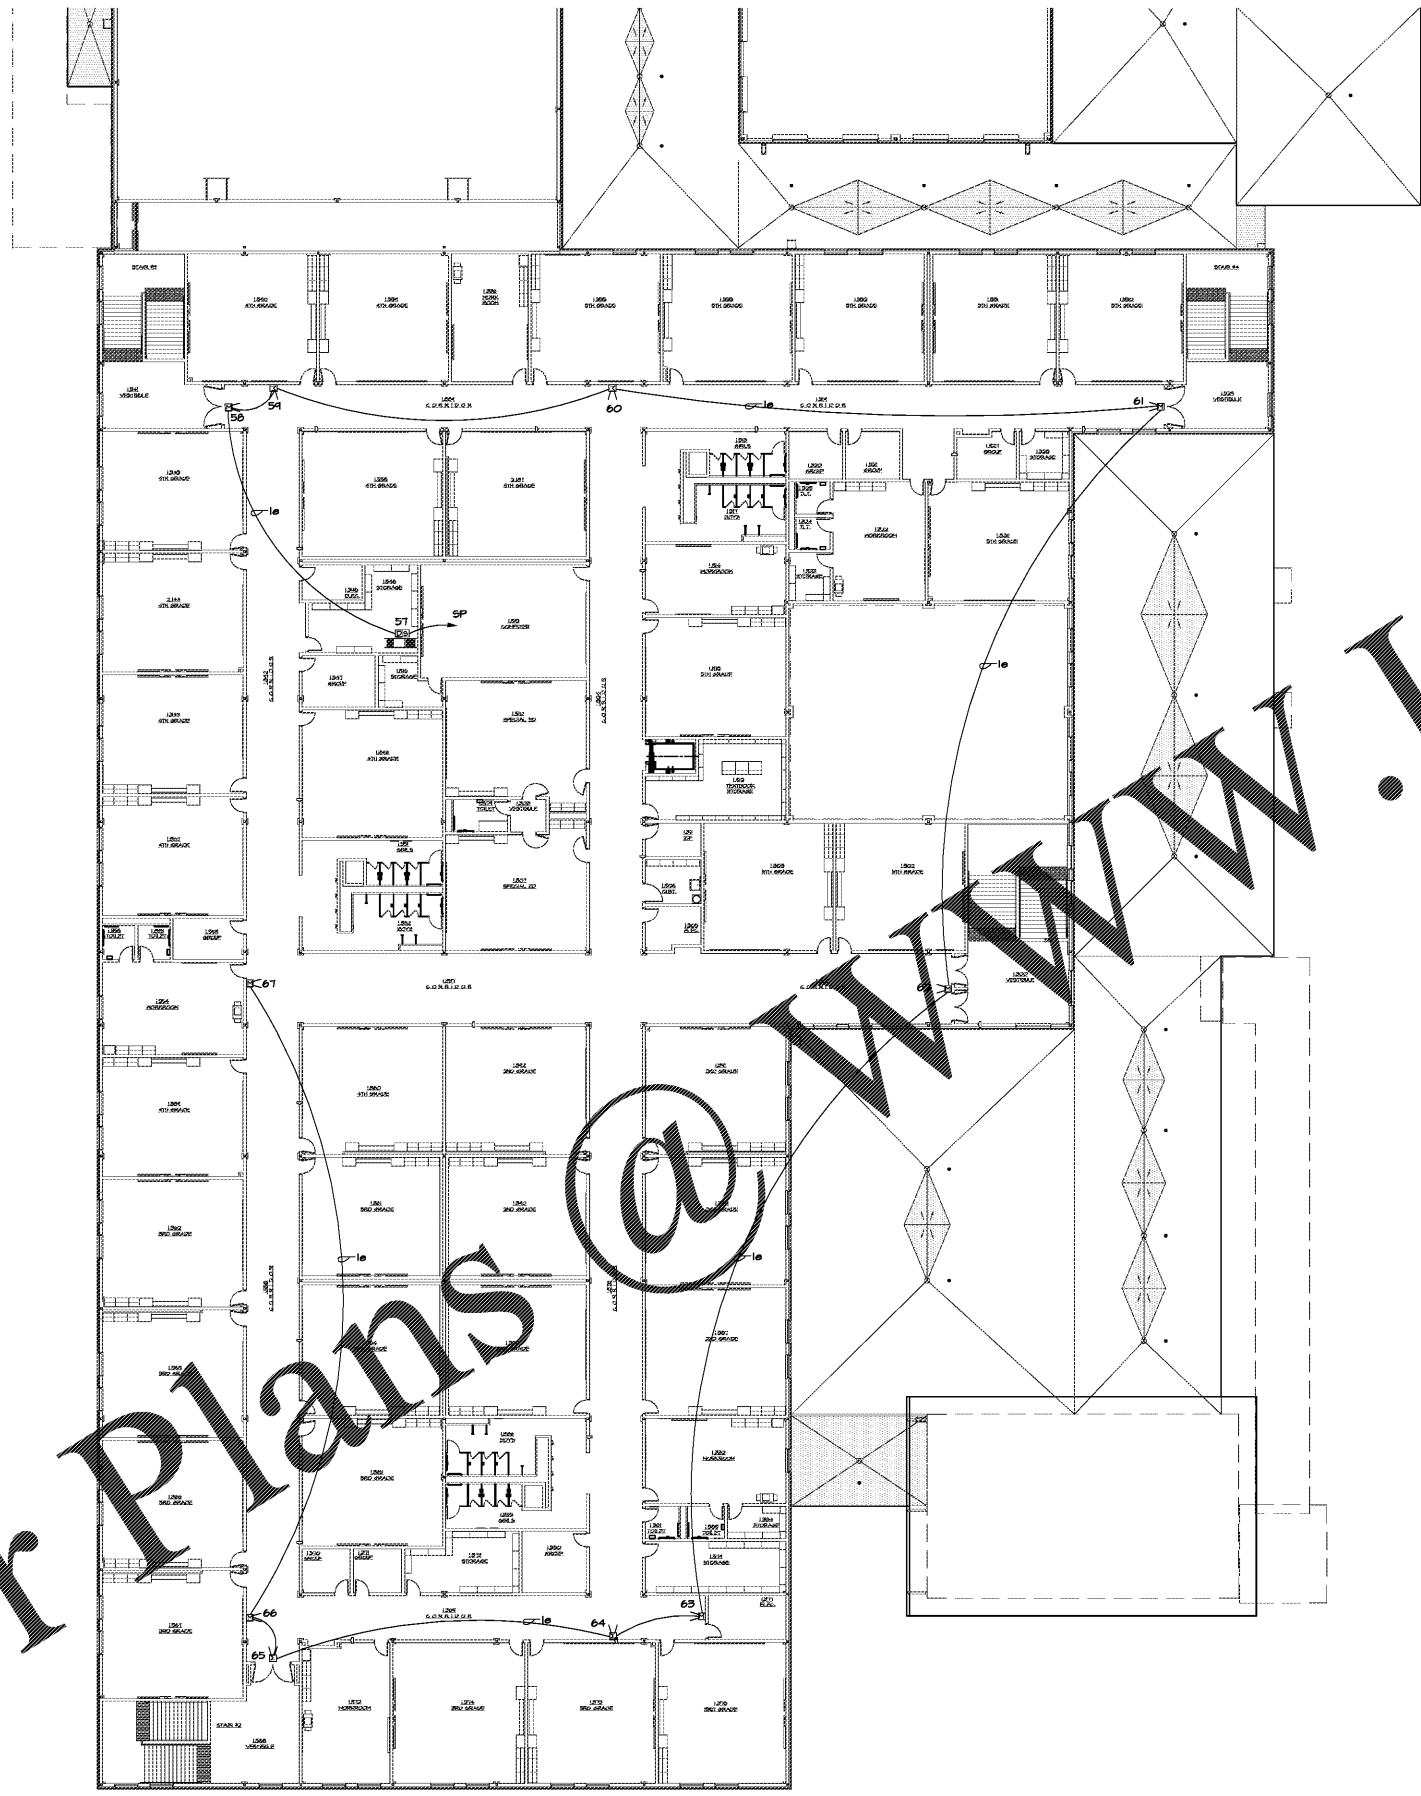

1 UPPER LEVEL FLOOR PLAN - SECURITY
 E5.3 1/16"=1'-0"



SPURLOCK & ASSOCIATES, INC.
 consulting engineers
 2970 Clairmont Rd., Suite 420 | Atlanta, GA 30329
 P: 404.433.0245 | F: 404.433.1736
 JOB NO. 1822

cunningham forehand matthews moore

cunningham, forehand, matthews & moore, architects, inc. - 2011 manchester street, n.e. - atlanta, georgia 30324 - phone (404) 873-2152

HARMONY LELAND-CITY SCHOOL
 REPLACEMENT ELEMENTARY SCHOOL

6526 FACTORY SQUARE RD., NW
 MABLETON, GA 30126
 FOR COBB COUNTY SCHOOL DISTRICT
 COBB COUNTY, GA
 CCSD PROJECT No. ADH / DDE FACILITY CODE

DATE: JULY 16, 2018
 JOB NO. B-L-1007-18
 DWG. BY: G.S.H.
 CHECKED BY: G.L.K.

Order Plans @

WWW.LDILine.com