


GENERAL DEMOLITION NOTES

- A. GENERAL CONTRACTOR SHALL BECOME FAMILIAR WITH THE BUILDING AND SHALL VERIFY ALL ITEMS TO BE REMOVED. THIS DRAWING IS PROVIDED FOR REFERENCE ONLY. IT IS THE GENERAL CONTRACTOR'S RESPONSIBILITY TO VERIFY AND ACHIEVE THE FULL EXTENT OF DEMOLITION REQUIRED FOR NEW CONSTRUCTION AND REMODELING.
- B. GENERAL CONTRACTOR SHALL REMOVE CEILINGS, CEILING ELEMENTS, AND LIGHT FIXTURES AS SHOWN ON PLAN. ANY UNUSED OR NON-FUNCTIONAL CEILING GRID, SUPPORTS, CONDUIT, WIRING, AND/OR MECHANICAL EQUIPMENT SHOULD ALSO BE REMOVED. VERIFY EXISTING SPRINKLER HEADS LOCATIONS AND USE CAUTION DURING CEILING REMOVAL. VERIFY LIMITS OF EXISTING CEILINGS ON SITE.
- C. GENERAL CONTRACTOR SHALL SAVE AND STORE ITEMS INDICATED TO BE REMOVED IN AN ON-SITE TENANT-DESIGNATED LOCATION TO PREVENT DAMAGE.
- D. GENERAL CONTRACTOR SHALL DISPOSE OF ITEMS DESIGNATED HEREIN FOR SALVAGE BY THE OWNER THAT OWNER-IN-FACT DECIDES NOT TO RETAIN.
- E. GENERAL CONTRACTOR SHALL BE RESPONSIBLE FOR EXTENT OF EXISTING MECHANICAL AND ELECTRICAL DEMOLITION WORK AND ALL WORK REQUIRED TO MAINTAIN THE BUILDING'S OPERATION.
- F. GENERAL CONTRACTOR TO FIELD VERIFY ALL QUANTITIES AND MEASUREMENTS PRIOR TO BIDDING.

DEMOLITION KEYNOTE LEGEND

VALUE	KEYNOTE
D1	EXISTING LIGHT FIXTURE TO BE REPLACED. MAINTAIN ALL ELECTRICAL CIRCUITRY (POWER, LOW VOLTAGE, ETC.) FOR CONNECTION TO LIGHT FIXTURE. REUSE EXISTING CONDUIT, JUNCTION BOXES, ETC. WHERE POSSIBLE. REFER TO ELECTRICAL PLAN FOR ADDITIONAL INFORMATION.
D2	EXISTING TRACK LIGHTING TO BE RELOCATED. EXTEND ALL ELECTRICAL CIRCUITS TO NEW LOCATION AS REQUIRED. REUSE EXISTING CONDUIT, JUNCTION BOXES, CONDUIT DROPS, ETC. WHERE POSSIBLE. REFER TO ELECTRICAL PLAN FOR ADDITIONAL INFORMATION.
D3	EXISTING CHANDELIER TO BE DEMOLISHED. REMOVE ALL ASSOCIATED ELECTRICAL DEVICES (CONDUIT, WIRING, ETC.) BACK TO PANEL AND LABEL BREAKER AS SPARE. MAINTAIN OPERATION OF ALL EXISTING ELECTRICAL SYSTEMS AND SUBSYSTEMS TO REMAIN.
D4	EXISTING TRACK LIGHTING TO BE DEMOLISHED. REMOVE ALL ASSOCIATED ELECTRICAL DEVICES (CONDUIT, WIRING, ETC.) BACK TO PANEL AND LABEL BREAKER AS SPARE. MAINTAIN OPERATION OF ALL EXISTING ELECTRICAL SYSTEMS AND SUBSYSTEMS TO REMAIN.
D5	EXISTING LIGHT FIXTURE TO BE MODIFIED. REFER TO ELECTRICAL PLAN FOR ADDITIONAL INFORMATION.
D6	EXISTING WALL SCONCE TO BE DEMOLISHED. REMOVE ALL ASSOCIATED ELECTRICAL DEVICES (CONDUIT, WIRING, ETC.) BACK TO PANEL AND LABEL BREAKER AS SPARE. MAINTAIN OPERATION OF ALL EXISTING ELECTRICAL SYSTEMS AND SUBSYSTEMS TO REMAIN.

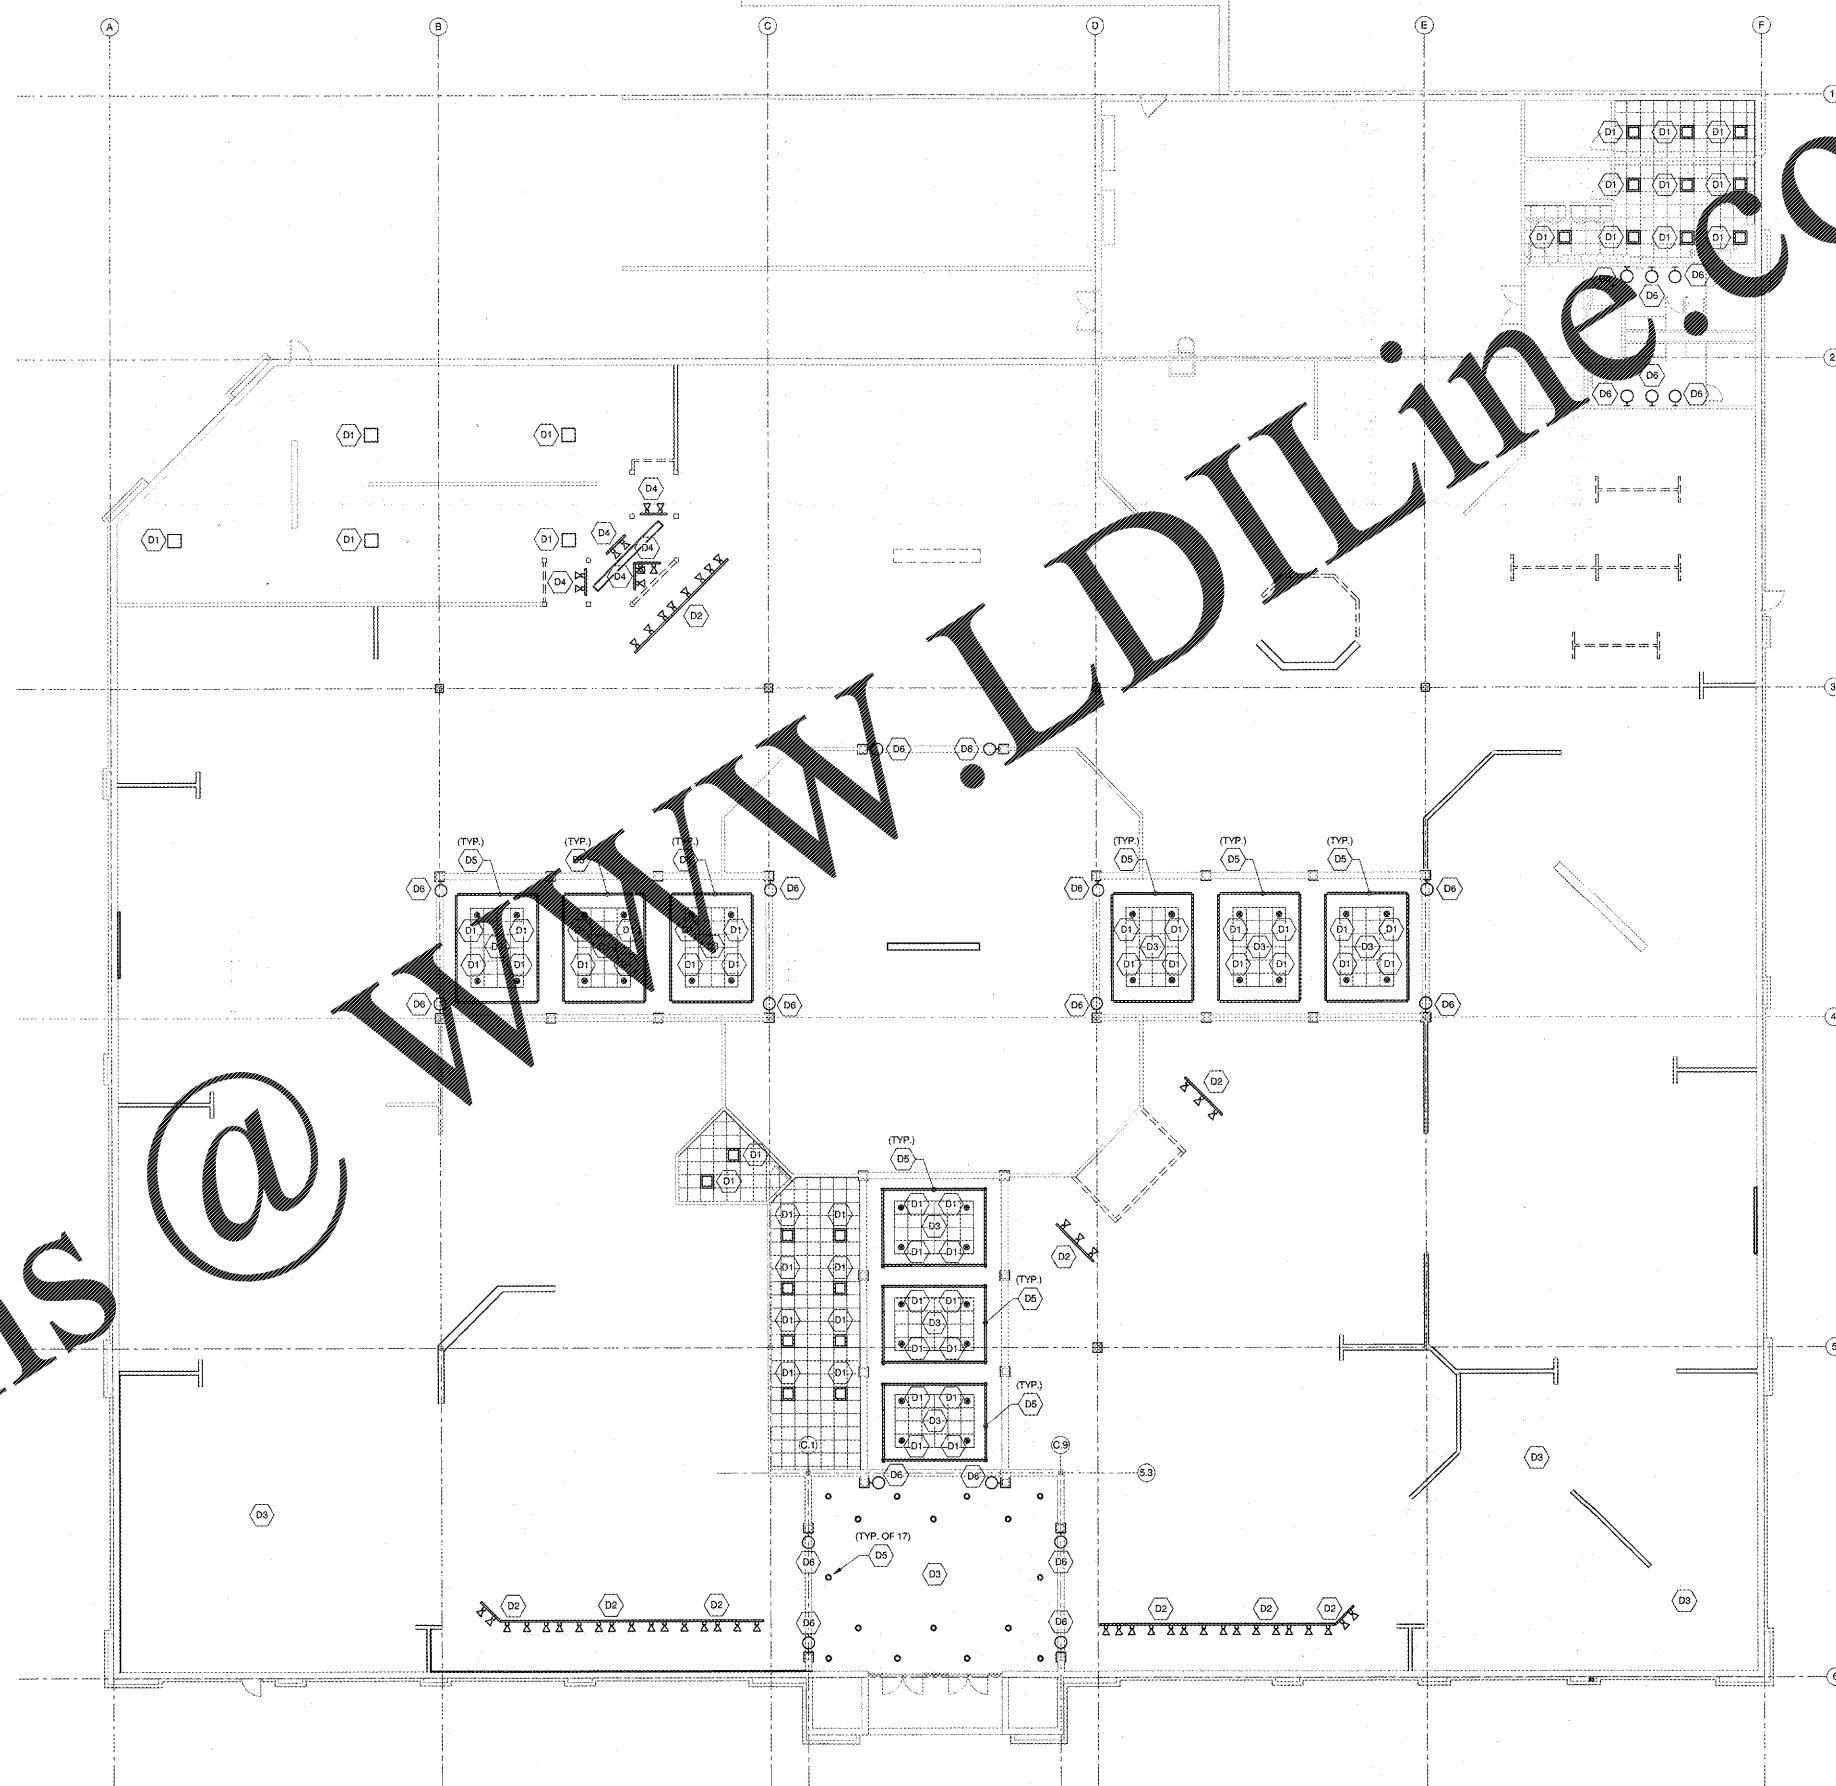

ELECTRICAL DEMOLITION PLAN
3/32" = 1'-0"

Order Plans @ www.LDLine.com

ROBERTSON BOIA ROOF ARCHITECTS ENGINEERS
3600 Preston Ridge
770.641.8887 / www.rbe.com
Smyrna, GA 30085



ASHLEY HOMESTORE
2475 MARKETPLACE BLVD
Cumming, GA 30040
for **ASHLEY HOMESTORE**
One Ashley Way
Arcadia, WI 54612

REVISIONS

SHEET TITLE
ELECTRICAL DEMOLITION PLAN

DATE
10-29-2018

PROJECT NUMBER
18-303

SHEET NUMBER
E-100