


GENERAL LIGHTING NOTES

- A. ELECTRICAL RECEPTACLE C.L. TO BE INSTALLED AT 18" AFF. ALL OUTLETS AND COVERS TO BE WHITE IN COLOR.
- B. CONDUITS ROUTED FROM THE TERMINATION POINTS TO THE ROOF DECK TO BE AT LEAST 3/4" WITH GROMMETS.
- C. COAXIAL AND DATA CABLE BY OTHERS. ALL CONNECTIONS C.L. MOUNTED AT 18" UNLESS NOTED OTHERWISE. ALL COVERS TO BE WHITE IN COLOR.
- D. ALL PHONE, DATA, AND COMMUNICATIONS WIRING SHALL BE ROUTED IN CONDUIT FROM THE COMMUNICATIONS ROOM UP TO THE ROOF DECK AND FROM THE TERMINATION POINT UP TO THE ROOF DECK. IF PHONE, DATA, AND COMMUNICATION WIRING IS REQUIRED, BY CODE, TO BE IN CONDUIT, THEN THE CONTRACTOR SHALL INSTALL CONDUIT FROM TERMINATION POINT TO THE COMMUNICATIONS ROOM.
- E. ALL EXIT AND EMERGENCY LIGHTING FIXTURES ARE EXISTING TO REMAIN. IF ADDITIONAL EMERGENCY AND/OR EXIT LIGHTING IS REQUIRED BY THE MUNICIPALITY, IT IS TO BE SUPPLIED AND INSTALLED BY THE CONTRACTOR. IF LOCATIONS ARE REQUESTED TO BE ADDED, CONTACT THE ASHLEY DESIGNER TO VERIFY NEW LOCATION.
- F. TRACK LIGHTING SYSTEM: TRACK SHALL BE HUNG/MOUNTED TO MATCH EXISTING TRACK HEIGHT UNLESS NOTED OTHERWISE. REUSE ALL MOUNTING HARDWARE FROM REMOVED TRACK SECTIONS.
- G. ALL FIXTURES AND LAMPS TO BE FURNISHED BY OWNER.

POWER KEYNOTE LEGEND

VALUE	KEYNOTE
P1	CONNECT NEW LIGHT FIXTURE TO EXISTING CIRCUIT SERVING DEMOLISHED LIGHT FIXTURE. VERIFY EXISTING CIRCUITS TO BE SUITABLE FOR NEW LIGHT FIXTURES. REUSE EXISTING CONDUIT, COORD DRCP, ETC. WHERE POSSIBLE. CONTRACTOR SHALL VERIFY EXISTING LOCATION IN FIELD. IF NECESSARY, PROVIDE NEW CIRCUIT BREAKER, CONDUITS AND ELECTRICAL EQUIPMENT AS REQUIRED. EXTEND CIRCUIT TO NEW LOCATION AS REQUIRED. MAKE ALL FINAL CONNECTIONS.
P2	EXISTING TRACK LIGHTING TO BE RELOCATED. EXTEND ALL ASSOCIATED ELECTRICAL CIRCUITS TO NEW LOCATION. REUSE EXISTING CONDUIT, JUNCTION BOXES ETC. WHERE POSSIBLE. SEE POWER DEMOLITION PLANS FOR MORE INFORMATION. MAKE ALL FINAL CONNECTIONS. ALL NON-OPERATIONAL FIXTURES AND/OR LAMPS MUST BE REPLACED WITH EQUAL. SUPPLIED BY ASHLEY. INSTALLED BY G.C. REUSE EXISTING SUSPENSION HARDWARE. ANY NEW OR ADDITIONAL SUSPENSION HARDWARE TO BE SUPPLIED BY ASHLEY.
P3	CONNECT DRUM SHADE PENDANT TO A 120V 20A TWIST LOCK RECEPTACLE MOUNTED AT EITHER ROOF DECK OR STRUCTURE.
P4	MOUNT BOTTOM OF PENDANT AT THE HEIGHT SPECIFIED.
P5	CONNECT NEW RECEPTACLE TO EXISTING RECEPTACLE CIRCUIT SERVING THIS AREA FROM PANEL. LFP, LPA, OR LPS. CONTRACTOR TO VERIFY THAT CIRCUIT WILL NOT BE OVERLOADED BY ADDITION OF NEW FIXTURE(S). PROVIDE NEW CIRCUIT FROM THE SAME PANEL IF REQUIRED. MAKE ALL FINAL CONNECTIONS.
P6	CIRCUIT FOR RECEPTACLE TO NOT BE SWITCHED. OUTLETS TO BE RECESSED AND WHITE IN COLOR.
P7	TV COAX RECEPTACLE MOUNTED 8'-0" AFF. RECEPTACLE TO BE RECESSED AND WHITE IN COLOR. MOUNT AND TV SUPPLIED BY ASHLEY AND INSTALLED BY CONTRACTOR.
P8	MOUNT JUNCTION BOX FOR PENDANT AT 11'-0" AFF.
P9	CONNECT TRACK TO SAME SECTION IT WAS PREVIOUSLY ATTACHED TO AT ROTATED 45 DEGREES FROM EXISTING LOCATION. NEW LOCATION IS PARALLEL TO EXISTING SECTION.
P10	CONNECT NEW RECEPTACLE TO EXISTING UNSWITCHED RECEPTACLE CIRCUIT SERVING THIS AREA FROM PANEL. LFP, LPA, OR LPS. CONTRACTOR TO VERIFY THAT CIRCUIT WILL NOT BE OVERLOADED BY ADDITION OF NEW FIXTURE(S). PROVIDE NEW CIRCUIT FROM THE SAME PANEL IF REQUIRED. MAKE ALL FINAL CONNECTIONS.
P11	REMOVE ALL DOWNLIGHT FIXTURE BALLAST AND REPLACED WITH A DIRECT WIRE SOCKET AND LED LAMP. SOCKET BE SUPPLIED BY ELECTRICIAN. ALL LAMPS FOR NEW SOCKET TO BE LED GREEN CREATIVE 58235 16.5A21840277V LAMPS SUPPLIED BY ASHLEY.
P12	ALL NON-OPERATIONAL FIXTURES AND/OR BALLASTS MUST BE REPLACED WITH EQUAL. ALL BALLASTS SUPPLIED AND INSTALLED BY CONTRACTOR. SUPPLIED BY ASHLEY. INSTALLED BY ELECTRICIAN. ALL LAMPS TO BE REPLACED WITH LED TUBE LAMPS SUPPLIED BY ASHLEY.
P13	REPLACE ALL COVE LIGHTING LAMPS WITH LED TUBE LAMPS SUPPLIED BY ASHLEY. ALL NON-OPERATIONAL FIXTURES AND/OR BALLASTS MUST BE REPLACED WITH EQUAL. ALL BALLASTS SUPPLIED AND INSTALLED BY CONTRACTOR. SUPPLIED BY ASHLEY. INSTALLED BY ELECTRICIAN.

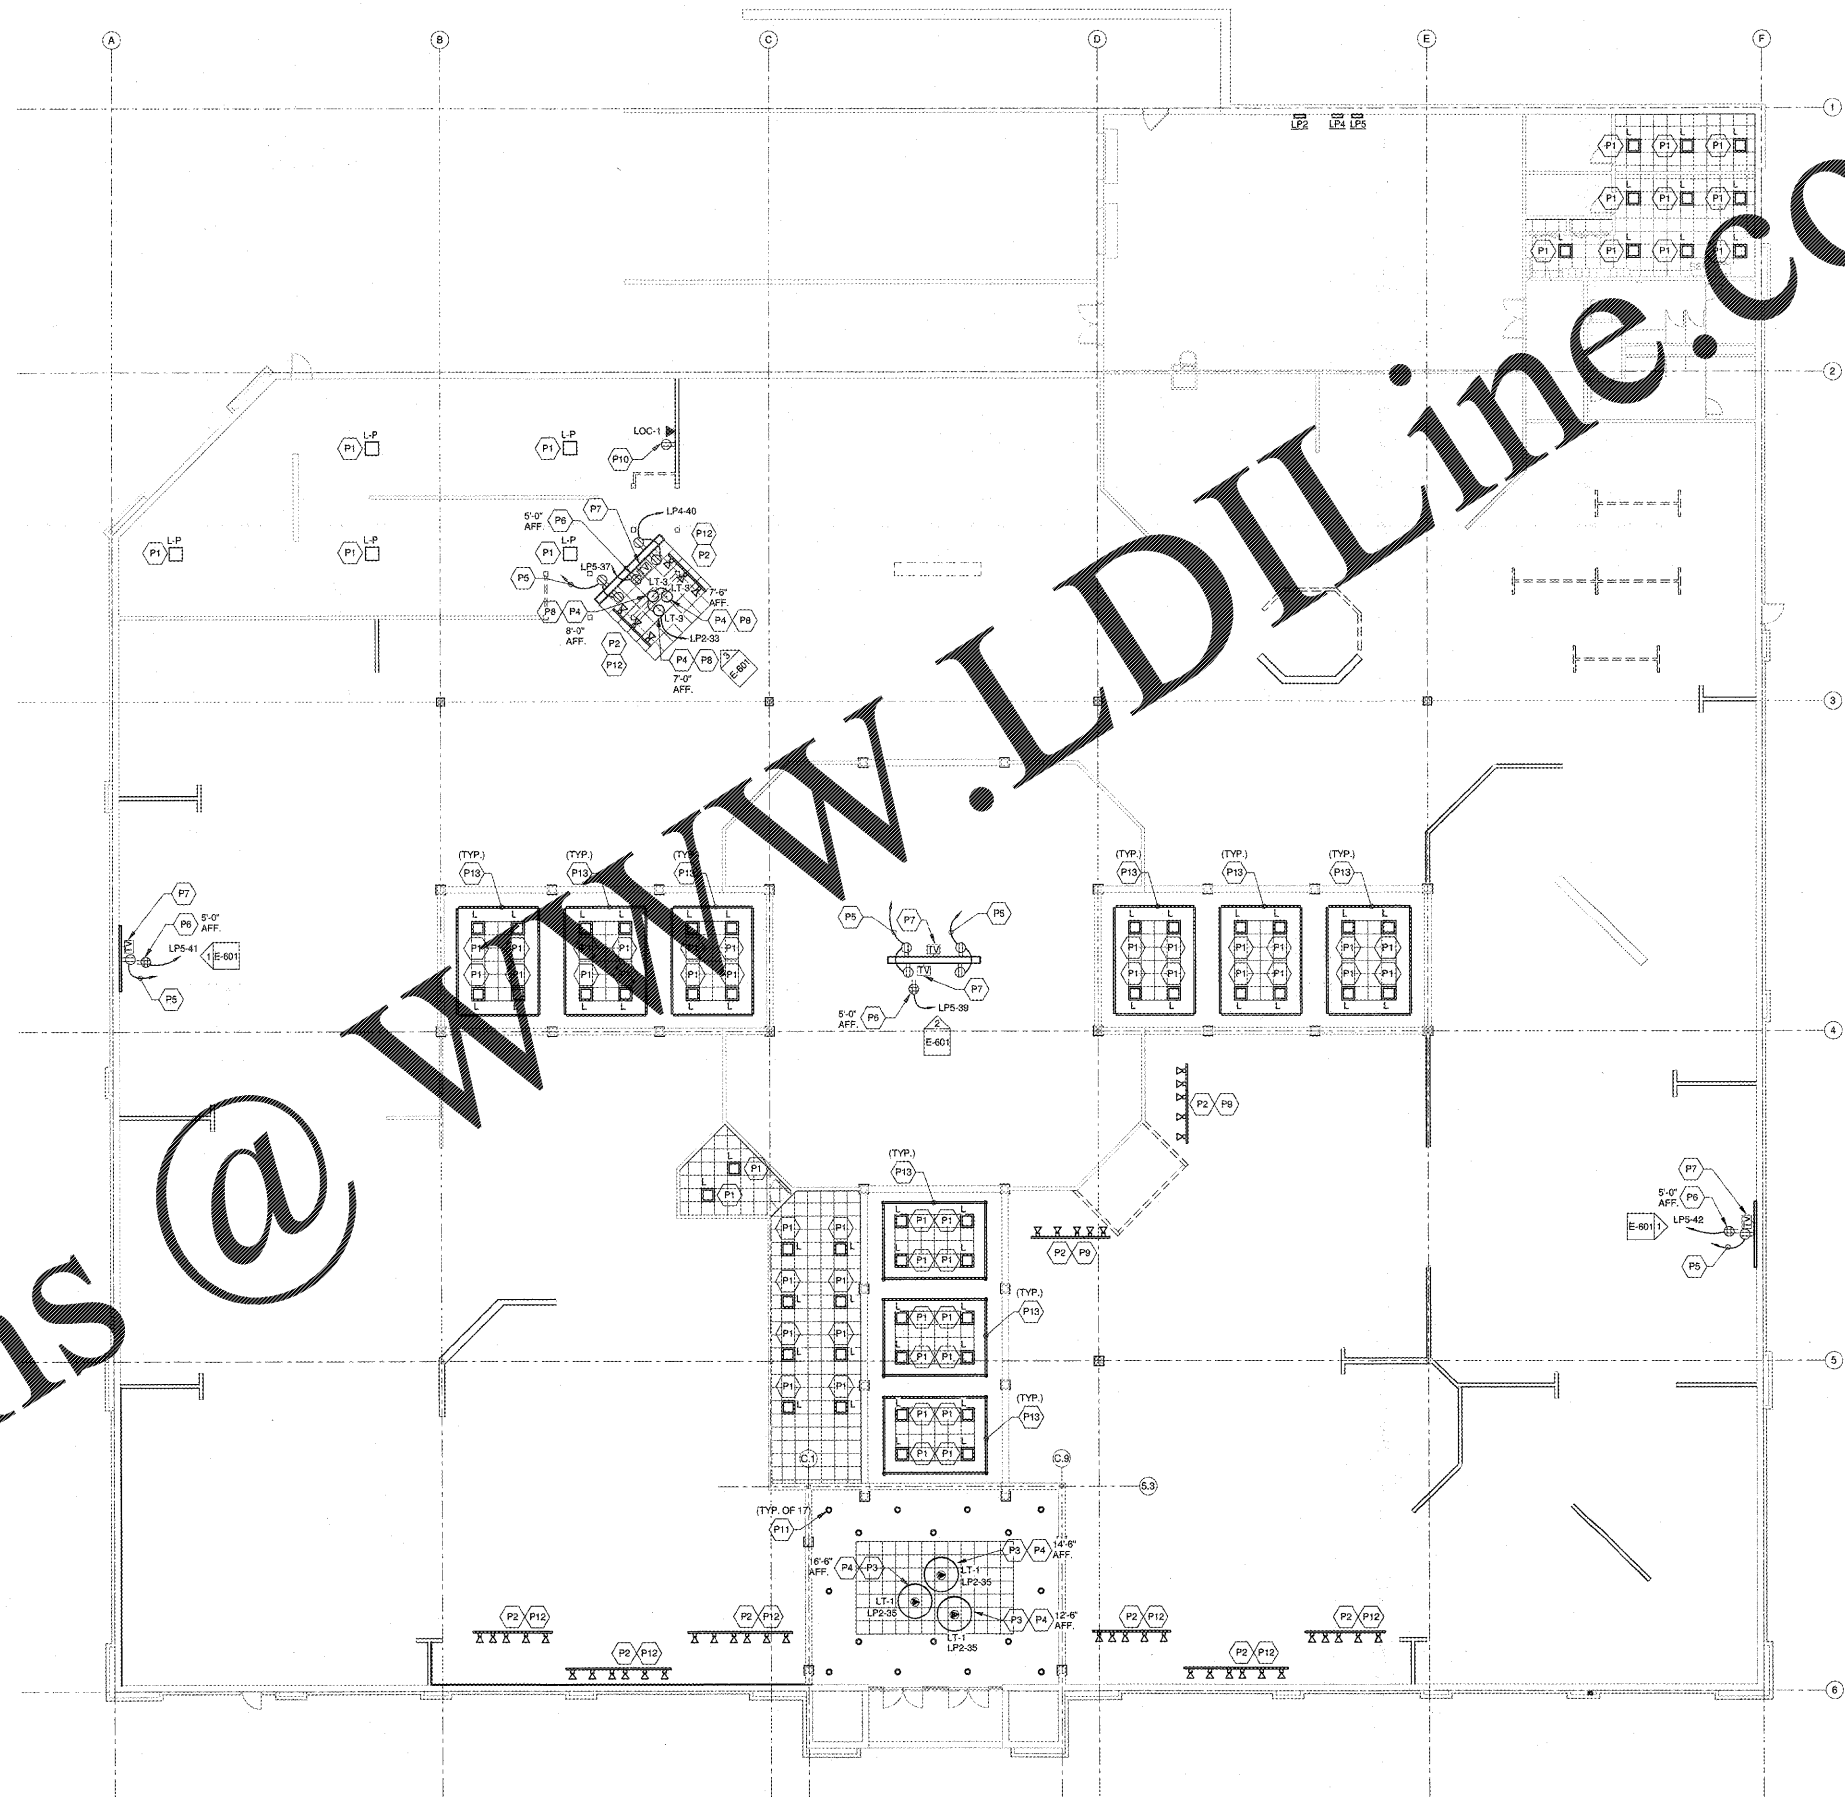

ELECTRICAL PLAN
3/32" = 1'-0"

Order Plans @ www.LDLine.com

ROBERTSON BOIA ROOF ARCHITECTS ENGINEERS
3440 Peachtree Ridge Road, Atlanta, GA 30305
770.674.2600 / www.rboia.com



ASHLEY HOMESTORE
2475 MARKETPLACE BLVD
Cumming, GA 30040
FOR **ASHLEY HOMESTORE**
Arcadia, WI 54612
One Ashley Way

REVISIONS

SHEET TITLE: **ELECTRICAL PLAN**
DATE: **10-29-2018**
PROJECT NUMBER: **18-303**
SHEET NUMBER: **E-101**