



DRAWING ISSUE RECORD		
DATE	REVISIONS	NO.
10/30/18	BID SET	


EXISTING GAS METER LOAD
 HEATING - 2,484 CFH
 TOTAL - 2,484 CFH
 DELIVERY PRESSURE = 5 PSI
 NEW GAS METER LOAD
 HEATING - 2,117 CFH
 TOTAL - 2,117 CFH
 DELIVERY PRESSURE = 5 PSI

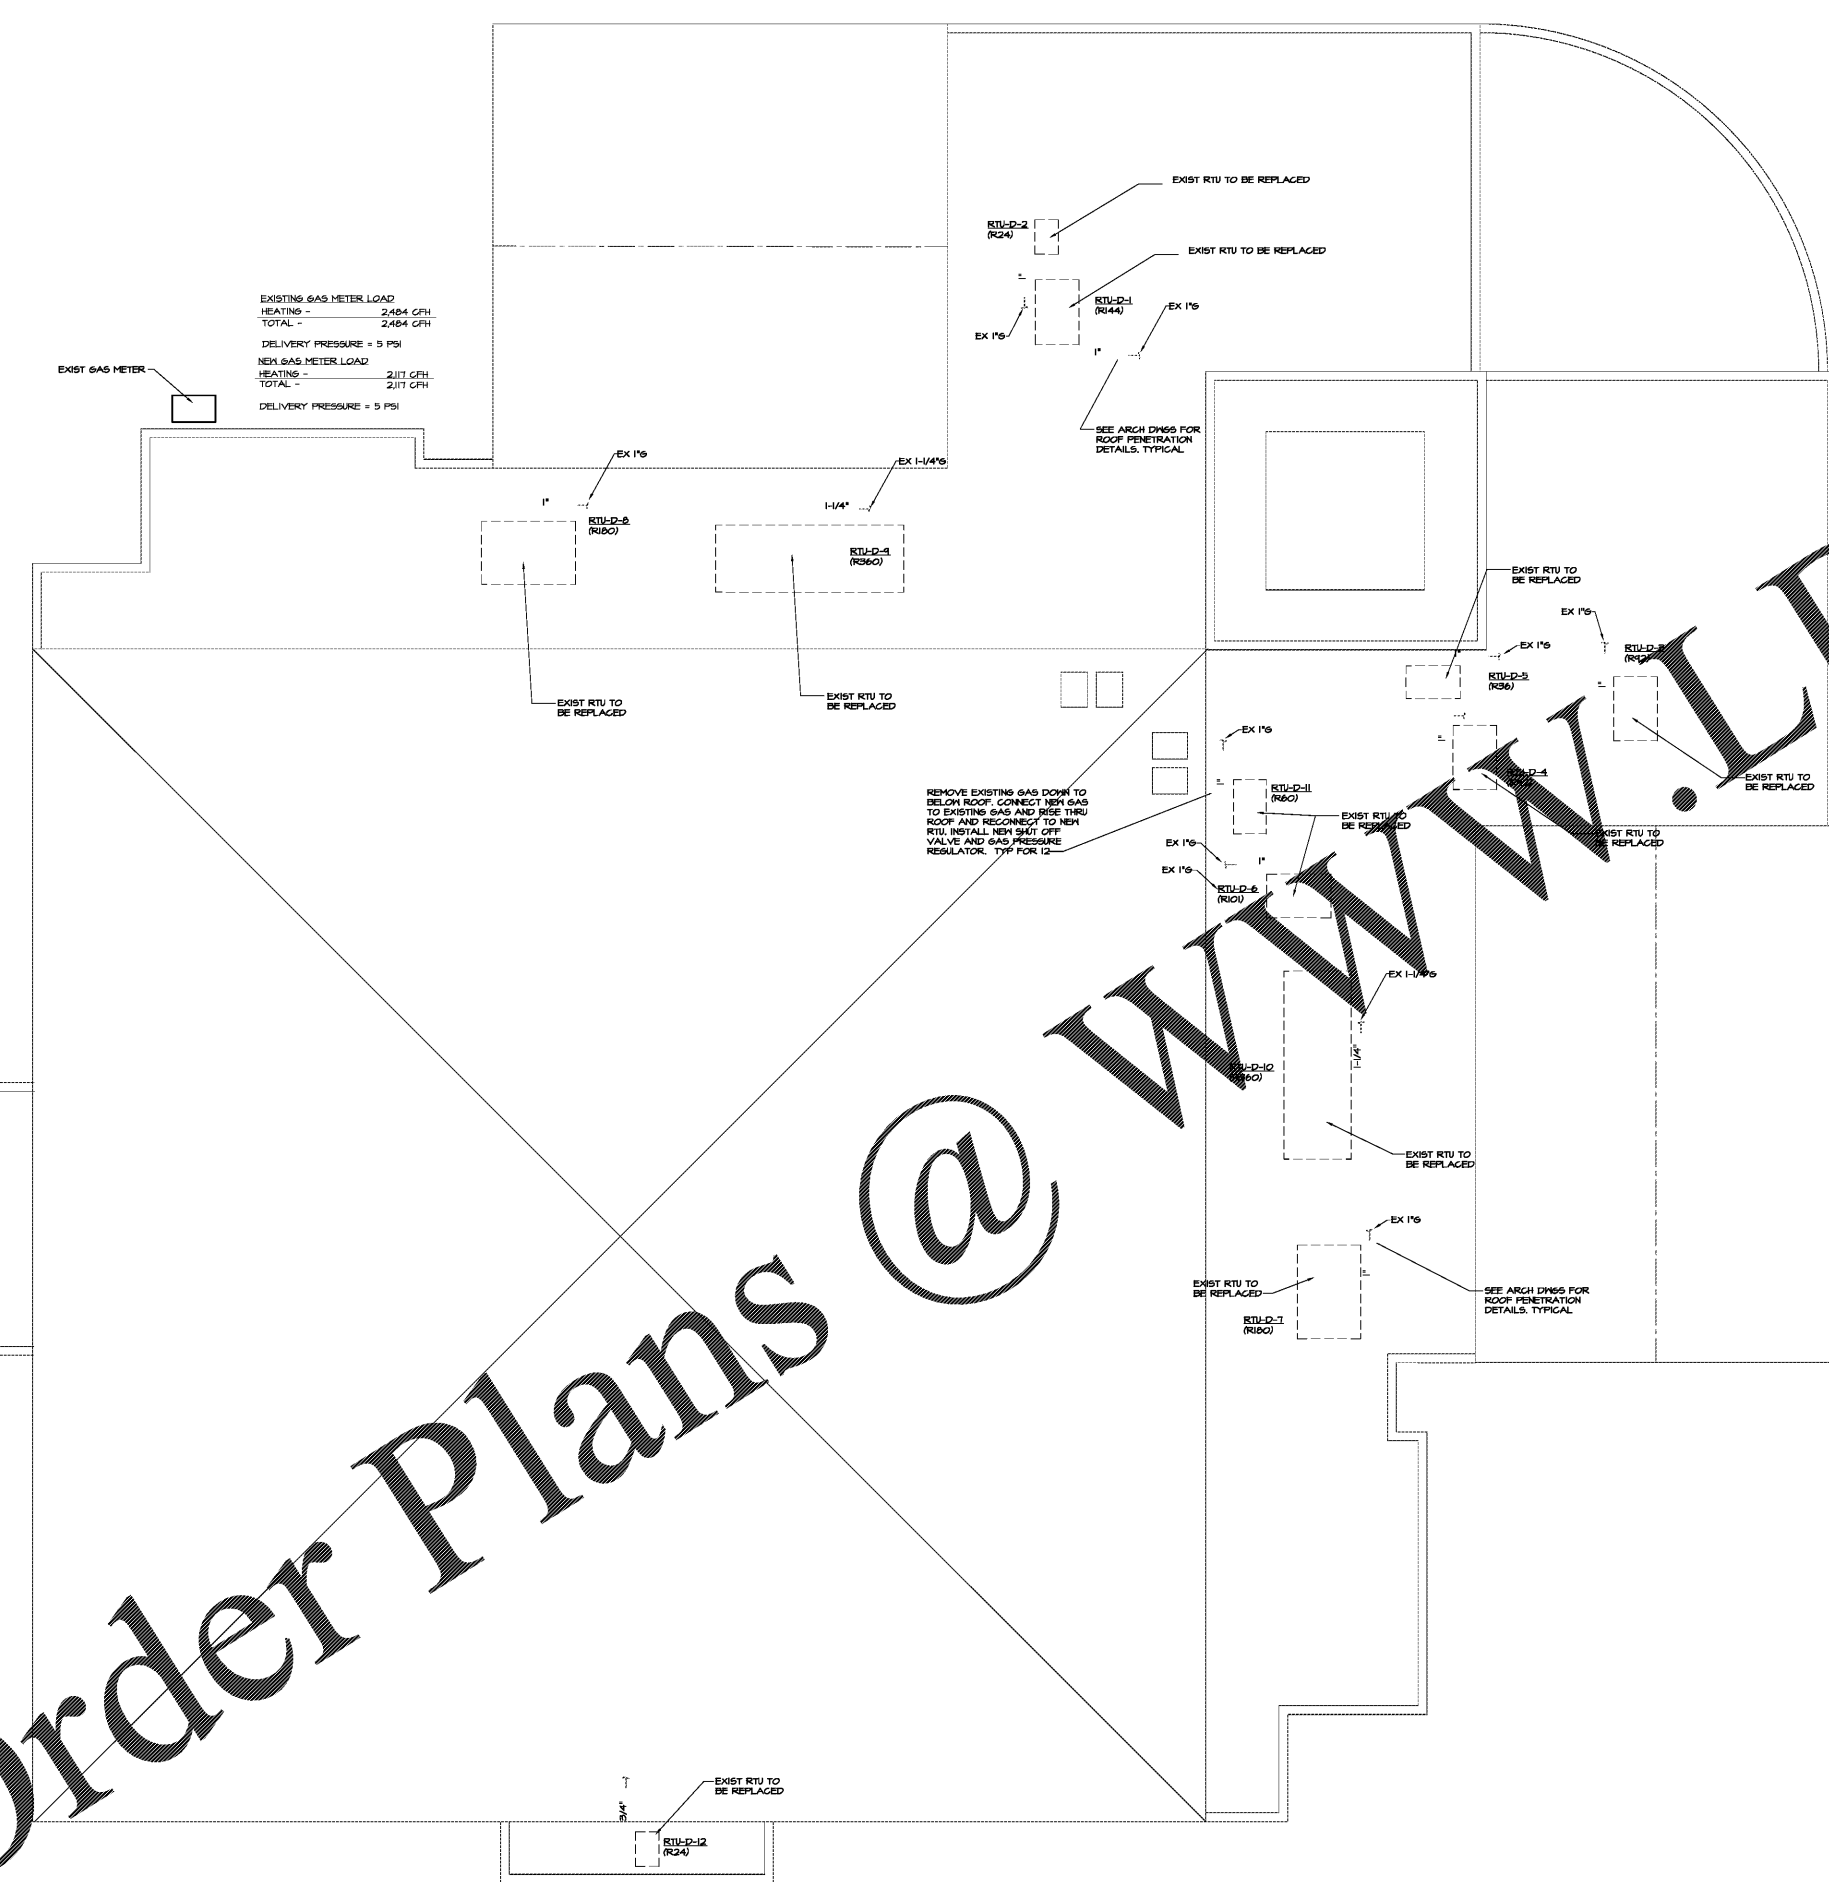

REMOVE EXISTING GAS DOWN TO BELOW ROOF. CONNECT NEW GAS TO EXISTING GAS AND RISE THRU ROOF AND RECONNECT TO NEW RTU. INSTALL NEW SHUT OFF VALVE AND GAS PRESSURE REGULATOR. TYP FOR 12"

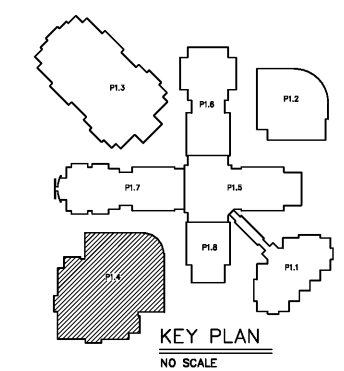

1 PARTIAL FLOOR PLAN - PLUMBING
 P1.4 1/8"=1'-0"

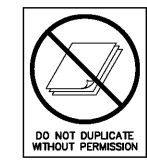

SPURLOCK & ASSOCIATES, INC.
 consulting engineers
 2970 Clairmont Rd., Suite 620 | Atlanta, GA 30329
 P: 404.633.0245 | F: 404.633.1756
 JOB NO. 1809

HVAC REPLACEMENT FOR NORTH OCONEE HIGH SCHOOL
 EG: 108-0101 FOR THE OCONEE COUNTY BOARD OF EDUCATION
 WATKINSVILLE, GEORGIA
 DATE: SEPT 14, 2018
 JOB NO: 18-1-108-18
 DWG. BY: JCF
 P.L.D.

cunningham forehand matthews moore

cunningham, forehand, matthews & moore, architects, inc. - 2011 manchester street, n.e. - atlanta, georgia 30324 - phone (404) 873-2152

P1.4

Order Plans @ WWW.LDILine.com