



DRAWING ISSUE RECORD		
DATE	REVISIONS	NO.
10/30/18	BID SET	

HVAC REPLACEMENT FOR
 NORTH OCOFEE HIGH SCHOOL
 EG: 108-0101
 FOR THE
 OCOFEE COUNTY BOARD OF EDUCATION
 WATKINSVILLE, GEORGIA
 DATE: SEPT 14, 2018
 JOB NO. 8-L-108-18
 DESIGNED BY: JCF
 DRAWN BY: JCF

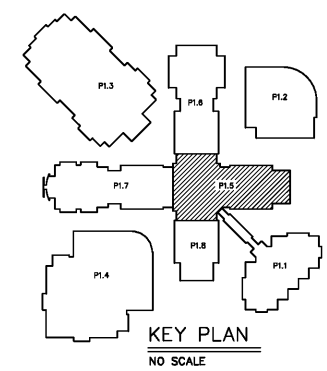

1 PARTIAL FLOOR PLAN - PLUMBING
 P1.5 1/8"=1'-0"

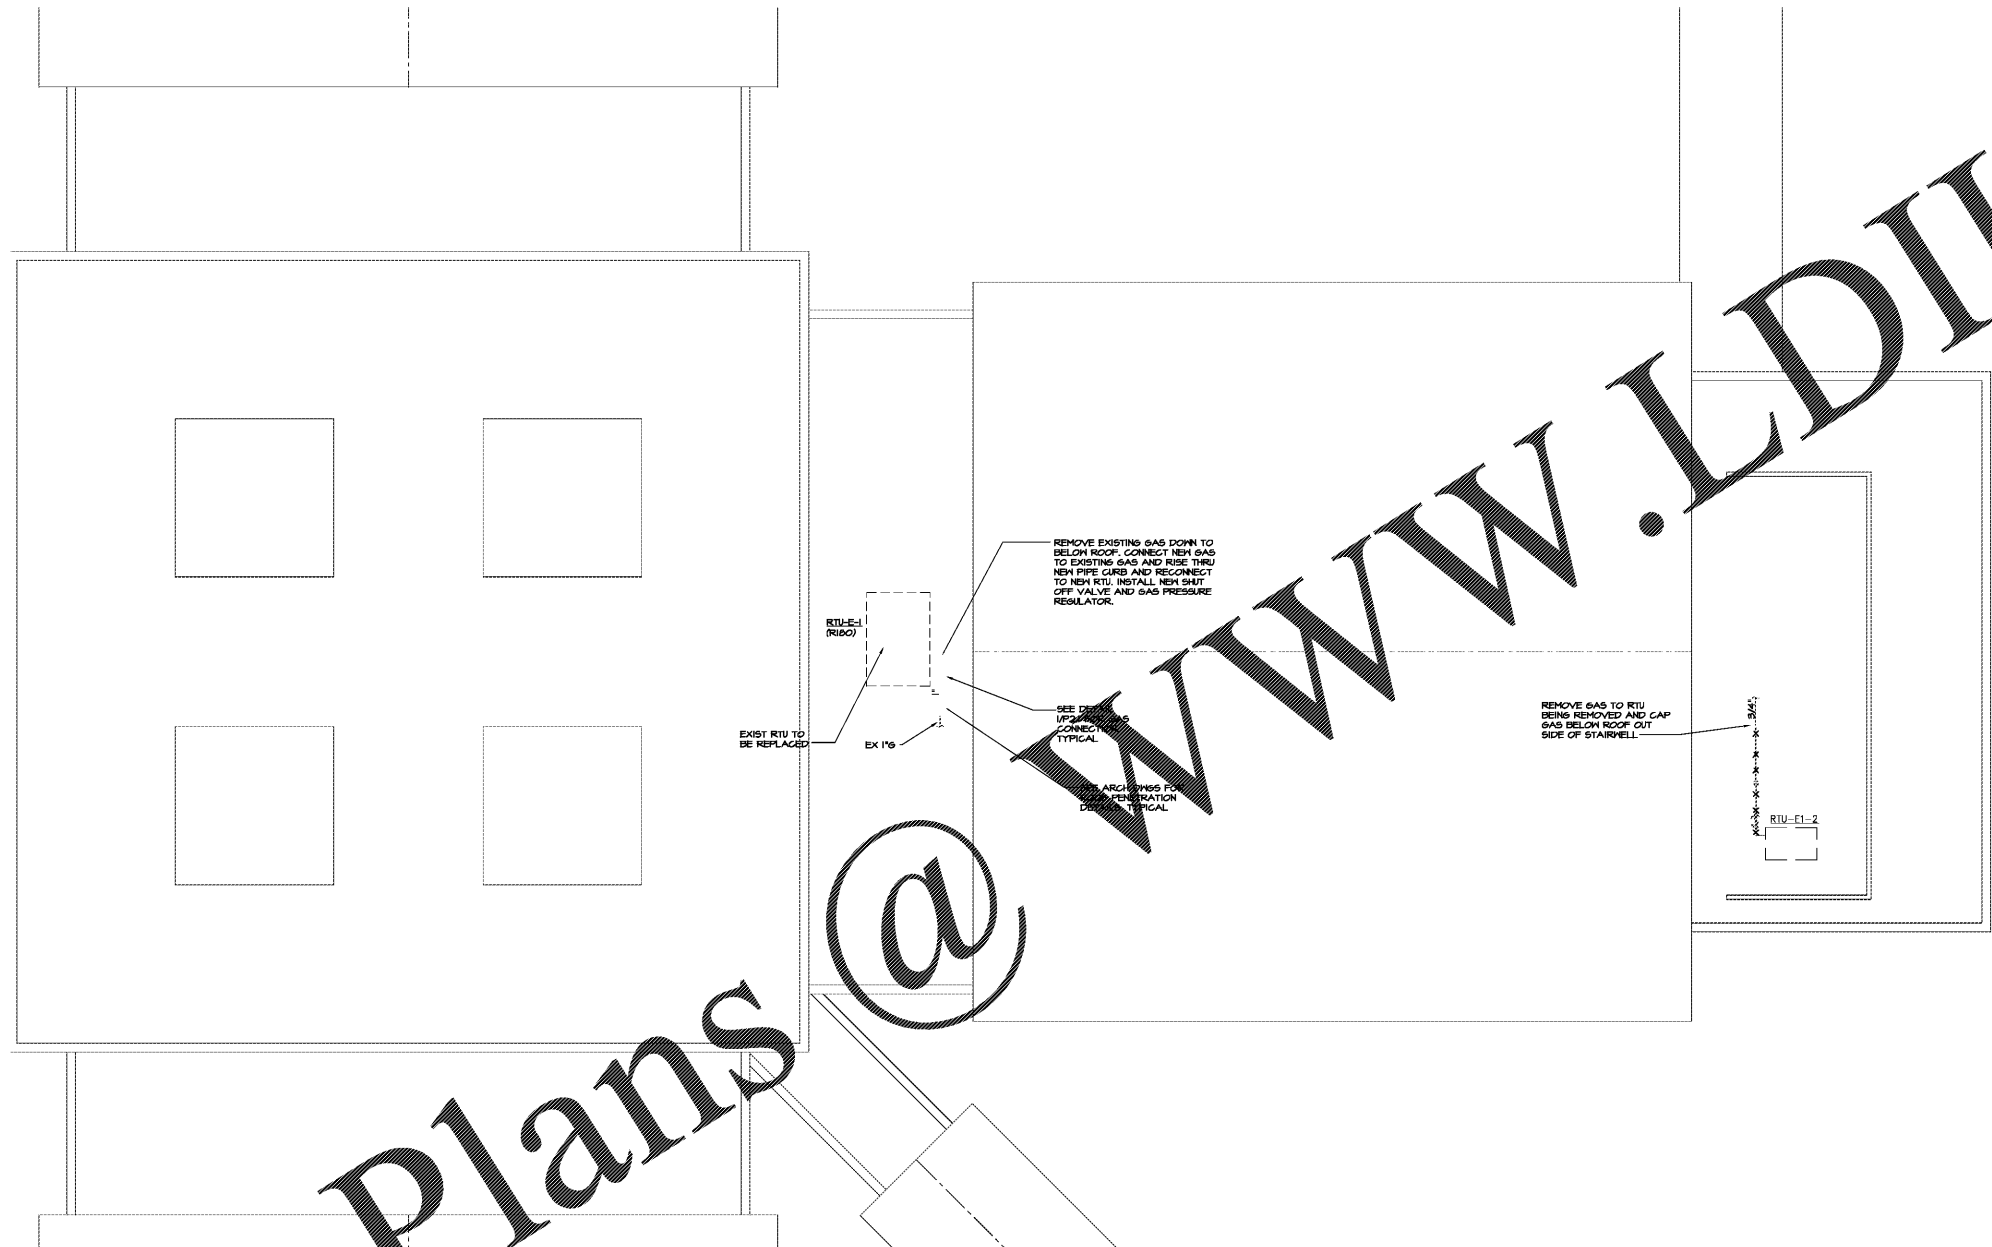

SPURLOCK & ASSOCIATES, INC.
 consulting engineers
 2970 Clairmont Rd., Suite 620 | Atlanta, GA 30329
 P: 404.633.0245 | F: 404.633.1756
 JOB NO. 1809

cunningham forehand matthews moore

cunningham, forehand, matthews & moore, architects, inc. - 2011 manchester street, n.e. - atlanta, georgia 30324 - phone (404) 873-2152

Order Plans @

www.LDILine.com