



DRAWING ISSUE RECORD		
DATE	REVISIONS	NO.
10/30/18	BID SET	

HVAC REPLACEMENT FOR
 NORTH OCONEE HIGH SCHOOL
 EG: 108-010-01
 FOR THE
 OCONEE COUNTY BOARD OF EDUCATION
 WATKINSVILLE, GEORGIA

DATE: SEPT 14, 2018
 JOB NO.: 8-LL-108-18
 DRAWN BY: JCF
 CHECKED BY: MILD

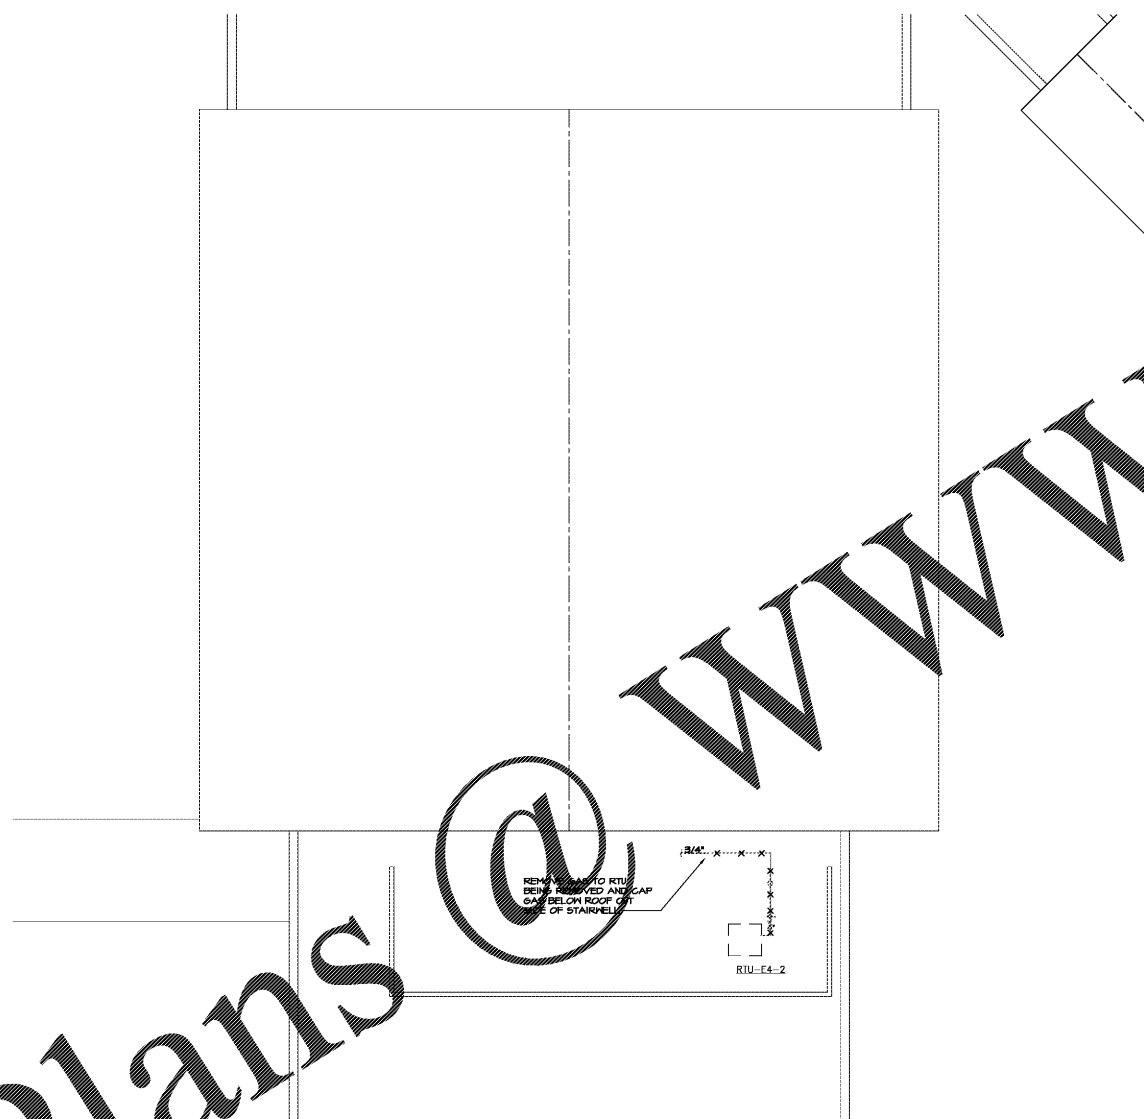

1 PARTIAL FLOOR PLAN - PLUMBING
 Pl.8 1/8"=1'-0"

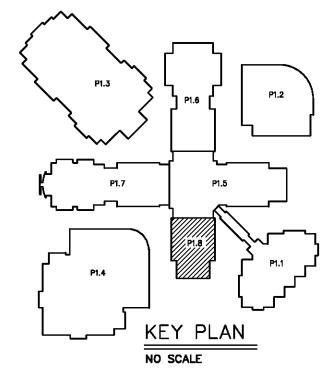

KEY PLAN
 NO SCALE



DO NOT DUPLICATE WITHOUT PERMISSION




SPURLOCK & ASSOCIATES, INC.
 consulting engineers
 2970 Clairmont Rd., Suite 620 | Atlanta, GA 30329
 P: 404.633.0245 | F: 404.633.1756
 JOB NO. 1889

cunningham forehand matthews moore

cunningham, forehand, matthews & moore, architects, inc. - 2011 manchester street, n.e. - atlanta, georgia 30324 - phone (404) 873-2152

P1.8

Order Plans

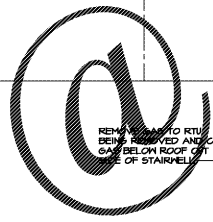

www.LDILine.com