
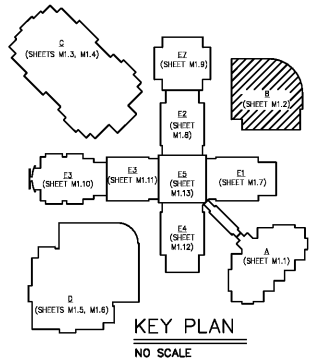


DRAWING ISSUE RECORD		
DATE:	REVISIONS:	NO.
10/30/18	BID SET	

HVAC REPLACEMENT FOR
NORTH OCOREE HIGH SCHOOL
EC-108-0105
FOR THE
OCOREE COUNTY BOARD OF EDUCATION
WATKINSVILLE, GEORGIA

DATE: SEPT 14, 2018
BY: M.J.D.


cunningham forehand matthews moore
cunningham, forehand, matthews & moore, architects, inc. - 2011 manchester street, n.e. - atlanta, georgia 30324 - phone (404) 873-2152

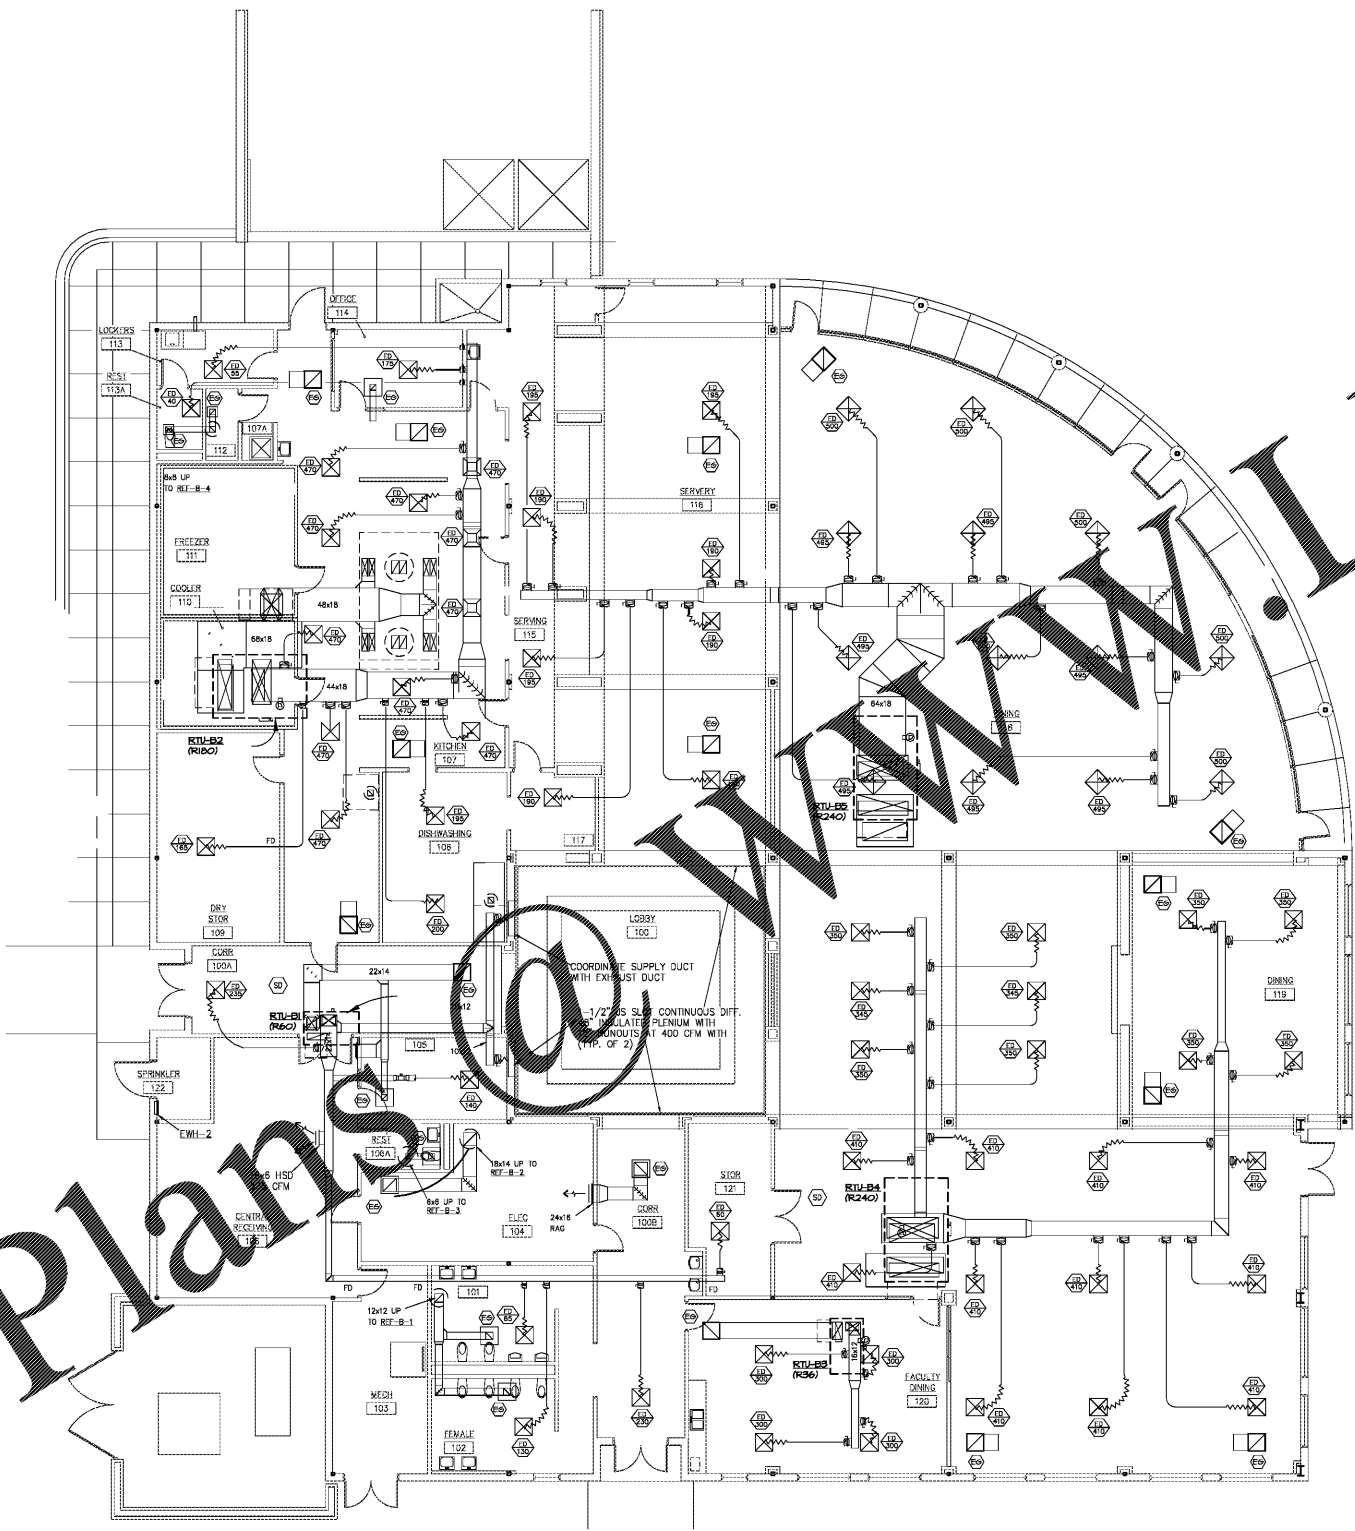

KEY PLAN
NO SCALE

Order Plans@www.LDILine.com

1 PARTIAL FLOOR PLAN - BLDG B - HVAC
M1.2 1/8"=1'-0"

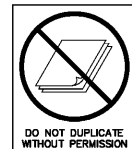

DO NOT DUPLICATE WITHOUT PERMISSION



SPURLOCK & ASSOCIATES, INC.
consulting engineers
2970 Clairmont Rd., Suite 620 | Atlanta, GA 30339
P: 404.633.0245 | F: 404.633.1756
JOB NO. 1805

M1.2