



DRAWING ISSUE RECORD		
DATE:	REVISIONS:	NO.
10/30/18	BID SET	

HVAC REPLACEMENT FOR
NORTH OCOONEE HIGH SCHOOL
FC, 108-0105
FOR THE
OCOONEE COUNTY BOARD OF EDUCATION
WATKINSVILLE, GEORGIA

DATE: SEPT 14, 2018
BY: M.L.D.

cunningham forehand matthews moore

cunningham, forehand, matthews & moore, architects, inc. - 2011 manchester street, n.e. - atlanta, georgia 30324 - phone (404) 873-2152

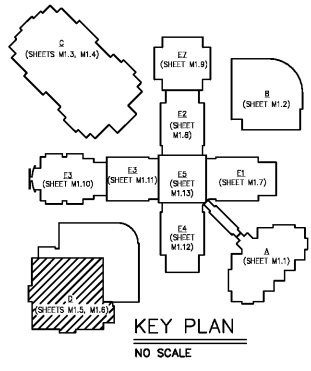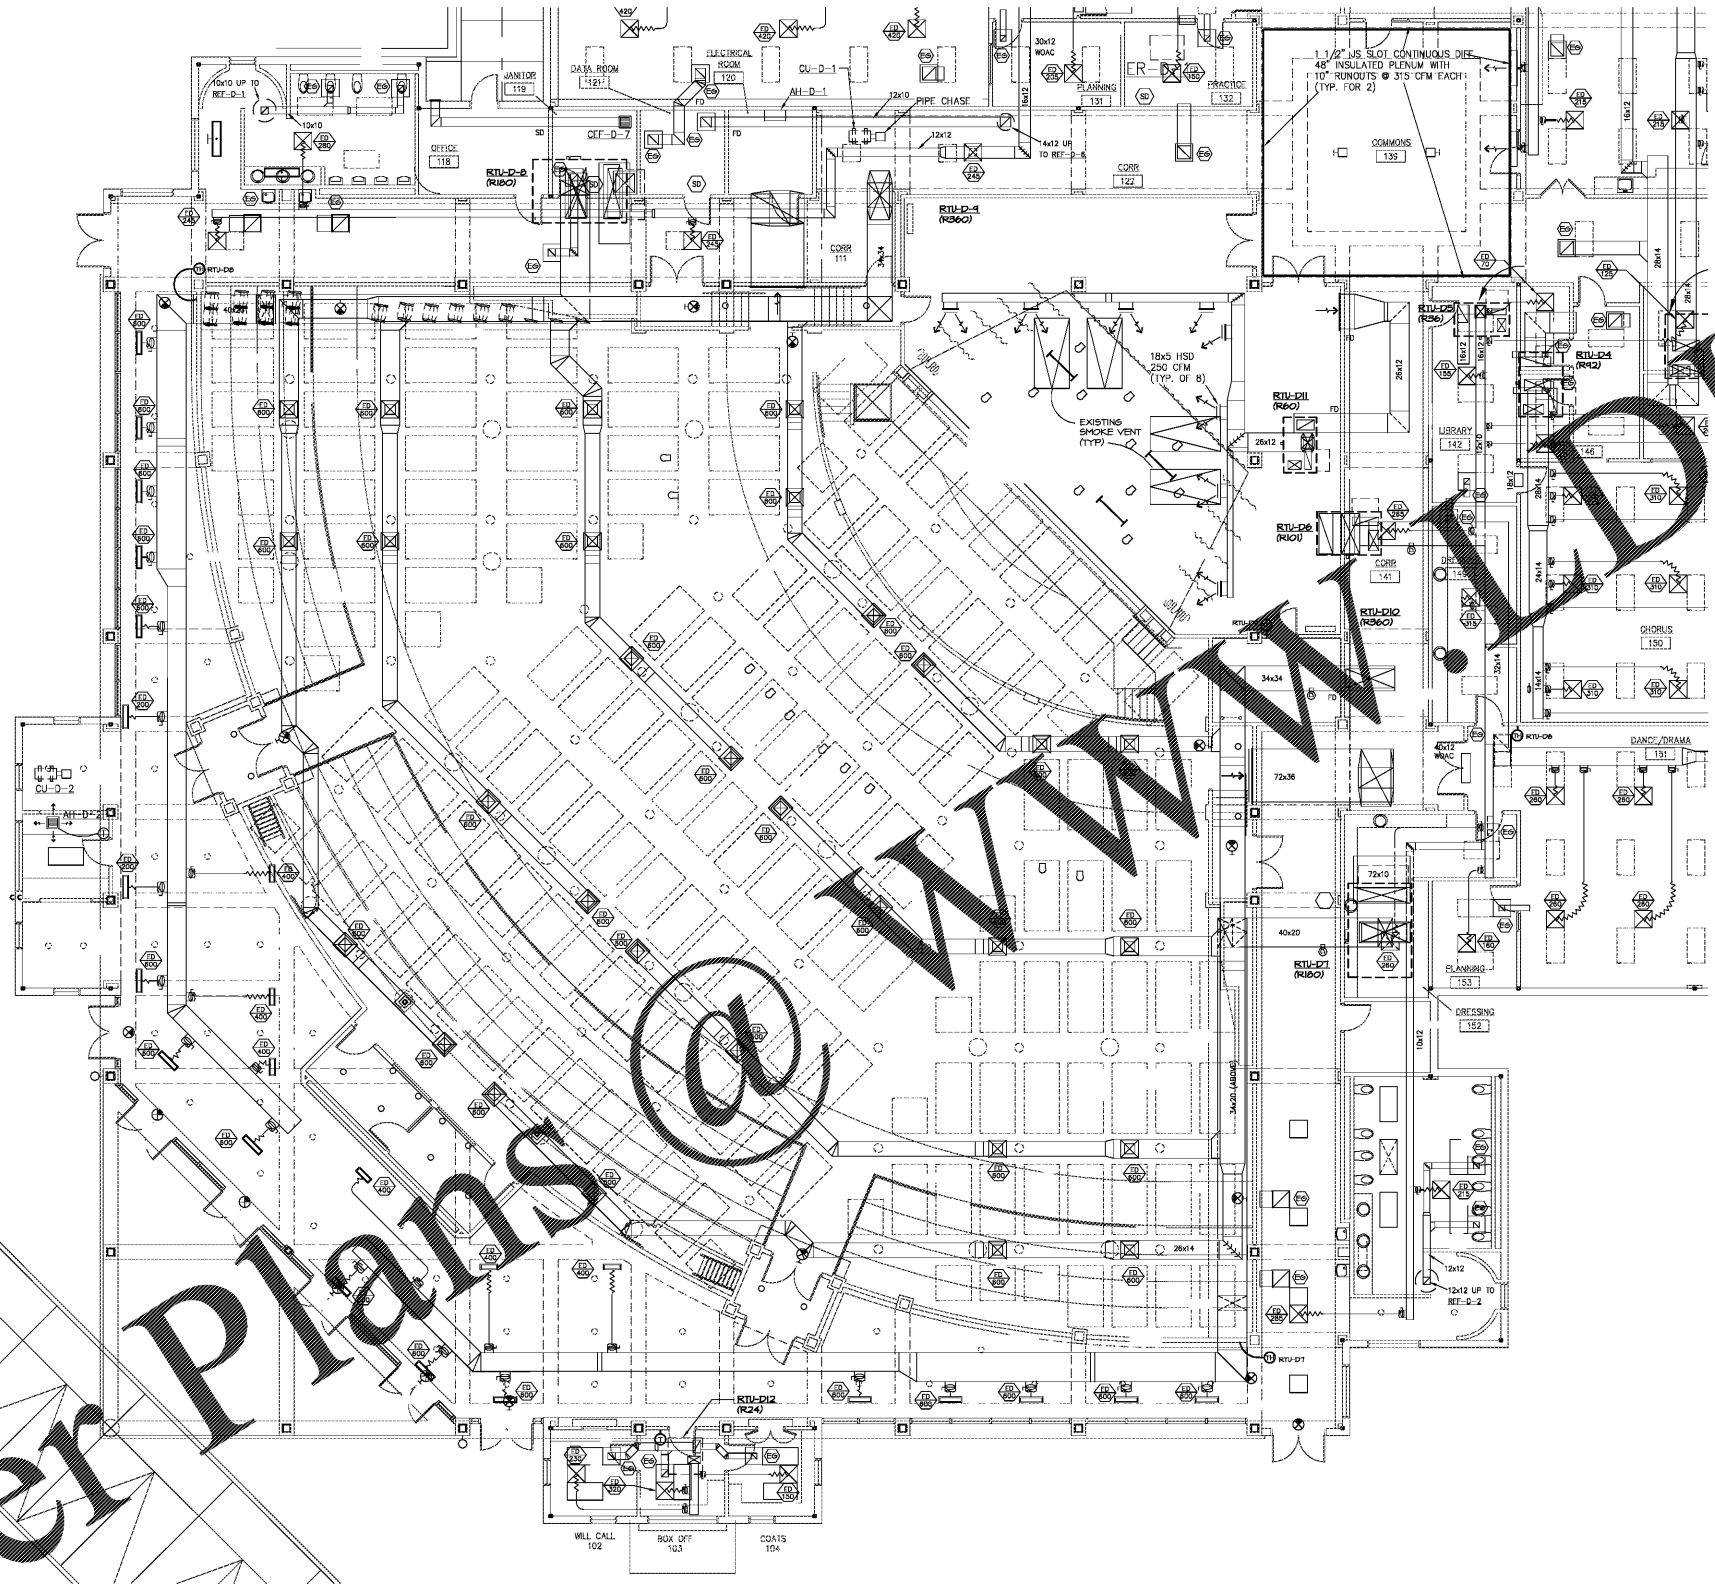

KEY PLAN
NO SCALE

1 PARTIAL FLOOR PLAN - BLDG D - HVAC
M1.6 1/8"=1'-0"

Order Plans @ www.dlLine.com



M1.6