
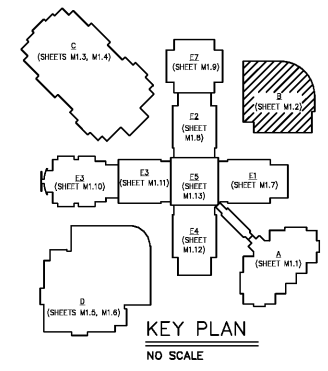


DRAWING ISSUE RECORD		
DATE	REVISIONS	NO.
10/30/18	BID SET	

HYAC REPLACEMENT FOR  
 NORTH OCONEE HIGH SCHOOL  
 EG: 108-010-010  
 FOR THE  
 OCONEE COUNTY BOARD OF EDUCATION  
 WATKINSVILLE, GEORGIA

DATE: SEPT 4, 2018  
 JOB NO: 18-11-008-18  
 DWG. BY: G.T.R. G.L.K.

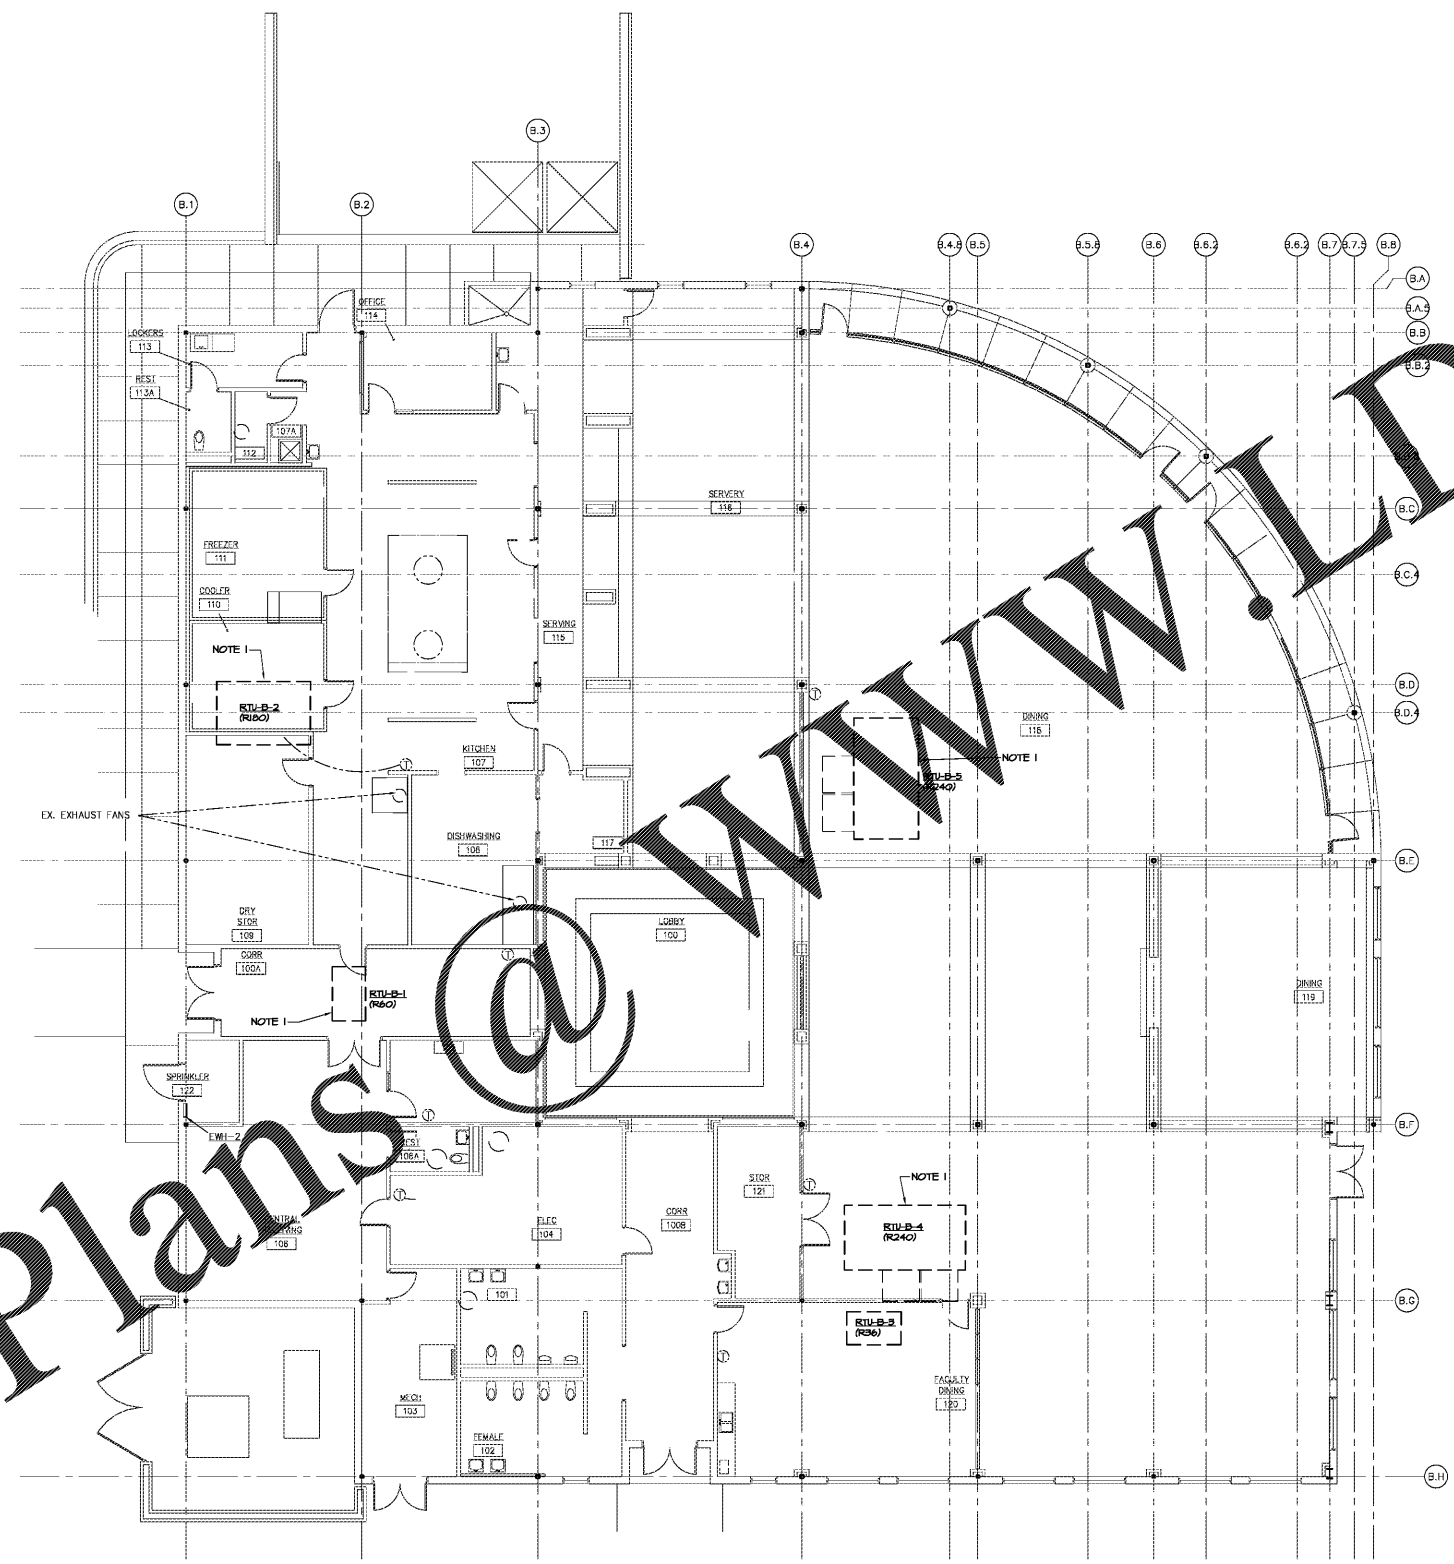

1 PARTIAL FLOOR PLAN - BLDG B - ELECTRICAL  
 E1.2 1/8"=1'-0"



JOB NO. 1805

cunningham forehand matthews moore

cunningham, forehand, matthews & moore, architects, inc. - 2011 manchester street, n.e. - atlanta, georgia 30324 - phone (404) 873-2152

E1.2

Order Plans @ WWW.DILine.com