



DRAWING ISSUE RECORD		
DATE	REVISIONS	NO.
10/30/18	BID SET	

HYAC REPLACEMENT FOR
NORTH OCONEE HIGH SCHOOL
EG: 108-010-010
FOR THE
OCONEE COUNTY BOARD OF EDUCATION
WATKINSVILLE, GEORGIA


DATE: SEP 14, 2018
JOB NO: 18-11-009-19
DWG. BY: G.T.R.
G.L.K.

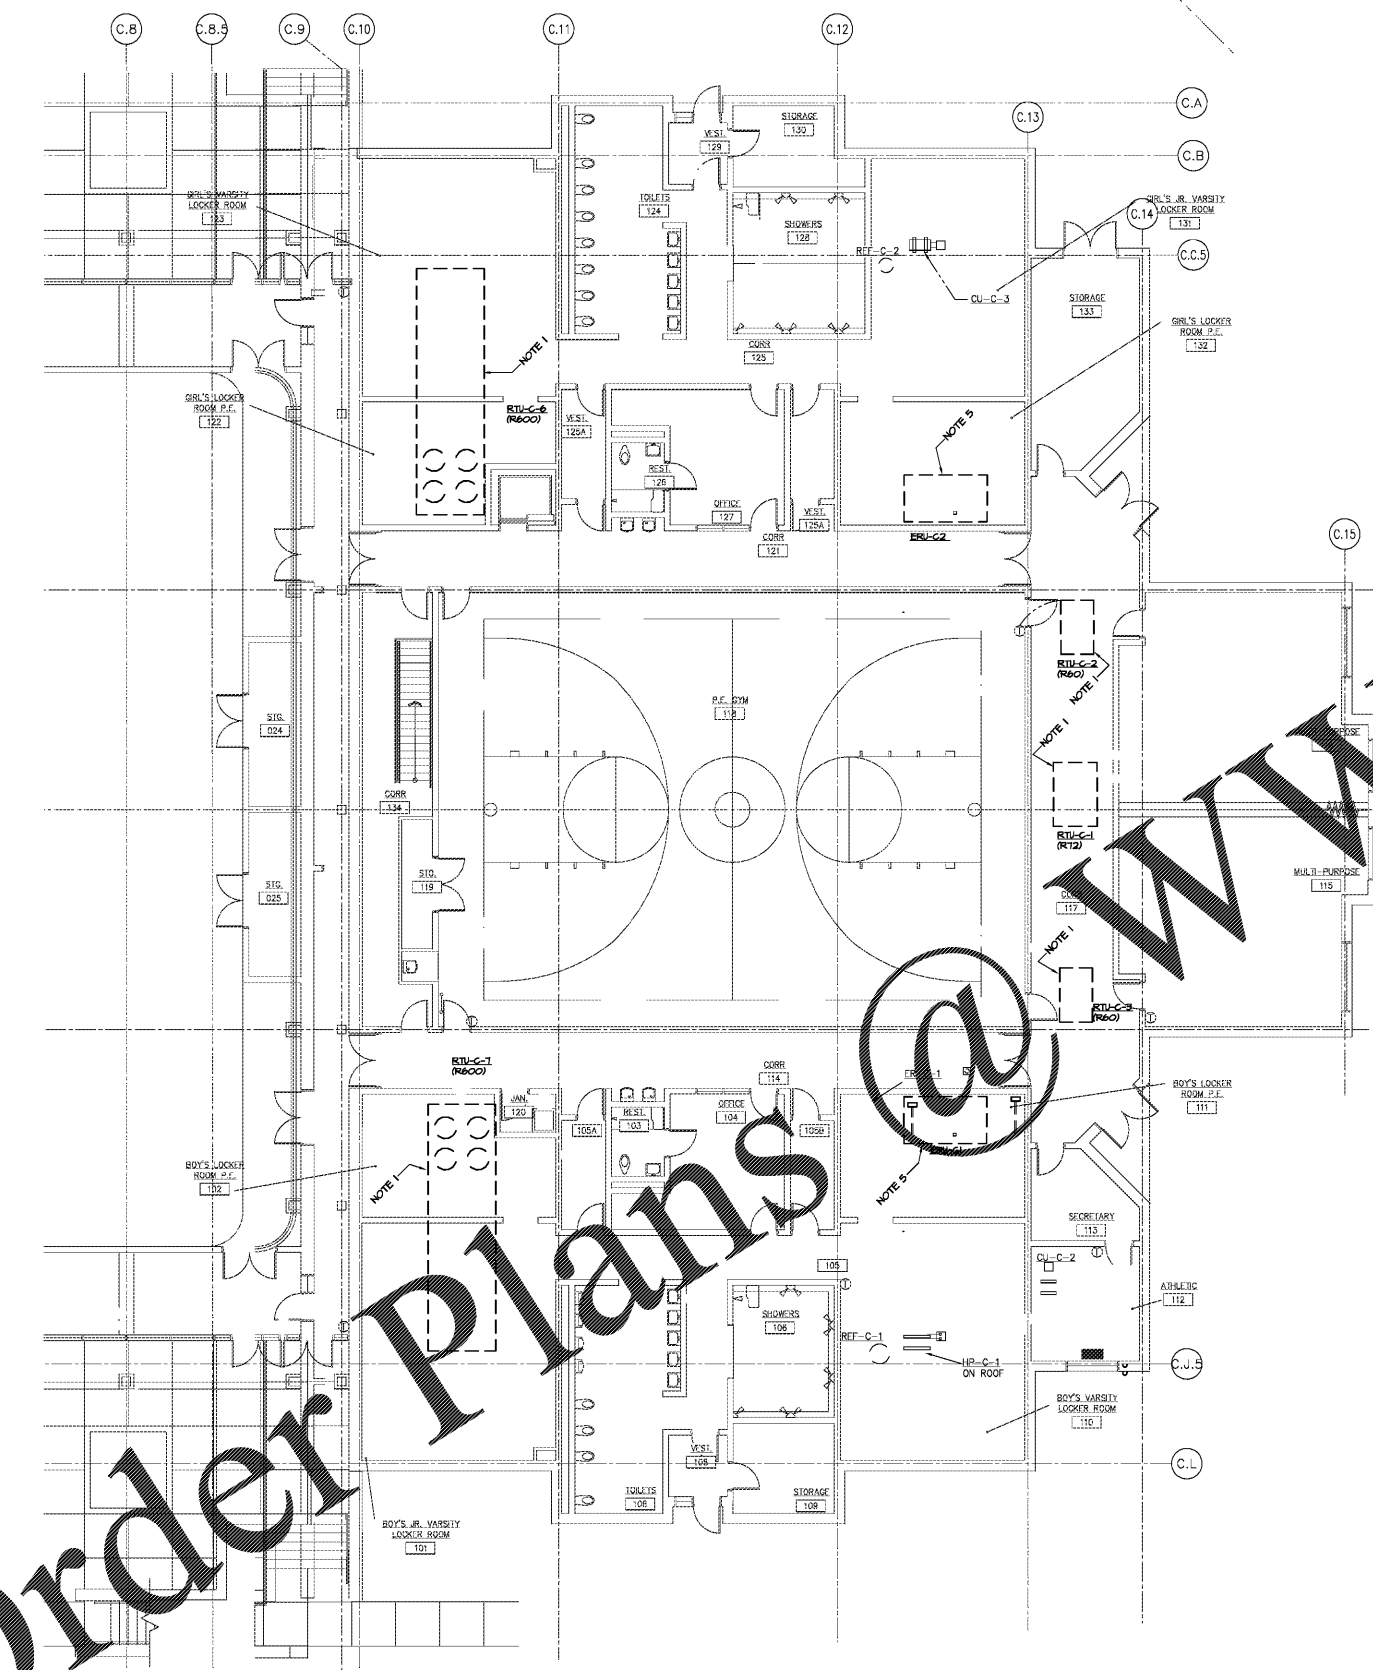

1 PARTIAL FLOOR PLAN - BLDG C UPPER LEVEL - ELECTRICAL
E1.3 1/8"=1'-0"

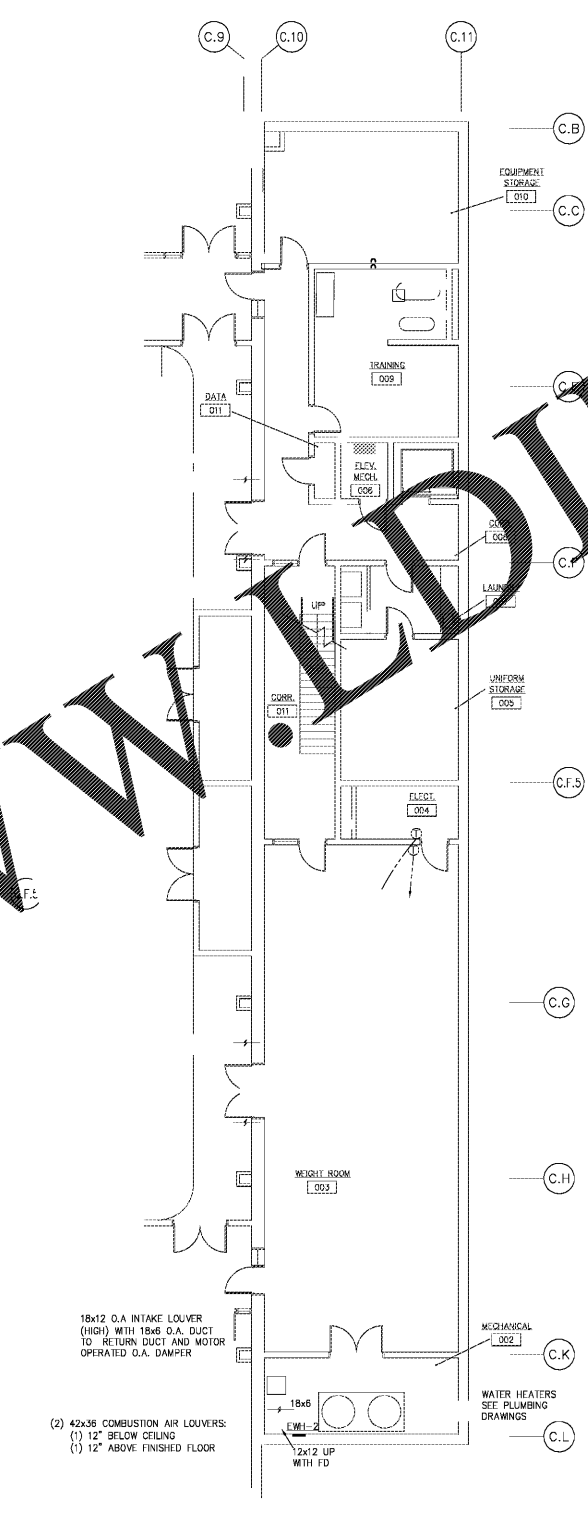

2 PARTIAL FLOOR PLAN - BLDG C LOWER LEVEL - ELECTRICAL
E1.3 1/8"=1'-0"

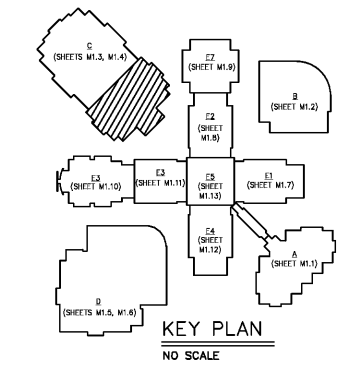


18x12 O.A. INTAKE LOUVER (HIGH) WITH 18x6 O.A. DUCT TO RETURN DUCT AND MOTOR OPERATED O.A. DAMPER

(2) 42x36 COMBUSTION AIR LOUVERS: (1) 12" BELOW CEILING (1) 12" ABOVE FINISHED FLOOR

Order Plans @

WWW.LDILine.com

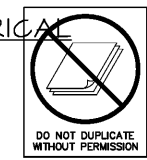

cunningham forhand matthews moore
cunningham, forhand, matthews & moore, architects, inc. - 2011 manchester street, n.e. - atlanta, georgia 30324 - phone (404) 873-2152