



DRAWING ISSUE RECORD		
DATE	REVISIONS	NO.
10/30/18	BID SET	

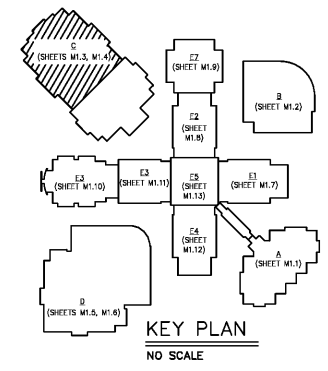

1 PARTIAL FLOOR PLAN - BLDG C LOWER LEVEL - ELECTRICAL  
E1.4 1/8"=1'-0"

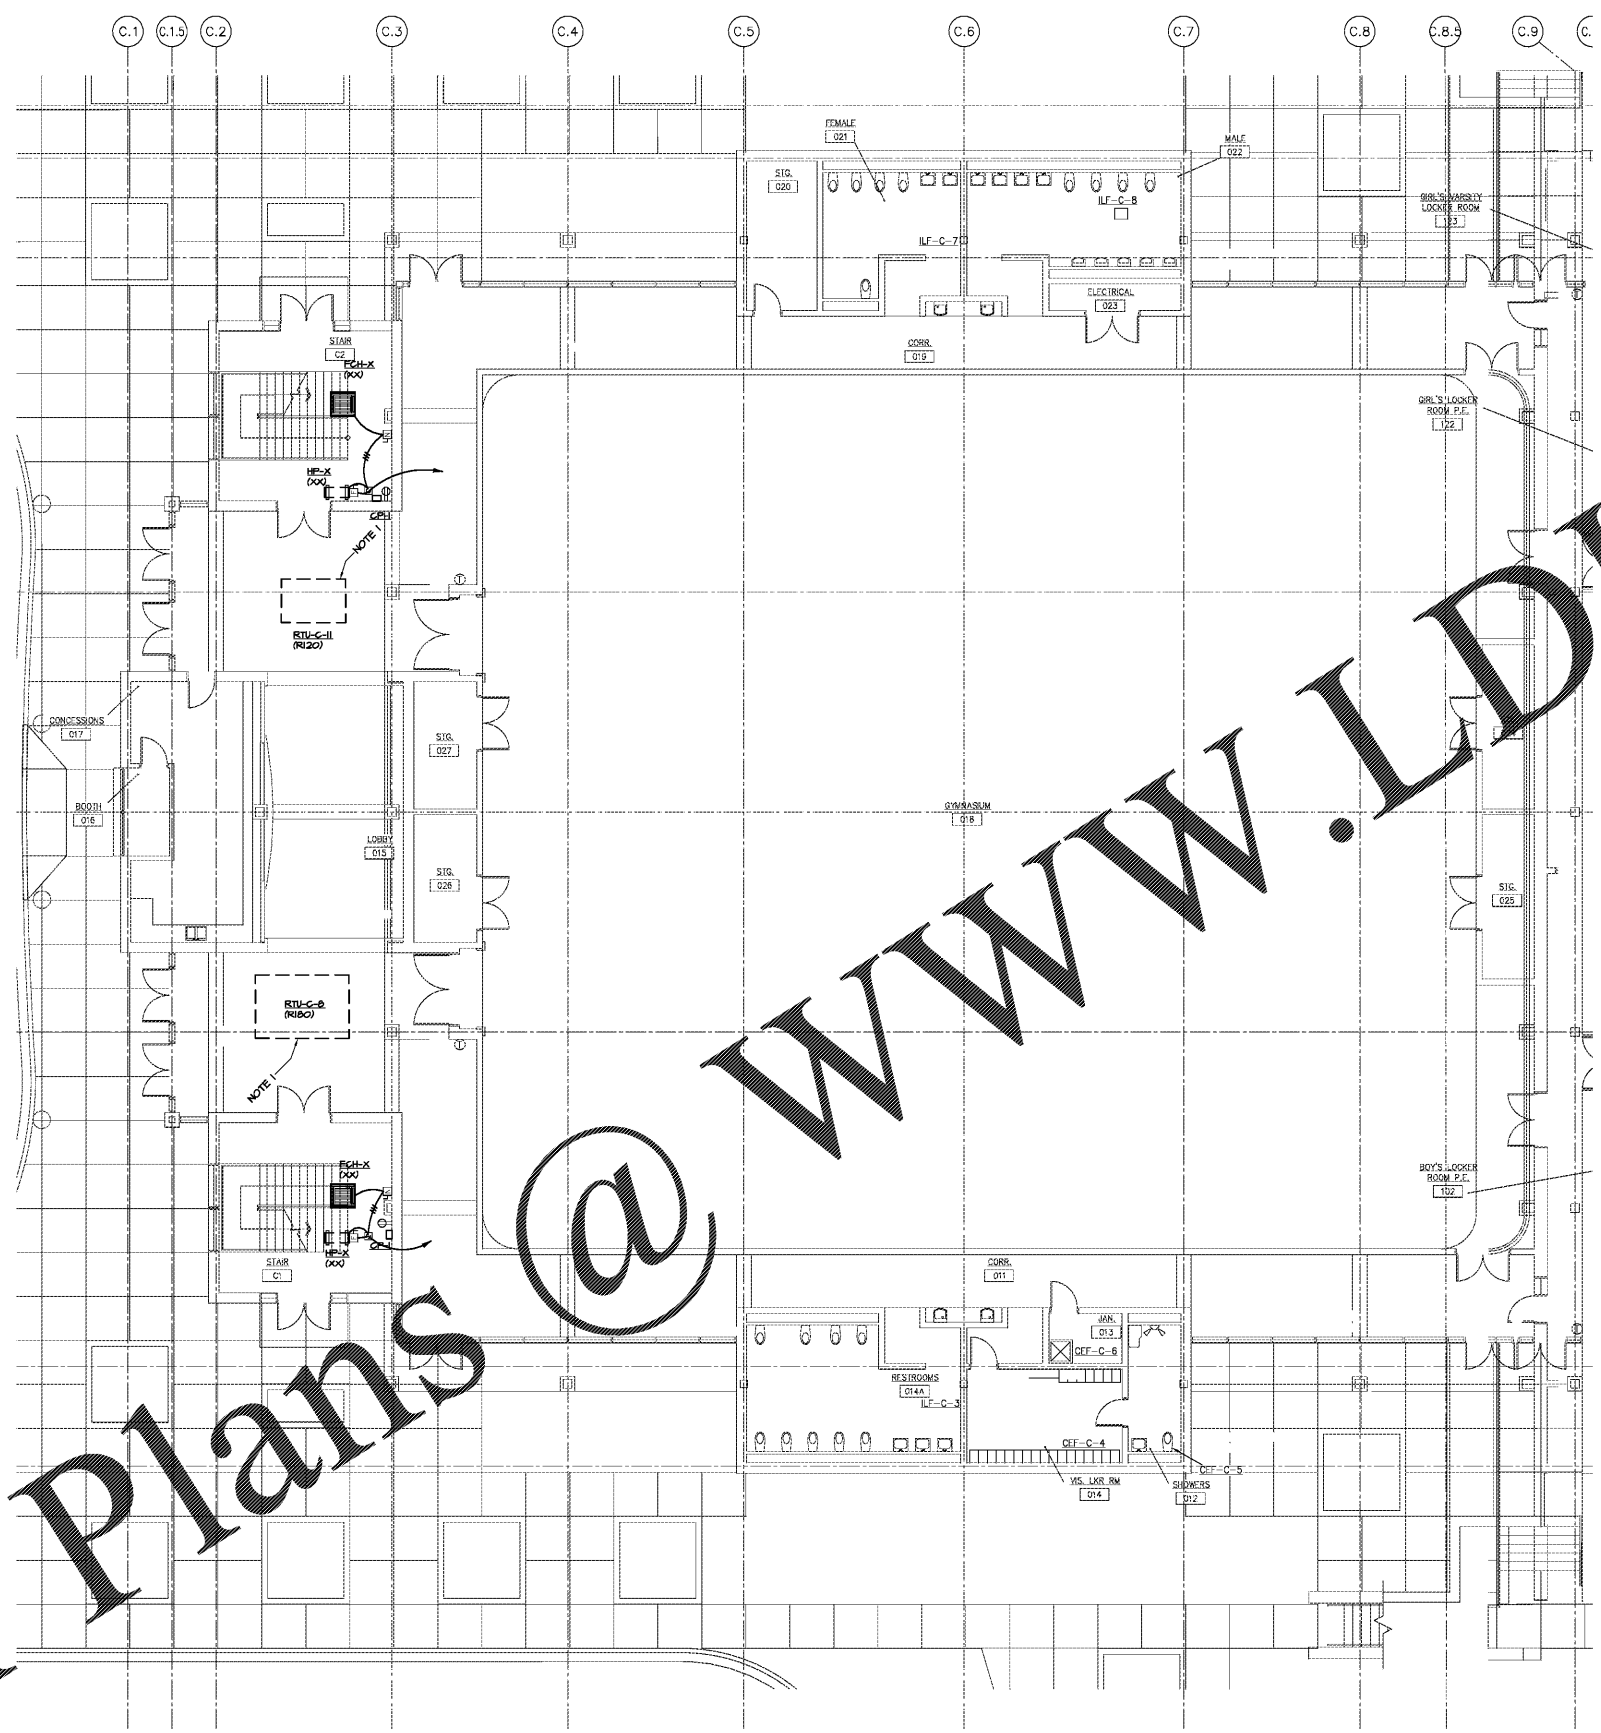

JOB NO. 1805

E1.4

Order Plans @

WWW.LDILine.com

HYAC REPLACEMENT FOR  
NORTH OCONEE HIGH SCHOOL  
EG: 108-010-010  
FOR THE  
OCONEE COUNTY BOARD OF EDUCATION  
WATKINSVILLE, GEORGIA

cunningham, forehand, matthews & moore, architects, inc. - 2011 manchester street, n.e. - atlanta, georgia 30324 - phone (404) 873-2152

DATE: SEPT 14, 2018  
JOB NO. 1805  
DWG. BY: G.T.R.  
DATE: 10/30/18  
JOB NO. 1805  
DWG. BY: G.L.K.