


Order Plans @

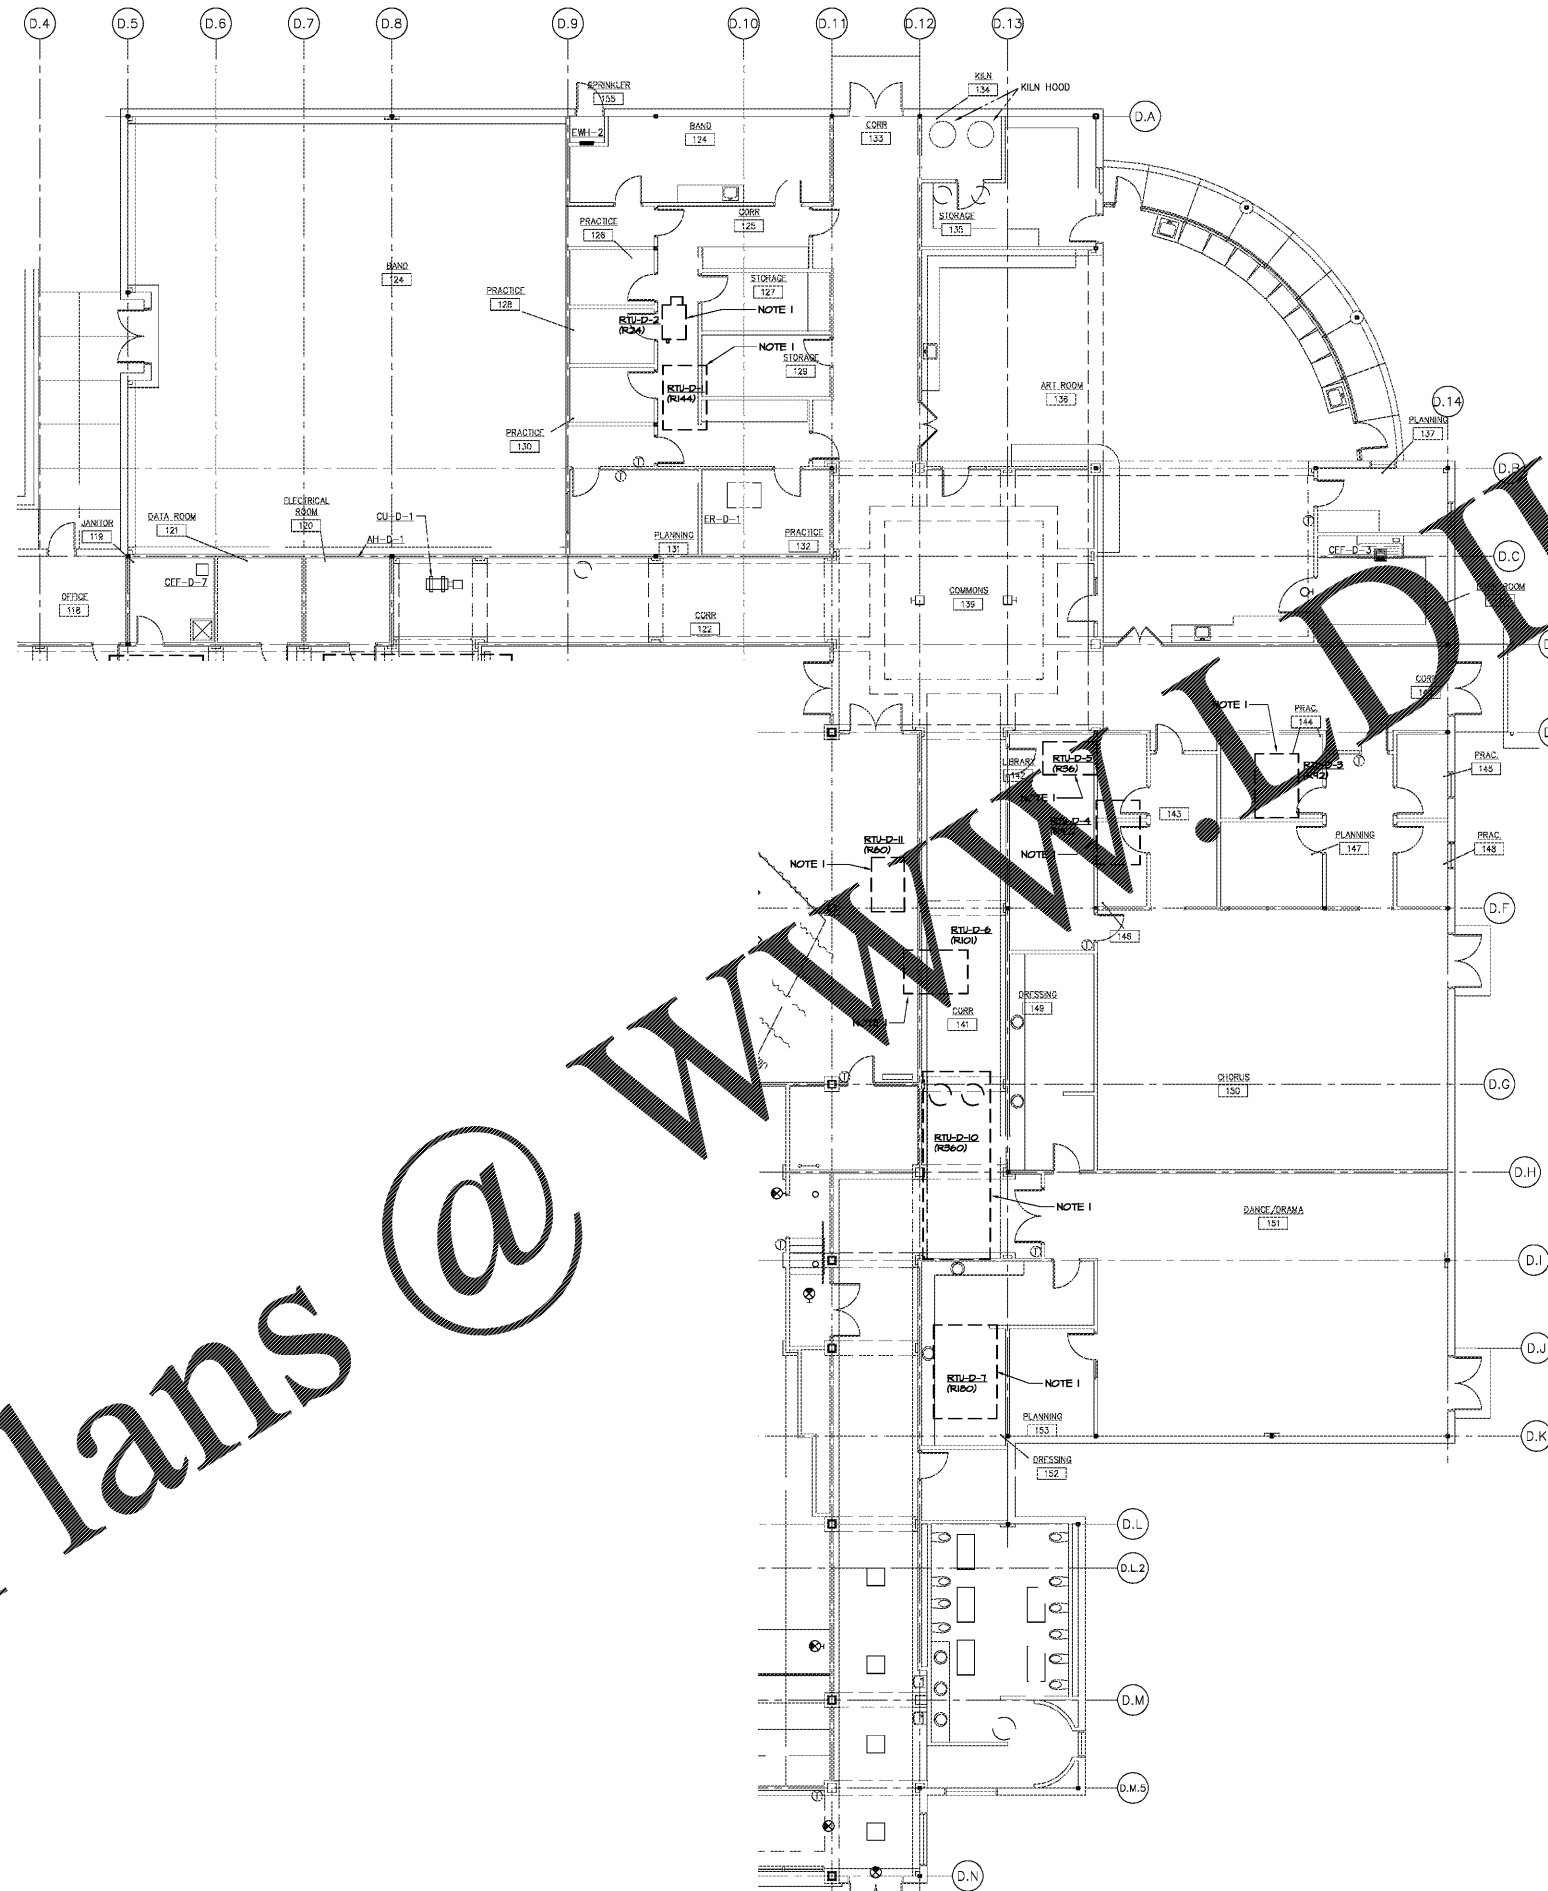


DRAWING ISSUE RECORD		
DATE	REVISIONS	NO.
10/30/18	BID SET	

HYVAC REPLACEMENT FOR
NORTH OCONEE HIGH SCHOOL
EG: 108-010-010
FOR THE
OCONEE COUNTY BOARD OF EDUCATION
WATKINSVILLE, GEORGIA

DATE: SEPT 4, 2018
JOB NO: 18-1-009-18
DWG. BY: G.T.R.

WWW.DLine.com

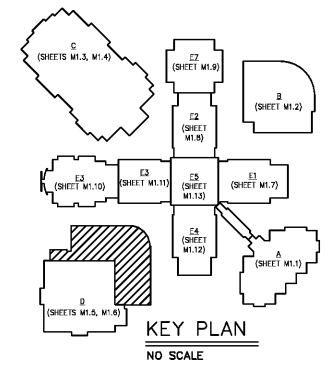

1 PARTIAL FLOOR PLAN - BLDG D - ELECTRICAL
E1.5 1/8"=1'-0"



cunningham forehand matthews moore

cunningham, forehand, matthews & moore, architects, inc. - 2011 manchester street, n.e. - atlanta, georgia 30324 - phone (404) 873-2152