



DRAWING ISSUE RECORD		
DATE	REVISIONS	NO.
10/30/18	BID SET	

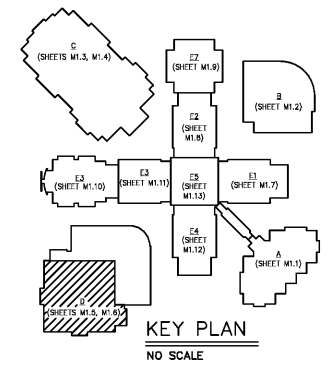

1 PARTIAL FLOOR PLAN - BLDG D - ELECTRICAL
E1.6 1/8"=1'-0"

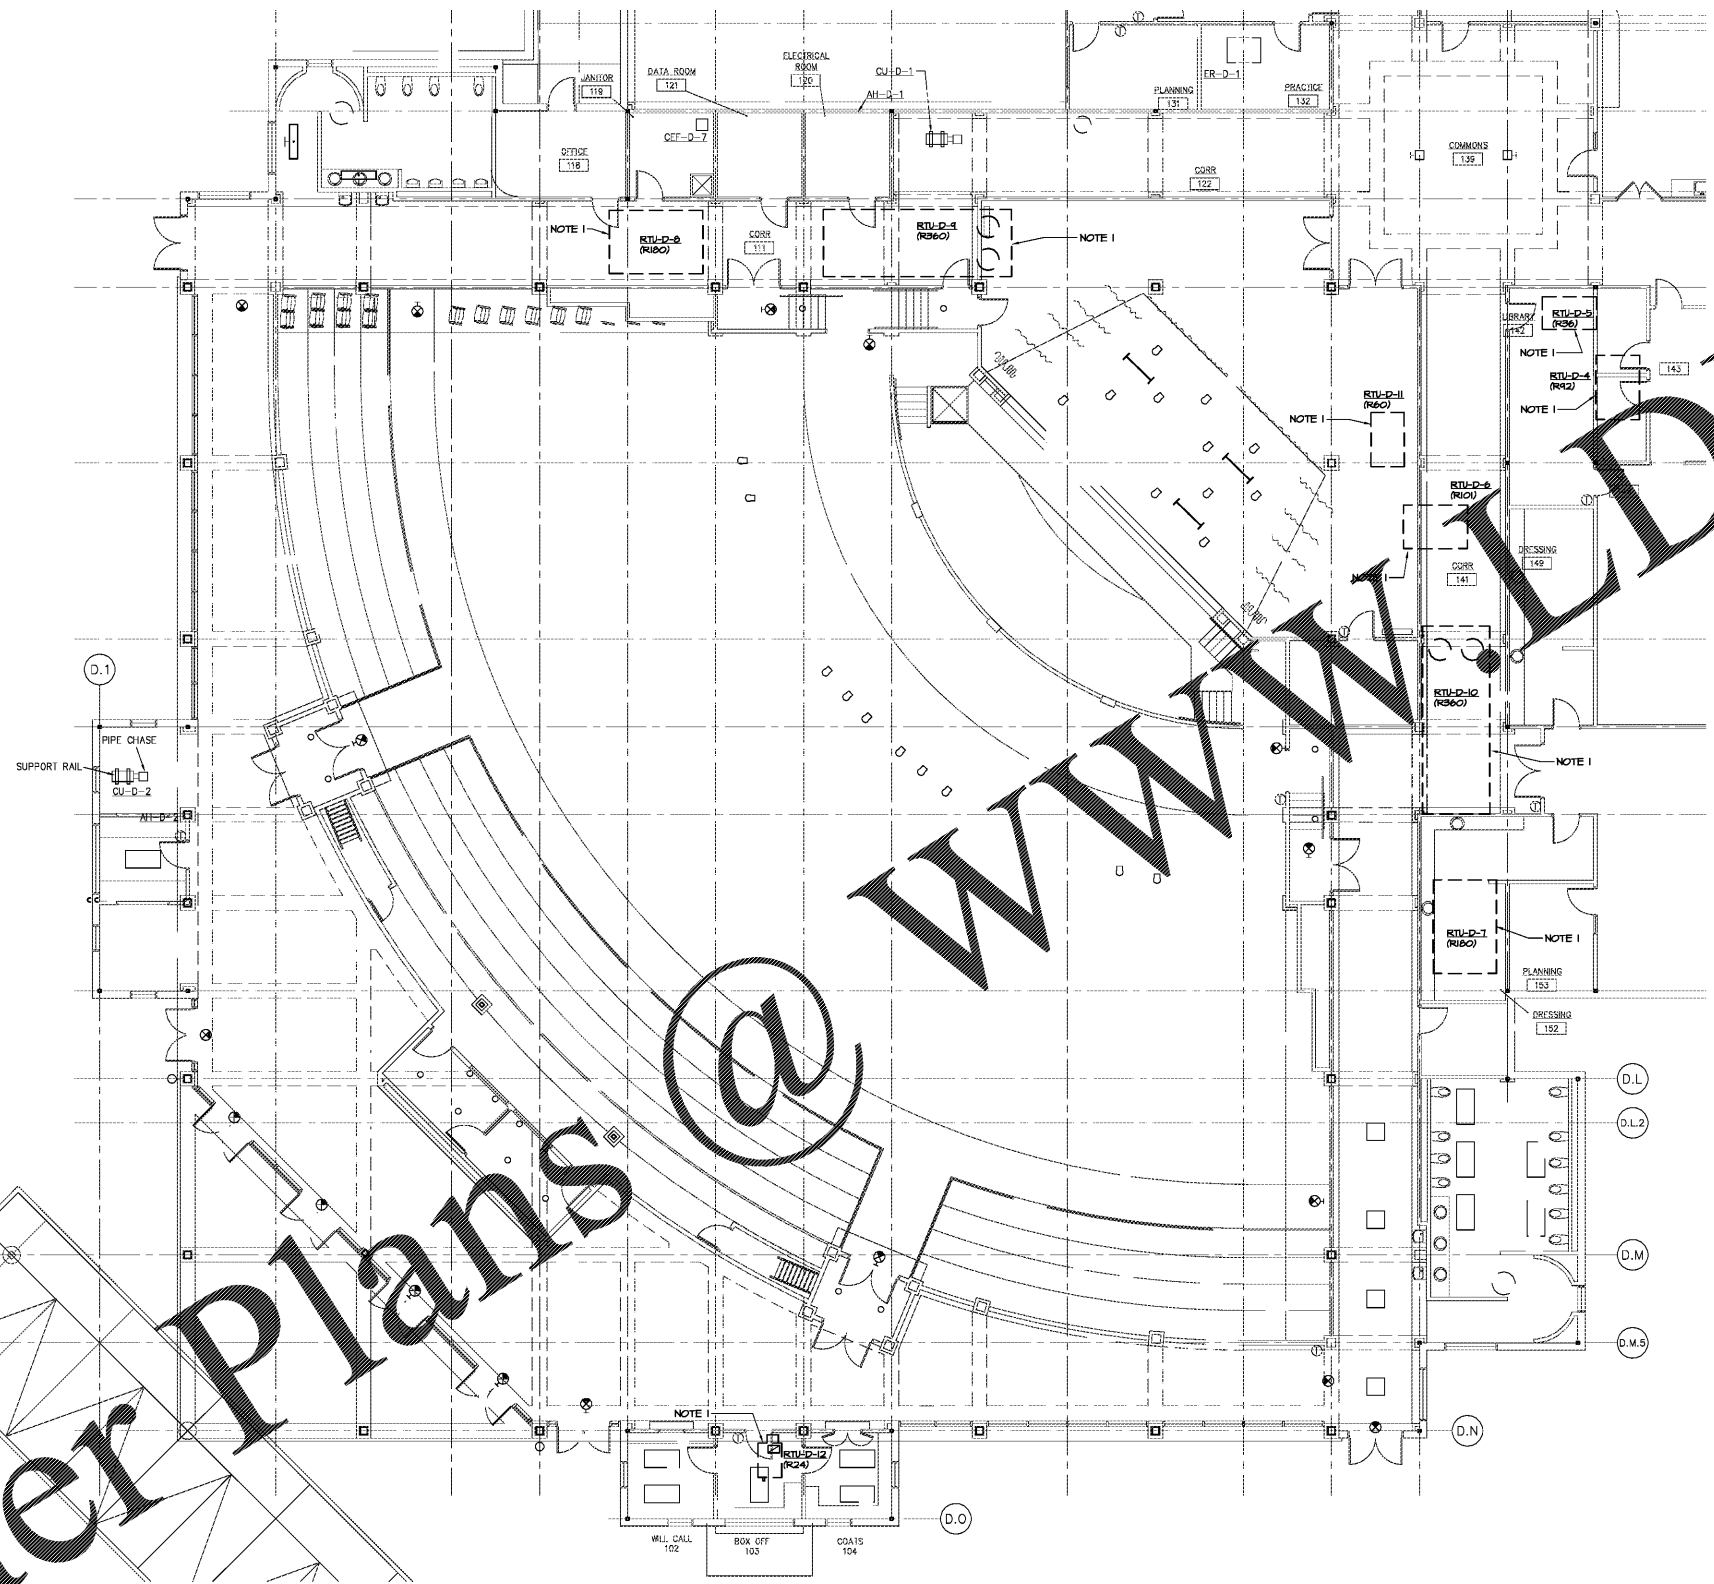

JOB NO. 1805

E1.6

cunningham forehand matthews moore

cunningham, forehand, matthews & moore, architects, inc. - 2011 manchester street, n.e. - atlanta, georgia 30324 - phone (404) 873-2152

HYVAC REPLACEMENT FOR
NORTH OCONEE HIGH SCHOOL
EG: 108-010-01
FOR THE
OCONEE COUNTY BOARD OF EDUCATION
WATKINSVILLE, GEORGIA

DATE: SEPT 4, 2018
JOB NO. 1805
DWG. BY: G.T.R.
DATE: 10/30/18
JOB NO. 1805
DWG. BY: G.L.K.

Order Plans @ WWW.LDLine.com