

DATE	NO.	DESCRIPTION
01/27/18	001	ISSUE PRELIMINARY SUBMITTAL DESIGN DEVELOPMENT
01/19/18	002	ISSUE CONSTRUCTION DOCUMENTS
01/17/18	003	ISSUE CHECK-SET/PERMIT SET
01/10/18	004	ISSUE FINAL GDC SUBMITTAL ISSUED FOR PROPOSAL

DOE FACILITY CODE: 660-3086
 RIVERWOOD HIGH SCHOOL PHASE 3-8
 AUDITORIUM/GYMNASIUM ADDITION
 5900 RAIDER DRIVE NW SANDY SPRINGS, GA 30328
 FULTON COUNTY SCHOOLS RFP NO. 411-19

CHAPMAN GRIFFIN LANIER SUSSENBACK ARCHITECTS
 400 Galleria Pkwy., Suite 100 Atlanta, Ga 30339 Phone: 404.733.5493



PROJECT NO. 16015.02
 DATE 09/17/18
 DRAWN BY: Author
 CHECKED BY: Checker
 SHEET NO. **A-3.11**

- RCP NOTES**
- REFER ELECTRICAL DRAWINGS FOR LIGHT FIXTURE SPECIFICATIONS.
 - CEILING HEIGHTS ARE INDICATED AS NUMBER OF FEET ABOVE FINISH FLOOR ELEVATION OF ROOM OR SPACE UNLESS NOTED OTHERWISE.
 - PROVIDE ADDITIONAL SUPPORTS FOR FLEXIBLE CONDUITS AND FLEXIBLE DUCTS TO AVOID CONTACT WITH FINISH CEILING MATERIALS.
 - PROVIDE ADDITIONAL HANGER WIRE AT CORNER OF EACH LAY-IN LIGHT.
 - REFER TO REFLECTED CEILING PLAN LEGEND FOR ALL SYMBOLS. COORDINATE WITH MECHANICAL & ELECTRICAL DRAWINGS FOR ADDITIONAL SYMBOLS AND SCHEDULES.
 - CONTRACTOR SHALL VERIFY THE LOCATIONS OF SLOT DIFFUSERS, SUPPLY AND RETURN GRILLES AND COORDINATE WITH THE MECHANICAL CONTRACTOR.
 - CONTRACTORS SHALL VERIFY THAT LOCATION OF ALL LIGHT FIXTURES AND COORDINATE INSTALLATION WITH THE MECHANICAL AND ELECTRICAL CONTRACTORS. NOTIFY THE ARCHITECT OF ANY CONFLICTS PRIOR TO INSTALLATION.
 - PROVIDE 2' X 2' ACCESS PANELS AT VALVES AND CONTROLS EQUIPMENT LOCATED ABOVE HARD CEILINGS. SEE MEP DRAWINGS FOR LOCATIONS OF VALVES AND CONTROL EQUIPMENT.
 - LIGHTING, DIFFUSERS, SPRINKLERS, SPEAKERS, ETC. SHOWN ARE FOR LOCATION AND COORDINATION ONLY. SEE ENGINEER'S DOCUMENTS FOR FURTHER INFORMATION.
 - ALL CEILING GRID INSTALLATIONS SHALL HAVE THE CENTER TILE DIMENSIONED EQUALLY IN THE CENTER OF THE ROOM LOCATION UNLESS NOTED OTHERWISE.
 - ALL LINEAR DIFFUSERS SHALL HAVE FINISH TO MATCH PAINT COLOR / OR SPECIAL FINISH OF CEILING / WALL OF INSTALLATION.

- RCP KEY**
- CEILING TYPES:
 ACT ACOUSTICAL TILE (NUMBER INDICATES TYPE) SEE FINISH NOTES.
 G GYPSUM BOARD, SAG RESISTANT
 MCS METAL CEILING SYSTEM
 E EXPOSED TO STRUCTURE
 S STUCCO ON METAL LATH
 AL PRE-MANUFACTURED ALUMINUM CANOPY
 WD WOOD

RCP LEGEND

	ACT CEILING TILE & GRID		EMERGENCY
	GYP BD CEILING		EXHAUST FAN
	MCS CEILING TILE & GRID		24 FLUORESCENT LIGHT FIXTURE
	AUDITORIUM SOUND DIFFUSER SYSTEM		2x2 FLUORESCENT LIGHT FIXTURE
	STUCCO		EMERGENCY LIGHT FIXTURE
	CEILING TYPE CEILING HEIGHT ROOM NUMBER CEILING INFO TAG		SURFACE MOUNTED FLUORESCENT FIXTURE
	RETURN AIR HVAC DIFFUSER		GYMNASIUM LIGHT FIXTURE
	SUPPLY AIR HVAC DIFFUSER		RECESSED LIGHT FIXTURE
	ELECTRIC HEATER		EXIT SIGN
	ACOUSTICAL DIFFUSER		WALL MOUNTED LIGHT FIXTURE
			COVE LIGHTING

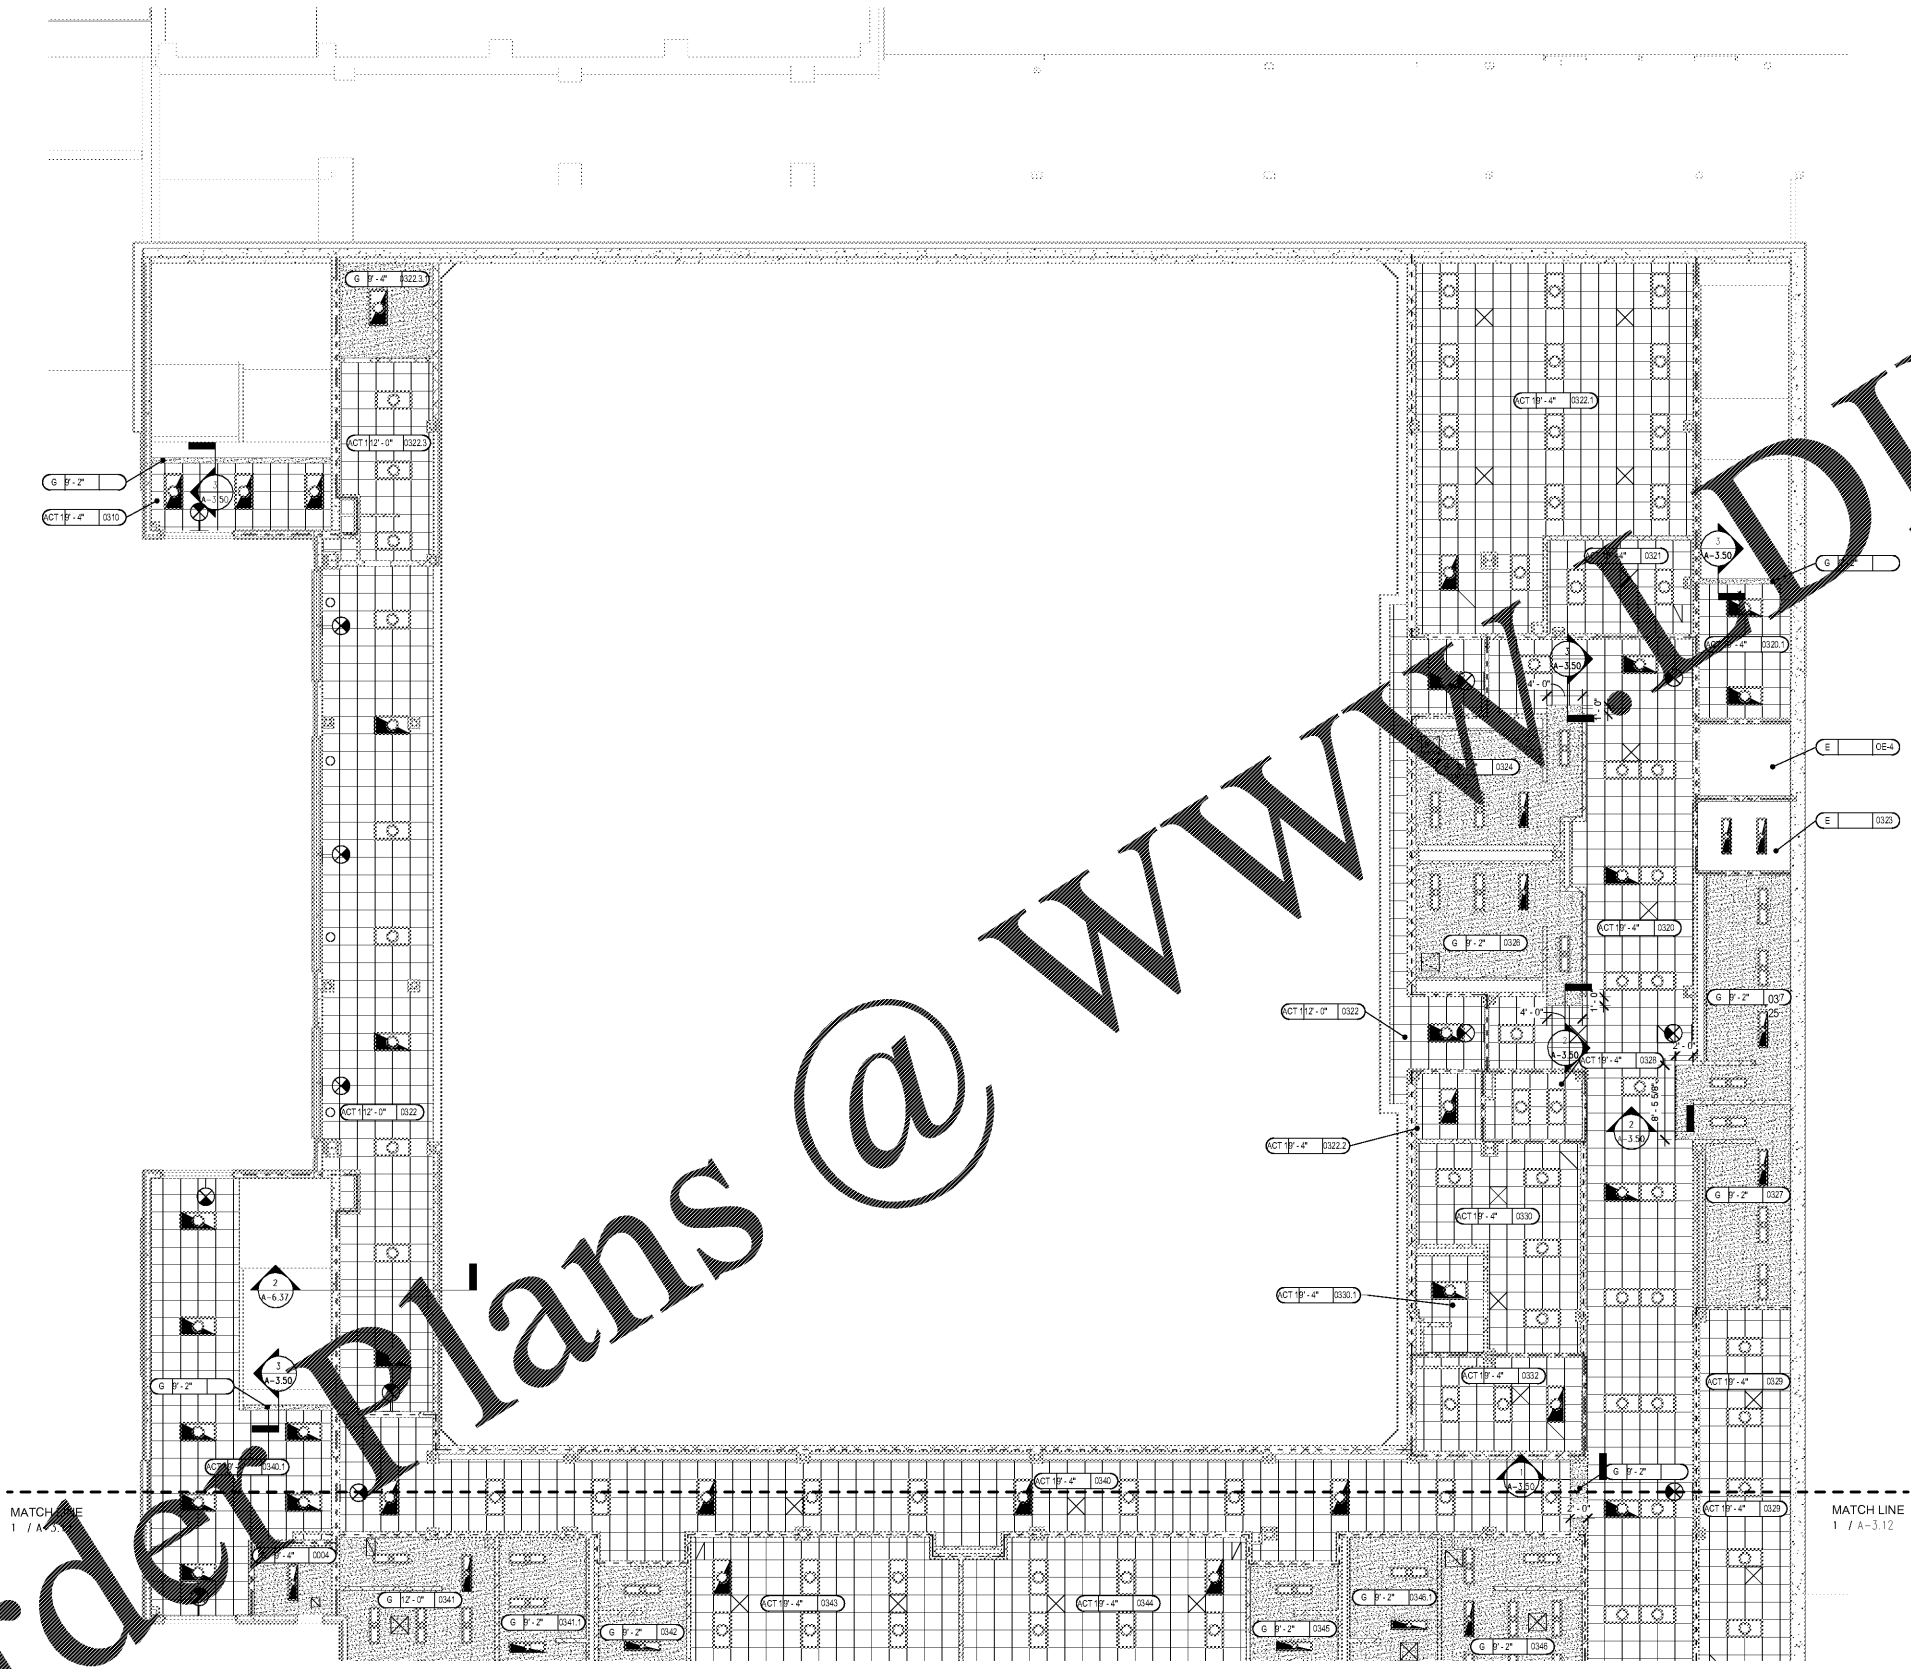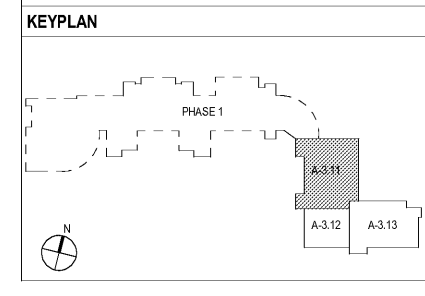

1 LEVEL 000 REFLECTED CEILING PLAN - PART 1
 A-3.11 1/8" = 1'-0"

Order Plans @ WWW.DIline.com