


Order Plans

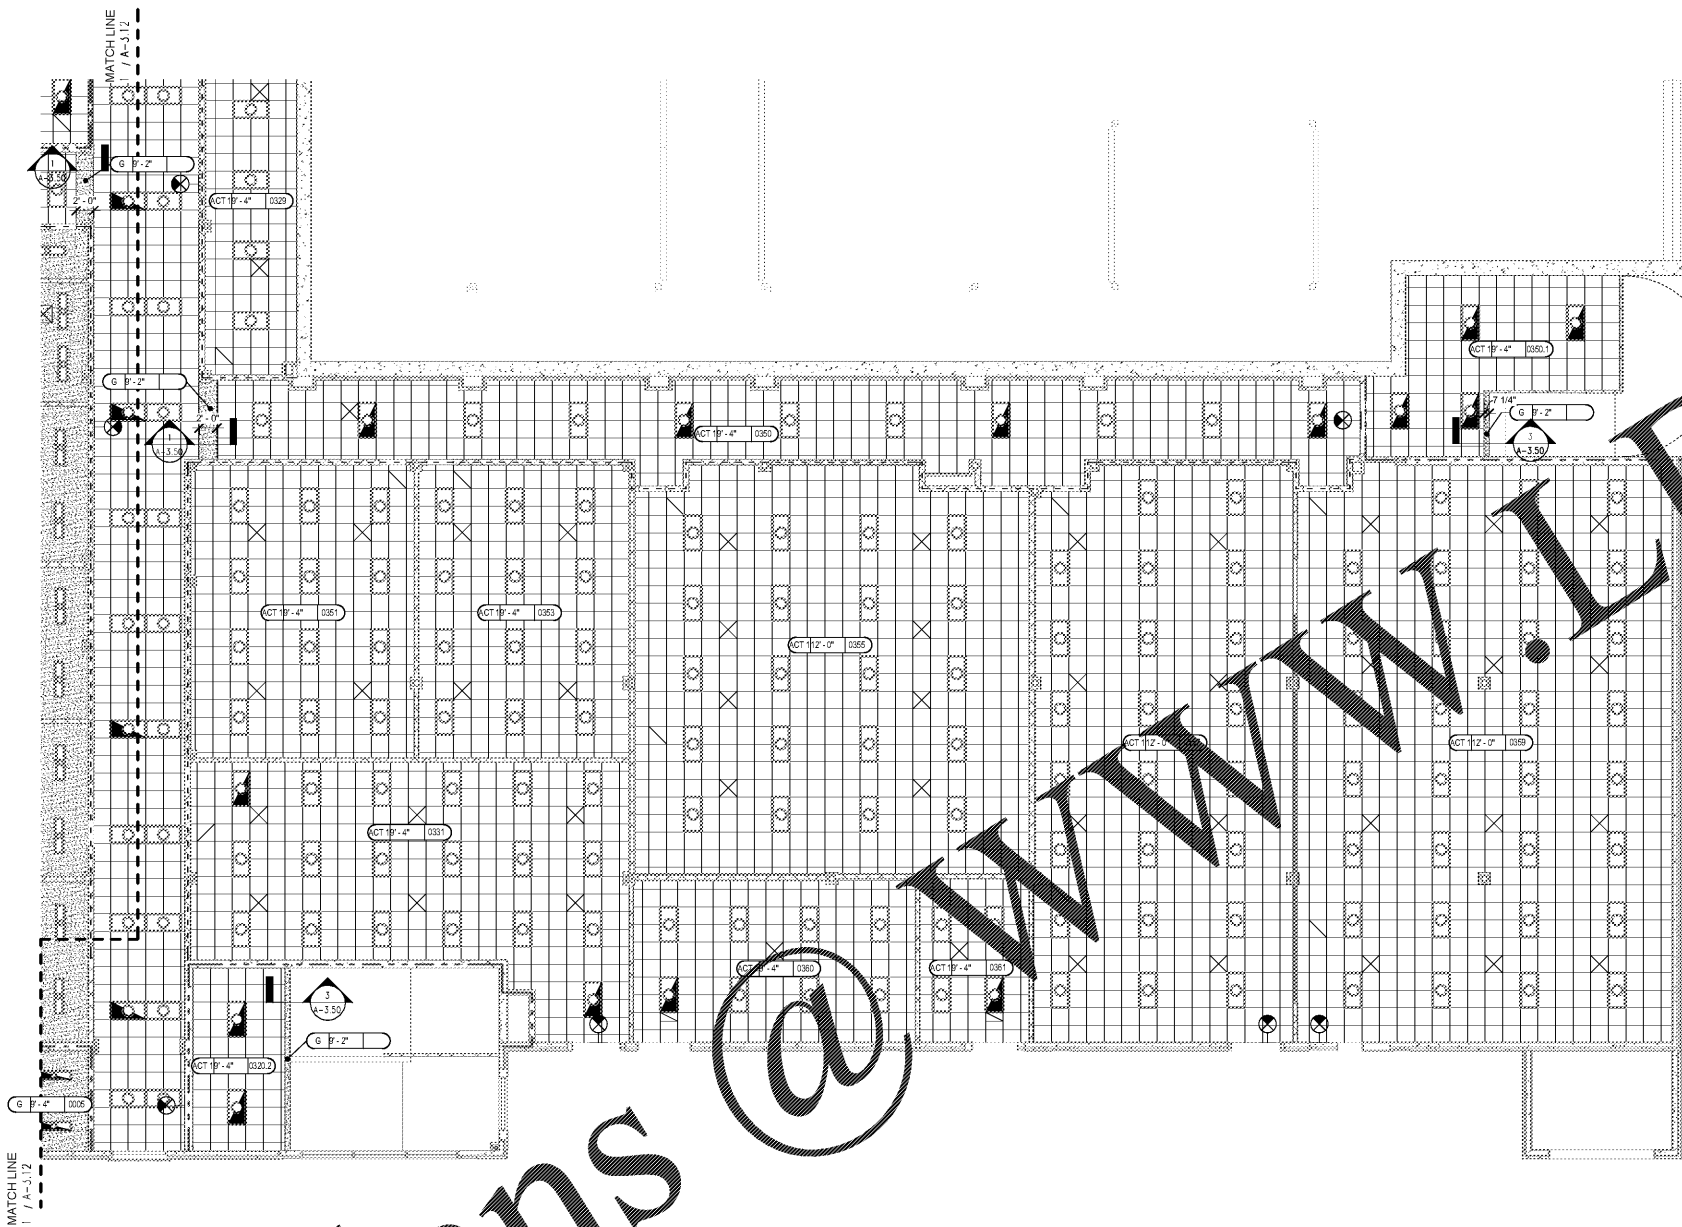

1 LEVEL 000 REFLECTED CEILING PLAN - PART 3  
A-3.13 1/8" = 1'-0"

**RCP NOTES**

- REFER TO ELECTRICAL DRAWINGS FOR LIGHT FIXTURE SPECIFICATIONS.
- CEILING HEIGHTS ARE INDICATED AS NUMBER OF FEET ABOVE FINISH FLOOR ELEVATION OF ROOM OR SPACE UNLESS NOTED OTHERWISE.
- PROVIDE ADDITIONAL SUPPORTS FOR FLEXIBLE CONDUITS AND FLEXIBLE DUCTS TO AVOID CONTACT WITH FINISH CEILING MATERIALS.
- PROVIDE ADDITIONAL HANGER WIRE AT CORNER OF EACH LAY-IN LIGHT.
- REFER TO REFLECTED CEILING PLAN LEGEND FOR ALL SYMBOLS. COORDINATE WITH MECHANICAL & ELECTRICAL DRAWINGS FOR ADDITIONAL SYMBOLS AND SCHEDULES.
- CONTRACTOR SHALL VERIFY THE LOCATIONS OF SLOT DIFFUSERS, SUPPLY AND RETURN GRILLES AND COORDINATE WITH THE MECHANICAL CONTRACTOR.
- CONTRACTORS SHALL VERIFY THAT LOCATION OF ALL LIGHT FIXTURES AND COORDINATE INSTALLATION WITH THE MECHANICAL AND ELECTRICAL CONTRACTORS. NOTIFY THE ARCHITECT OF ANY CONFLICTS PRIOR TO INSTALLATION.
- PROVIDE 2 X 2 ACCESS PANELS AT VALVES AND CONTROLS EQUIPMENT LOCATED ABOVE HARD CEILINGS. SEE MEP DRAWINGS FOR LOCATIONS OF VALVES AND CONTROL EQUIPMENT.
- LIGHTING, DIFFUSERS, SPRINKLERS, SPEAKERS, ETC. SHOWN ARE FOR LOCATION AND COORDINATION ONLY. SEE ENGINEERS DOCUMENTS FOR FURTHER INFORMATION.
- ALL CEILING GRID INSTALLATIONS SHALL HAVE THE CENTER TILE DIMENSIONED EQUALLY IN THE CENTER OF THE ROOM LOCATION UNLESS NOTED OTHERWISE.
- ALL LINEAR DIFFUSERS SHALL HAVE FINISH TO MATCH PAINT COLOR / OR SPECIAL FINISH OF CEILING / WALL OF INSTALLATION.


**RCP KEY**

- CEILING TYPES:  
 ACT GYPSUM BOARD, SAG RESISTANT  
 G GYPSUM BOARD, SAG RESISTANT  
 MCS METAL CEILING SYSTEM  
 E EXPOSED TO STRUCTURE  
 S STUCCO ON METAL LATH  
 AL PRE-MANUFACTURED ALUMINUM CANOPY  
 WD WOOD

**RCP LEGEND**

	ACT CEILING TILE & GRID		EMERGENCY
	GYP BD CEILING		EXHAUST FAN
	MCS CEILING TILE & GRID		2x4 FLUORESCENT LIGHT FIXTURE
	AUDITORIUM SOUND DIFFUSER SYSTEM		2x2 FLUORESCENT LIGHT FIXTURE
	STUCCO		EMERGENCY LIGHT FIXTURE
	CEILING TYPE CEILING HEIGHT ROOM NUMBER CEILING INFO TAG		SURFACE MOUNTED FLUORESCENT FIXTURE
	RETURN AIR HVAC DIFFUSER		GYMNASIUM LIGHT FIXTURE
	SUPPLY AIR HVAC DIFFUSER		RECESSED LIGHT FIXTURE
	ELECTRIC HEATER		EXIT SIGN
	ACOUSTICAL DIFFUSER		WALL MOUNTED LIGHT FIXTURE
			COVE LIGHTING

**KEYPLAN**

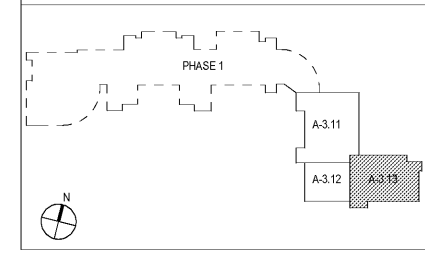

**CGLS ARCHITECTS**  
 CHAPMAN GRIFFIN LANIER SUSENBACH ARCHITECTS  
 400 Galleria Pkwy., Suite 100 Atlanta, Ga 30339 Phone: 404.733.5493

RELEASED FOR CONSTRUCTION

DATE	NO.	DESCRIPTION
03/27/18	001	CODE PRELIMINARY SUBMITTAL DESIGN DEVELOPMENT
06/19/18	002	CODE PRELIMINARY SUBMITTAL DESIGN DEVELOPMENT
09/17/18	003	CODE CHECK-SET/PERM SET
10/10/18	004	FINAL CODE SUBMITTAL ISSUED FOR PROPOSAL

**RIVERWOOD HIGH SCHOOL PHASE 3-8 AUDITORIUM/GYMNASIUM ADDITION**

5900 RAIDER DRIVE NW SANDY SPRINGS, GA 30328  
 FULTON COUNTY SCHOOLS RFP NO. 411-19

**LEVEL 000 RCP - PART 3**

PROJECT NO. 16015.02  
 DATE 09/17/18  
 DRAWN BY: Author  
 CHECKED BY: Cracker

**A-3.13**