

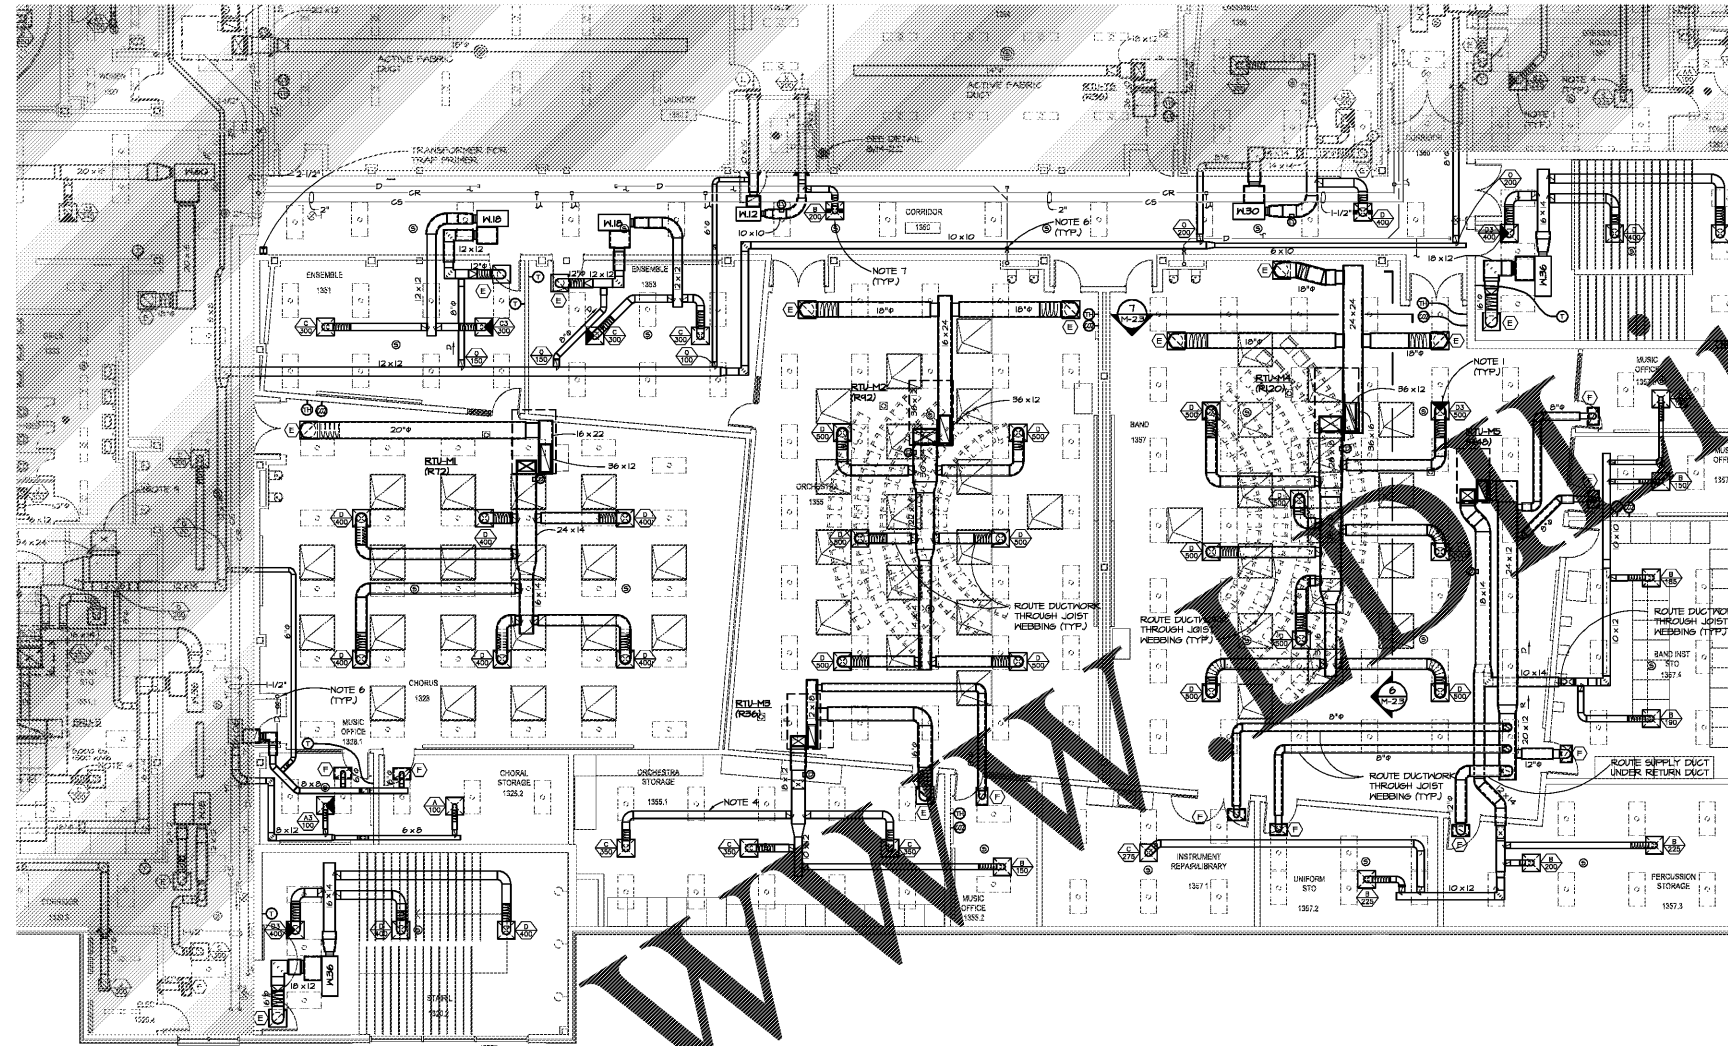


Order Plans @

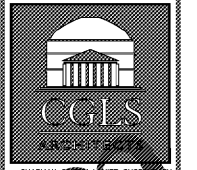

LEVEL 100 FLOOR PLAN - PART 3- HVAC

KEYPLAN - LEVEL 100

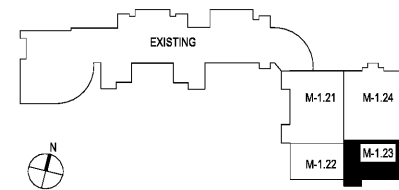

FOR RELEASE
OR CONSTRUCTION
CONSULTANT
**SPURLOCK
ASSOCIATES, INC.**
2970 Clairmont Rd., Suite 620
Atlanta, GA 30329
P: 404.633.0245
F: 404.633.1736



DATE	NO.	DESCRIPTION
03/27/18		ISSUE PRELIMINARY SUBMITTAL
06/14/18		ISSUE DESIGN DEVELOPMENT
06/17/18		ISSUE CONSTRUCTION DOCUMENTS
08/17/18		ISSUE CHECK-SET / PERMIT SET
10/10/18		FINAL ISSUE SUBMITTAL
11/07/18		ISSUE FOR PROPOSAL

DOE FACILITY CODE: 660 -3066
**RIVERWOOD HIGH SCHOOL-PHASE 3-8
AUDITORIUM / GYMNASIUM ADDITION**
5900 RAIDER DRIVE NW SANDY SPRINGS, GA 30328
FULTON COUNTY SCHOOLS RFP NO. 411-18

SHEET TITLE	LEVEL 100 FLOOR PLAN-PART 3- HVAC
PROJECT NO.	18015.02
DATE	09/17/18
DRAWN BY	CPAM/W.D.
CHECKED BY	BLS.
SHEET NO.	M-1.23

CHAPMAN GRIFFIN LANIER SUSENBACHA ARCHITECTS
 600 GUNNERS BLVD, SUITE 100, ATLANTA, GEORGIA 30339