
 
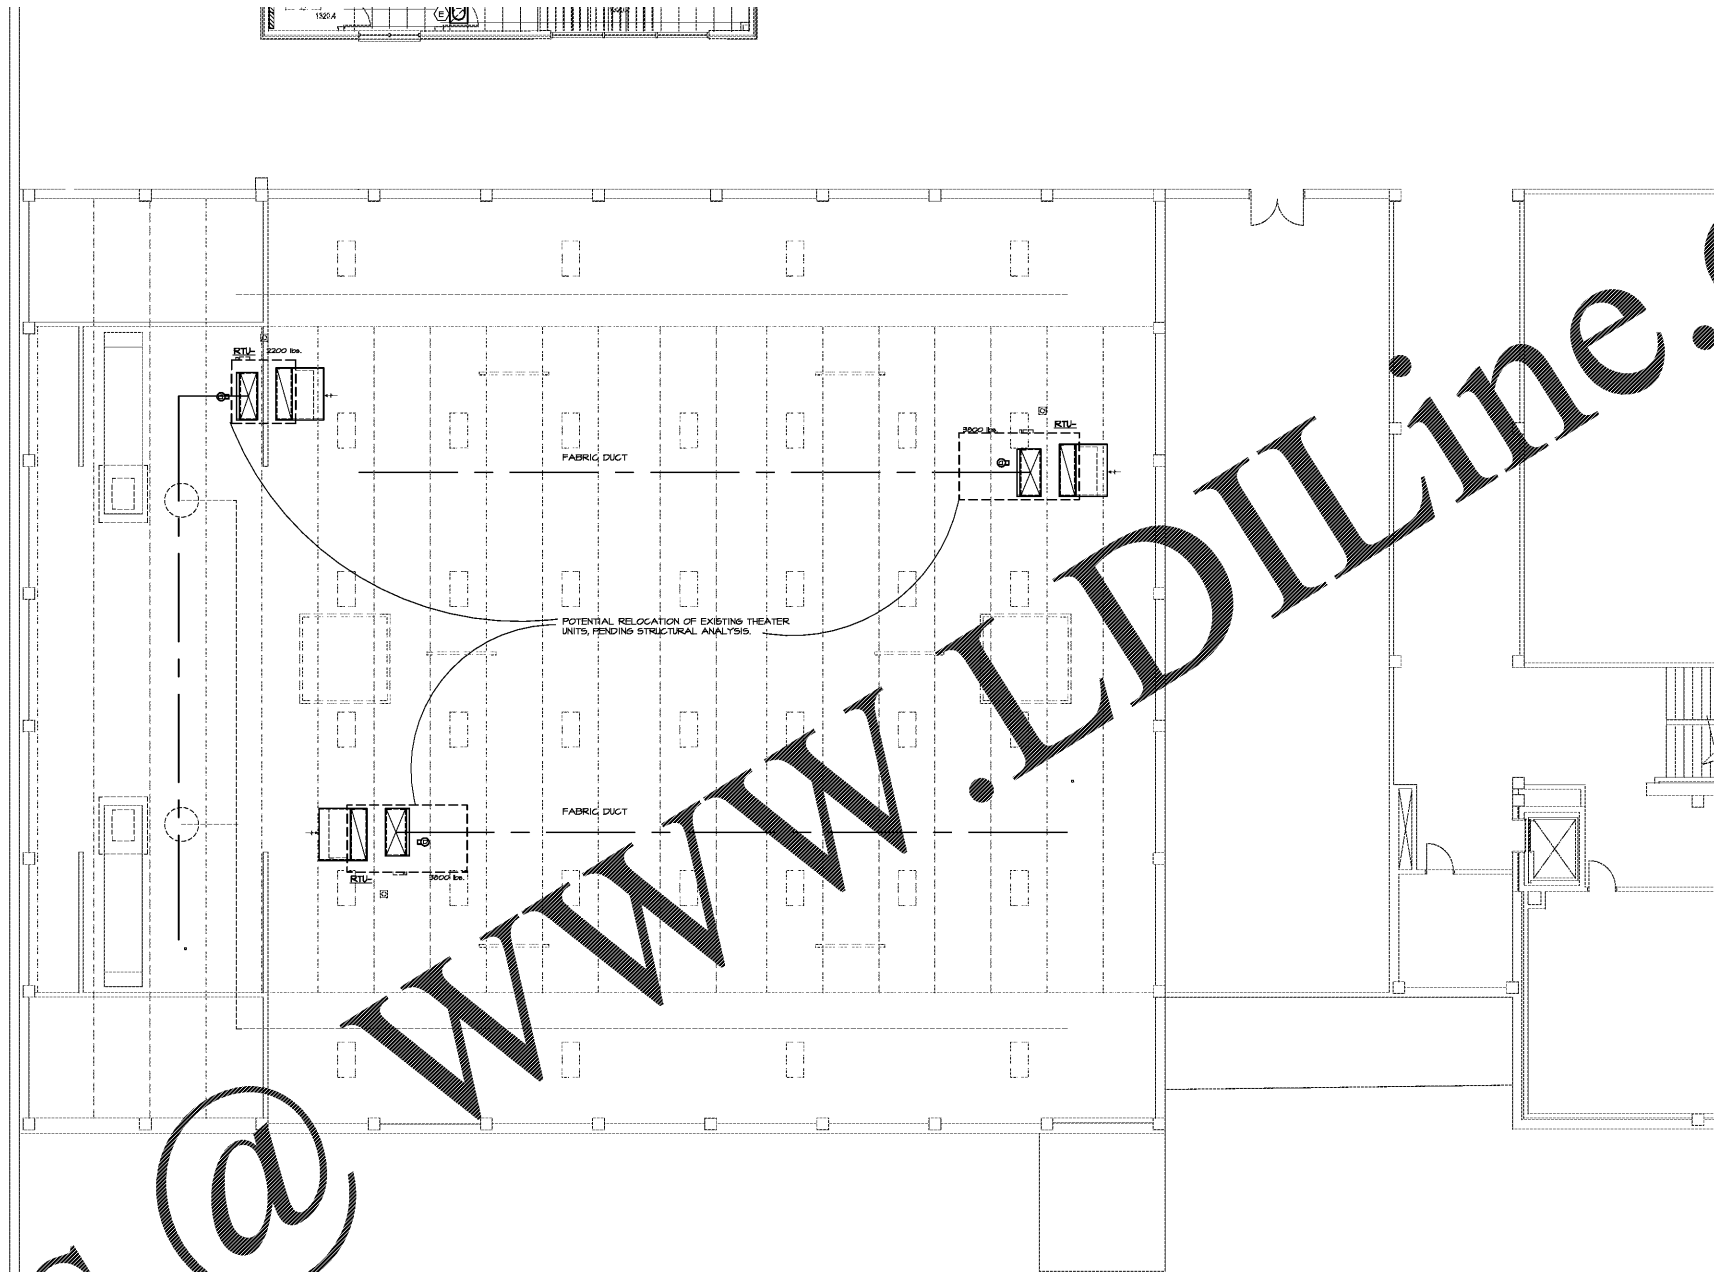


Order Plans @



1 EXISTING GYM - HVAC  
M-1.25 1/8"=1'-0"

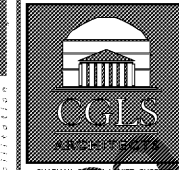

CHAPMAN GRIFFIN LANIER SUSSENBACH ARCHITECTS, P.A.  
ARCHITECTS

THIS DOCUMENT IS THE PROPERTY OF CGLS ARCHITECTS. IT IS TO BE USED ONLY FOR THE PROJECT AND SITE SPECIFICALLY IDENTIFIED HEREON. IT IS NOT TO BE REPRODUCED, COPIED, OR TRANSMITTED IN ANY FORM OR BY ANY MEANS, WITHOUT THE WRITTEN PERMISSION OF CGLS ARCHITECTS.

RELEASED FOR CONSTRUCTION



CONSULTANTS  
SPURLOCK ASSOCIATES, INC.  
2970 Clairmont Rd., Suite 620  
Atlanta, GA 30329  
P: 404.633.0245  
F: 404.633.1736

SEAL



DATE	NO.	DESCRIPTION
03/27/18		ISSUE PRELIMINARY SCHEDULE, F.
06/14/18		ISSUE PRELIMINARY DESIGN DEVELOPMENT DOCUMENTS
08/17/18		ISSUE CHECK-OUT SET / PERMIT SET
10/10/18		FINAL ISSUE SUBMITTAL READY FOR PROPOSAL
11/07/18		

DOE FACILITY CODE: 660 -3066  
**RIVERWOOD HIGH SCHOOL-PHASE 3-8 AUDITORIUM / GYMNASIUM ADDITION**  
5900 RAIDER DRIVE NW SANDY SPRINGS, GA 30328  
FULTON COUNTY SCHOOLS RFP NO. 411-18

SHEET TITLE  
**EXISTING GYM FLOOR PLAN - HVAC**

PROJECT NO.  
18015.02

DATE  
09/17/18

DRAWN BY: CPAMW.D.  
CHECKED BY: BLS.

SHEET NO.

**M-1.25**