

CHAPMAN GRIFFIN LANIER SUSENBACH ARCHITECTS


FOR RELEASE OR CONSTRUCTION
SPURLOCK ASSOCIATES, INC.
2970 Clairmont Rd., Suite 420
Atlanta, GA 30329
P: 404.633.0245
F: 404.633.1756




DATE	NO.	DESCRIPTION
03/27/18		ISSUE PRELIMINARY QUANTITIES
04/18/18		ISSUE PRELIMINARY DESIGN DEVELOPMENT DOCUMENTS
04/17/18		ISSUE PRELIMINARY PERMIT SET
04/17/18		FINAL ISSUE SUBMITTAL ISSUED FOR PERMIT
11/07/18		

DOE FACILITY CODE: 660 - 3066
RIVERWOOD HIGH SCHOOL PHASE 3-8 AUDITORIUM / GYMNASIUM ADDITION
 5900 RAIDER DRIVE NW SANDY SPRINGS, GA 30328
 FULTON COUNTY SCHOOLS RFP NO. 411-19

SHEET TITLE	
THEATRICAL LIGHTING RISER DIAGRAM	
PROJECT NO.	16015.02
DATE	09/17/18
DRAWN BY	G.T.R.
CHECKED BY	B.L.S.
SHEET NO.	
E-1.33	

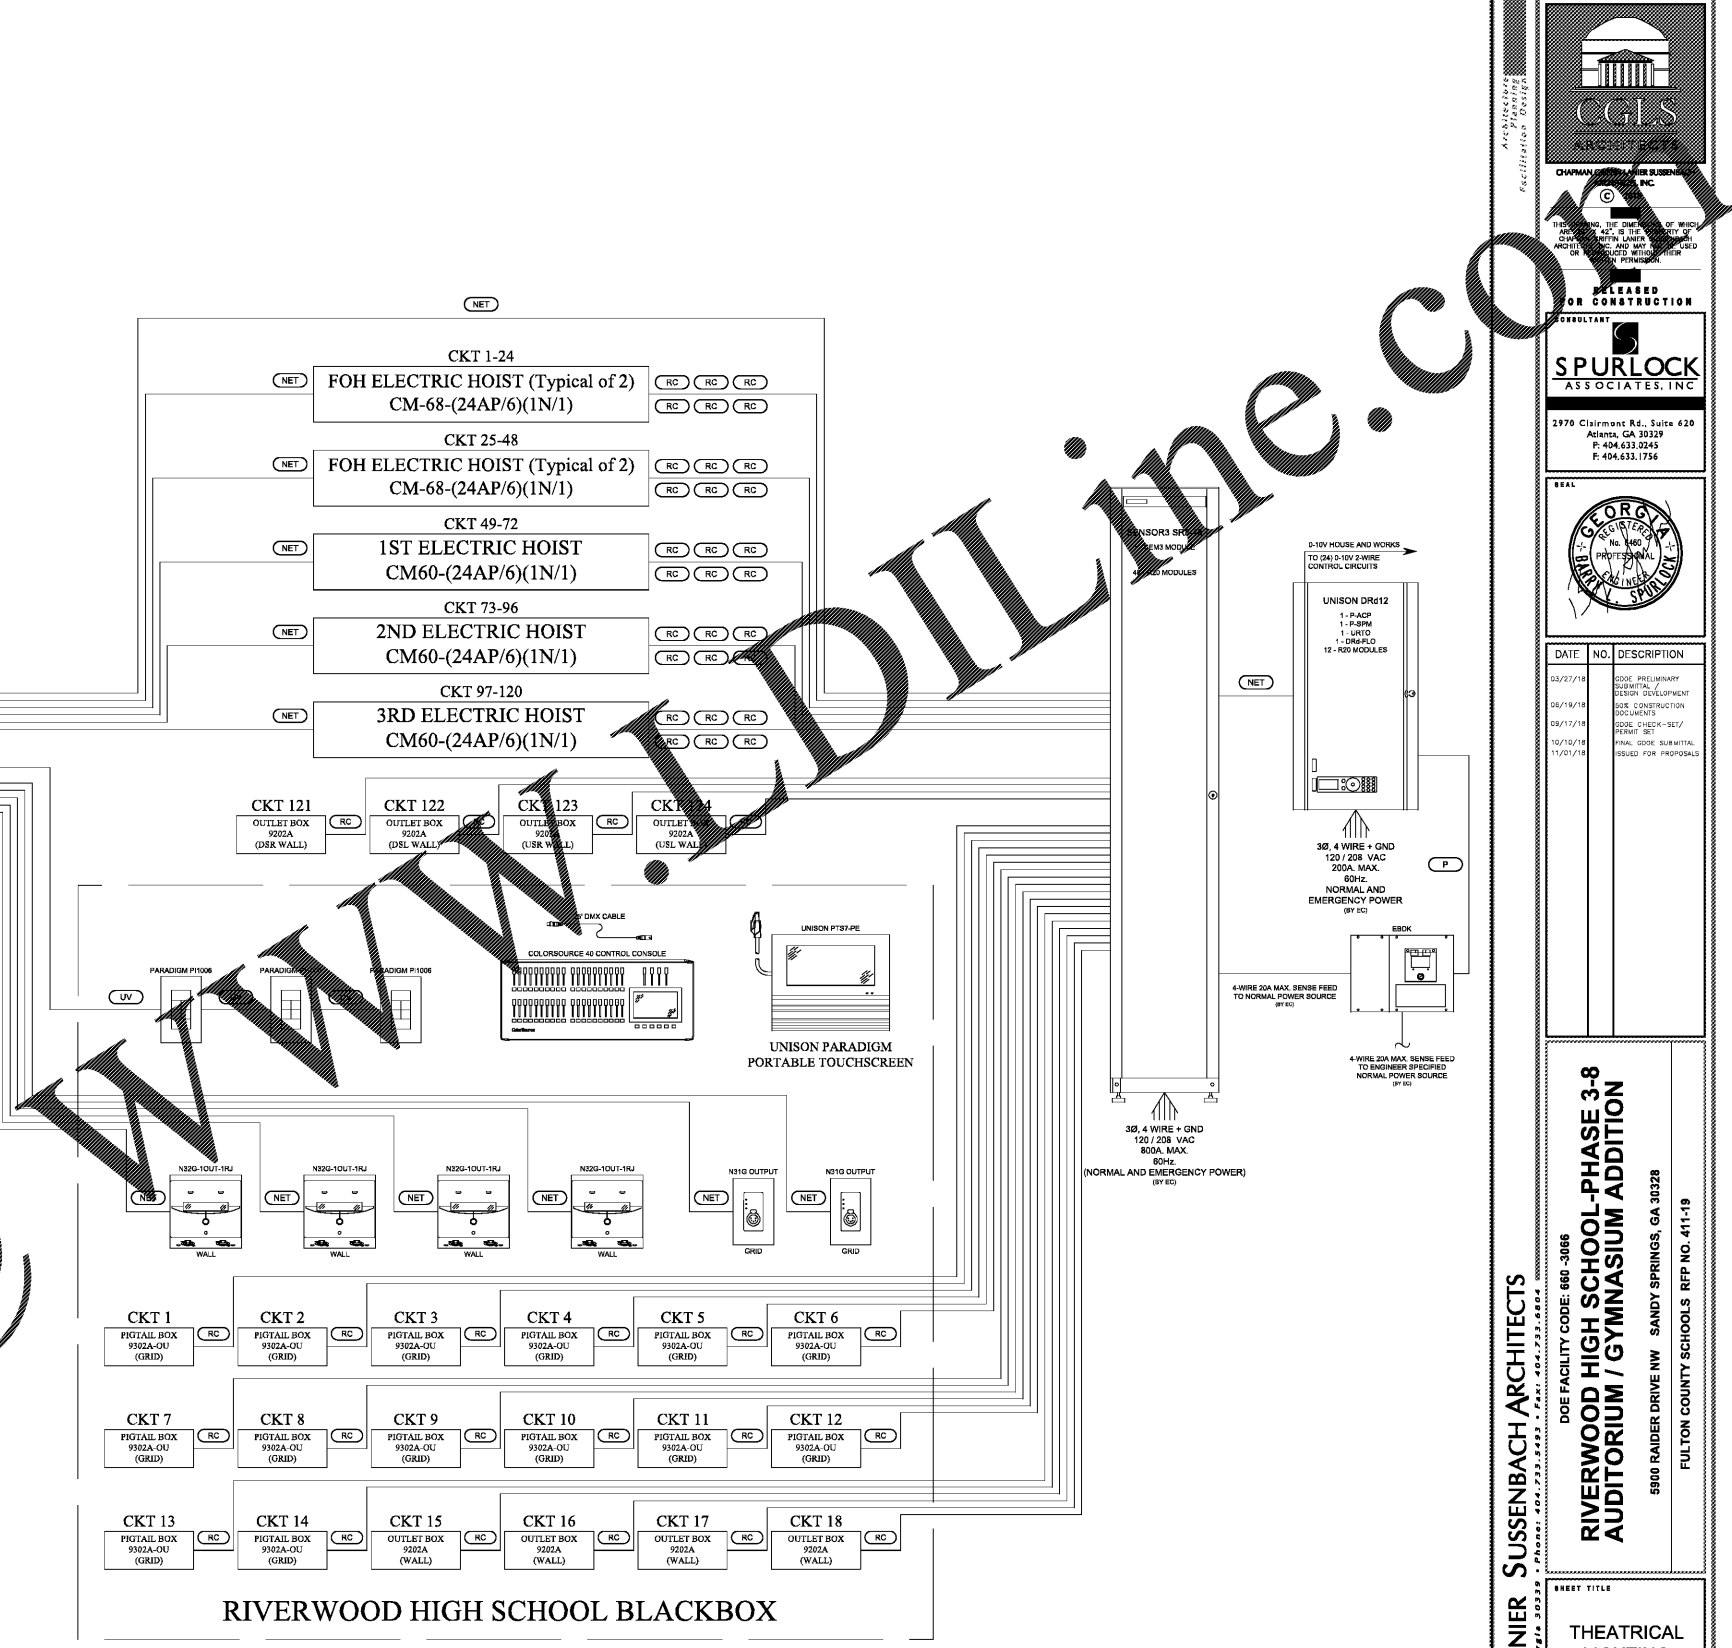

1 THEATRICAL LIGHTING RISER DIAGRAM
 E-1.33 NO SCALE

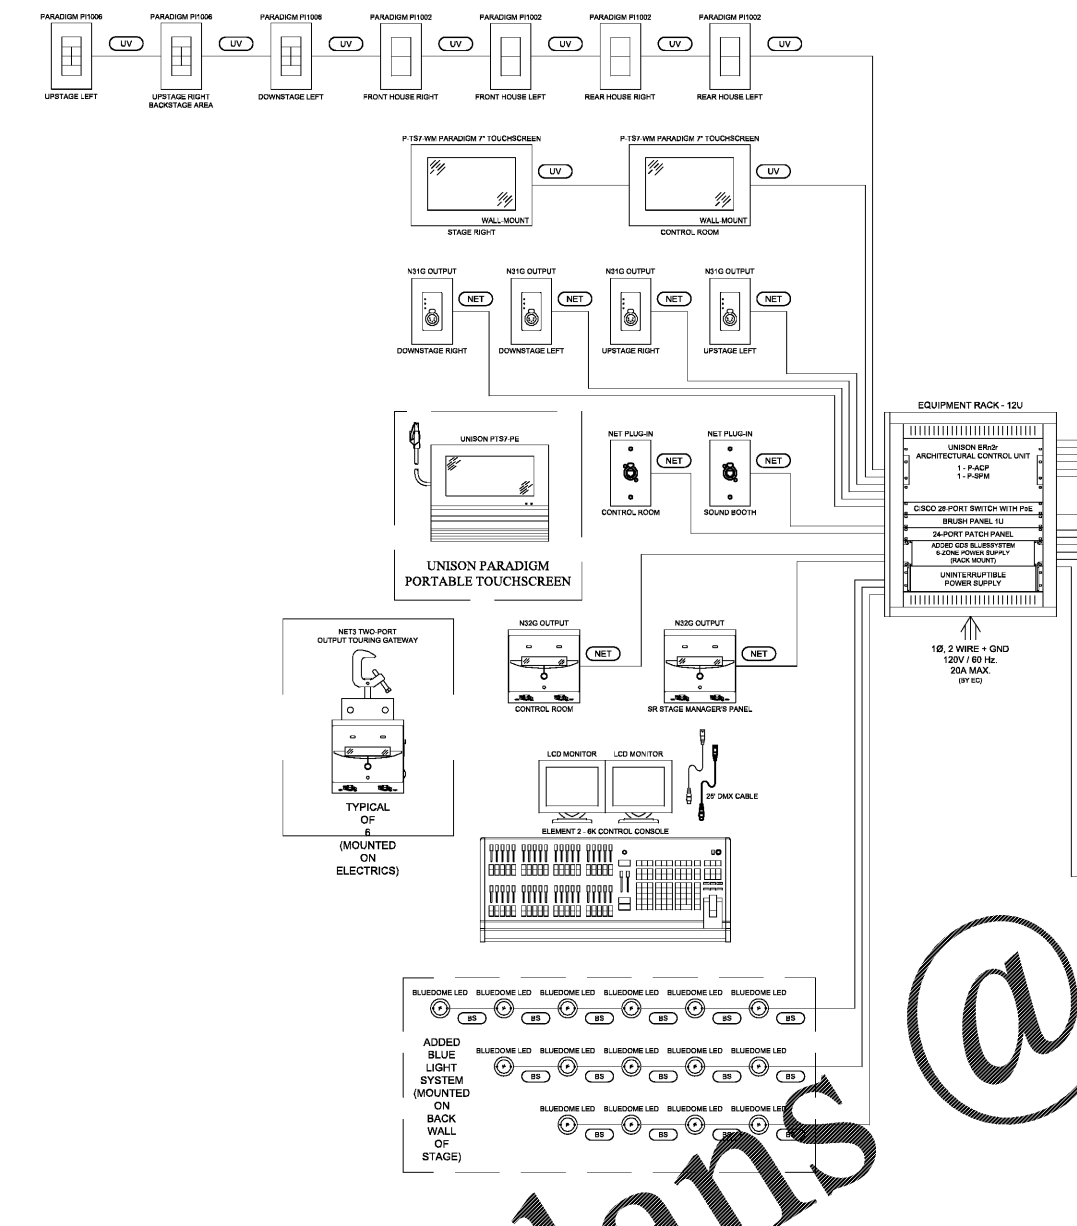

CONTROL WIRING LEGEND	NOTES
DMX (1) TMB PC244T (DMX)	1.) ALL CONTROL WIRING IS PROVIDED UNLESS NOTED OTHERWISE. 2.) ALL ETCH RUNS SHALL BE CONTINUOUS UNSPliced RUNS LESS THAN 300 FEET (90 METERS). ALL NETWORK CONNECTIONS TO BE TIA/EIA 568B. 3.) TOTAL COMBINED LENGTH OF UNISON/ECHO WIRING RUNS SHALL NOT EXCEED 1640 FEET (500 METERS). WIRING MAY BE EITHER RUN, STAR, T, OR DAISY CONNECTED.
NET (1) TMB PC244T (NET)	
UV (1) TMB PC244T (UNISON WITH #14 AWG. GND WIRE)	
P (2) #16 AWG. STRANDED WIRES (PANEL)	
BS (1) BELDEN 8489 (BLUESYSTEM CTRL. PANEL)	
DIM (1) 20A. CIRCUIT (TO SR3 DIMMING MODULE)	
RC (1) 20A. CIRCUIT (TO SR3 RELAY MODULE)	
THRU (1) 20A. CIRCUIT (TO SR3 RELAY MODULE)	

Order Plans @