


Order Plans @ WWW.LDILine.com

GENERAL NOTES

1. CENTER CEILING GRID IN ROOM UNLESS NOTED OTHERWISE
2. PROVIDE CLEAR TUBE SLEEVES OVER OPEN LIGHT FIXTURES ABOVE OPEN FOOD PREPARATION AREAS
3. ALL TRACK LIGHTING TO BE COORDINATED WITH FINAL FIXTURE AND DECOR PLACEMENT
4. CEILING TILES TO BE AC-701 UNLESS NOTED OTHERWISE, RE: SPECIFICATIONS
5. ALIGN TRACK LIGHTING WITH CEILING GRID UNLESS NOTED OTHERWISE
6. FOR LIGHTING DIMENSIONS REFER TO SHEETS E1.5.19 AND E1.5.19
7. REFER TO AS1 SERIES SHEETS FOR ARCHITECTURAL STANDARD DETAILS (ASD).
8. REFER TO SHEET 03.3 FOR EXIT SIGN LOCATIONS.

KEYNOTES

- 05-03 METAL DECK RE: STRUCTURAL DRAWINGS
- 07-07 FIBER CEMENT BOFFIT PANEL, TO MATCH SCHED.
- 10-01 PREFABRICATED PREFINISHED METAL HOOD/LUNG CANOPY
- 20-04 REFRIGERATION COIL, RE: R1-1-REFRIGERATION EQUIPMENT P
- 20-01 EXTEND FIXTURES 8" PAST EACH END OF GRAPHIC, MOUNT FIXTURE APPROXIMATELY 3" ABOVE TOP OF GRAPHIC.

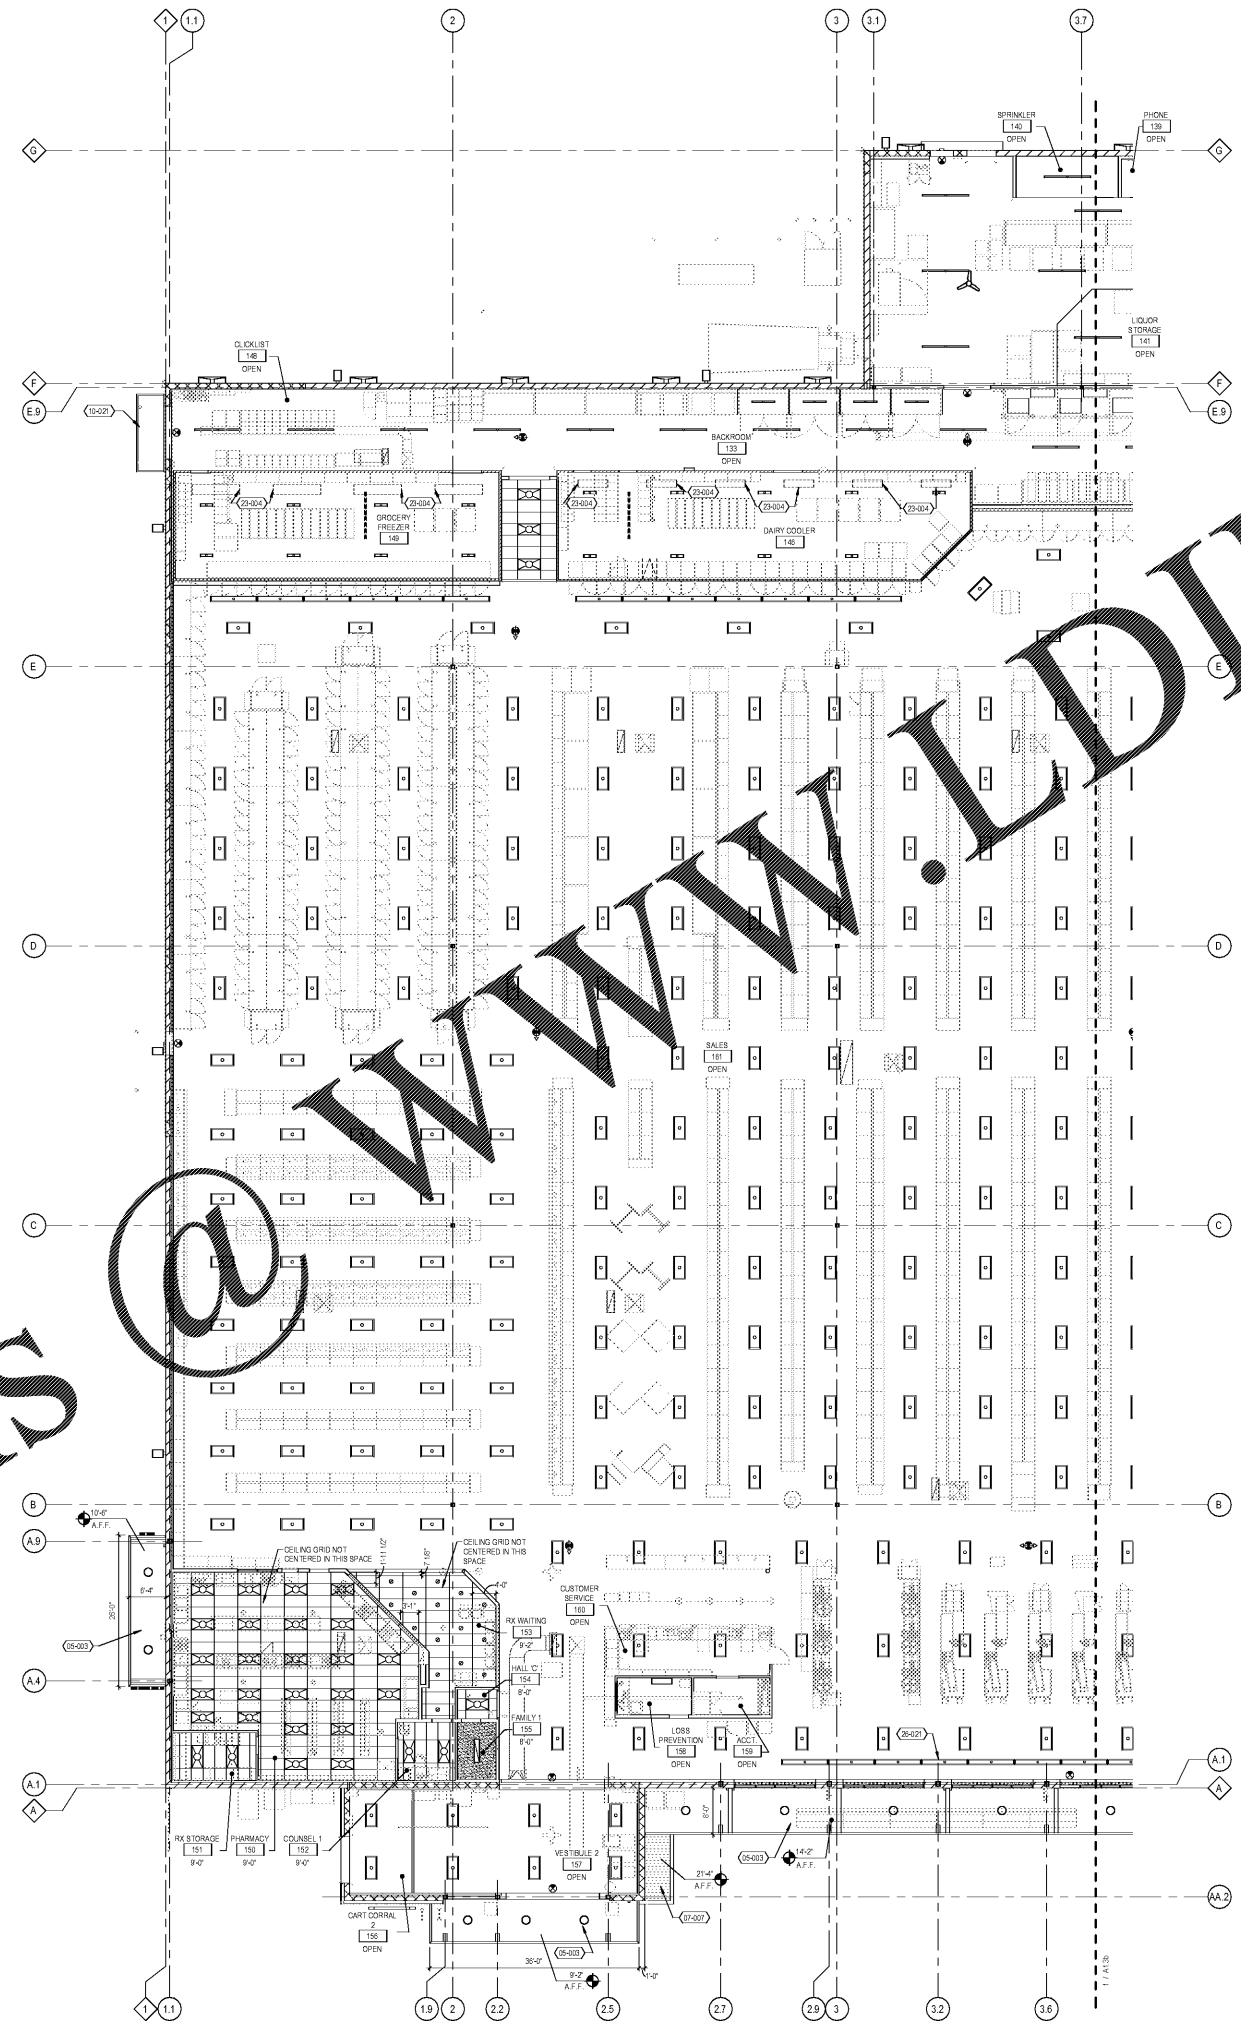

EXECUTED BY: GB
 REVIEWED BY: AF

CINCINNATI 600 W. 2nd St. #2200 Cincinnati, OH 45202 P: 513.721.8800
 DENVER 875 Broadway, Suite 1000 Denver, CO 80202 P: 303.440.4640
 DALLAS 700 Ross St. Suite 200 Dallas, TX 75202 P: 214.742.2222
 HOUSTON 2000 West Loop South, Suite 200 Houston, TX 77057 P: 281.416.6666
 SEATTLE 900 2nd Avenue, Suite 2000 Seattle, WA 98104 P: 206.466.6666

LDI architecture + design

creating extraordinary places
 www.ldi-architects.com
 800.466.4949

CONSULTANTS

OWNER

DATE: 03/10
 10/23/08 90% OWNER REVIEW
 11/01/08 100% BID PERMIT

DATE	REVISION

LEGEND

- RE: 30A1.1.1
- [Symbol] LIGHT FIXTURES, RE: ELECTRICAL DRAWINGS FOR ELECTRICAL LEGEND
 - [Symbol] LIGHT FIXTURES, RE: ELECTRICAL DRAWINGS FOR ELECTRICAL LEGEND
 - [Symbol] PHOTO LUMINESCENT EXIT SIGNAGE, F.L.L. QUADRANT INDICATES SIGN FACE, RE: SPECIFICATIONS
 - [Symbol] CEILING GRID, TYPE AS INDICATED ON PLAN
 - [Symbol] GYPSUM BOARD CEILING UNL.D. RE: ROOM FINISH SCHEDULE IN SPECIFICATIONS FOR FINISH
 - [Symbol] SOFFIT, DIRECTION AS INDICATED ON PLAN
 - [Symbol] DOOR TAG, RE: DOOR SCHEDULE, A6.1
 - [Symbol] WINDOW TAG, RE: WINDOW SCHEDULE, A5.1
 - [Symbol] MASONRY WALL
 - [Symbol] STUD WALL

PROJECT TITLE
KROGER STORE R543

1050 W. Mercury Blvd.
 Hampton, VA 23666

COMMISSION NO. 518344
 ISSUE DATE 11/01/18
 SHEET TITLE
REFLECTED CEILING PLAN - WEST

SHEET NO.
A1.3a

THIS DOCUMENT IS THE PROPERTY OF L.DI ARCHITECTS, INC. IT IS TO BE USED ONLY FOR THE PROJECT AND SITE SPECIFICALLY IDENTIFIED HEREIN. IT IS NOT TO BE REPRODUCED, COPIED, OR DISTRIBUTED IN ANY MANNER WITHOUT THE WRITTEN PERMISSION OF L.DI ARCHITECTS, INC.

11/01/18 4:01 PM