



Order Plans @

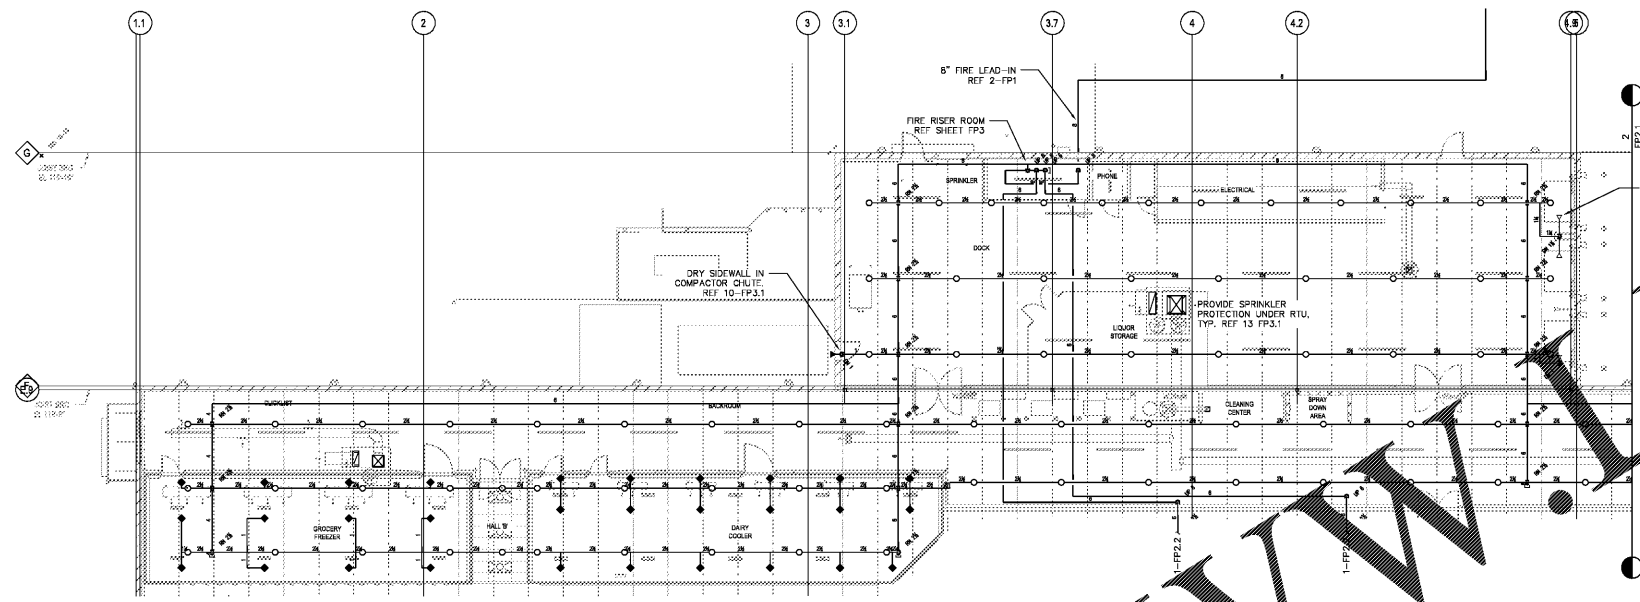


1 SPRINKLER PLAN SYSTEM 1
 SCALE: 3/32" = 1'

ALL ARM-OVER PIPING TO BE 1" SCHEDULE-40 UNLESS NOTED OTHERWISE

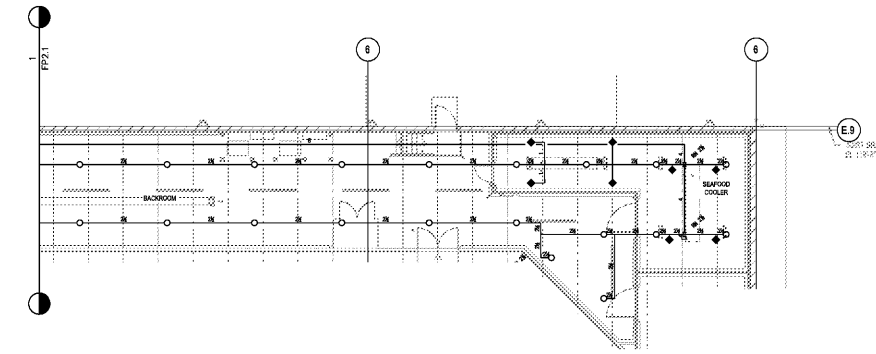

2 SPRINKLER PLAN SYSTEM 1
 SCALE: 3/32" = 1'

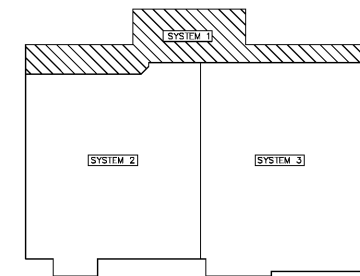

KEY PLAN
 NOT TO SCALE

WWW.LDILine.com



DRAWN BY: WDK
 REVIEWED BY: DLW



DATE: 10/23/2018
 10/23/2018
 10/23/2018

DATE REVISION

PROJECT TITLE
 KROGER STORE
 R543

1050 W. Mercury Blvd
 Hampton, VA 23666

COMMISSION NO. 518344
 ISSUE DATE 10/23/2018

SHEET TITLE
 FIRE SPRINKLER
 PLAN SYSTEM 1

SHEET NO.
 FP2.1