



Order Plans @ WWW.LDILine.com

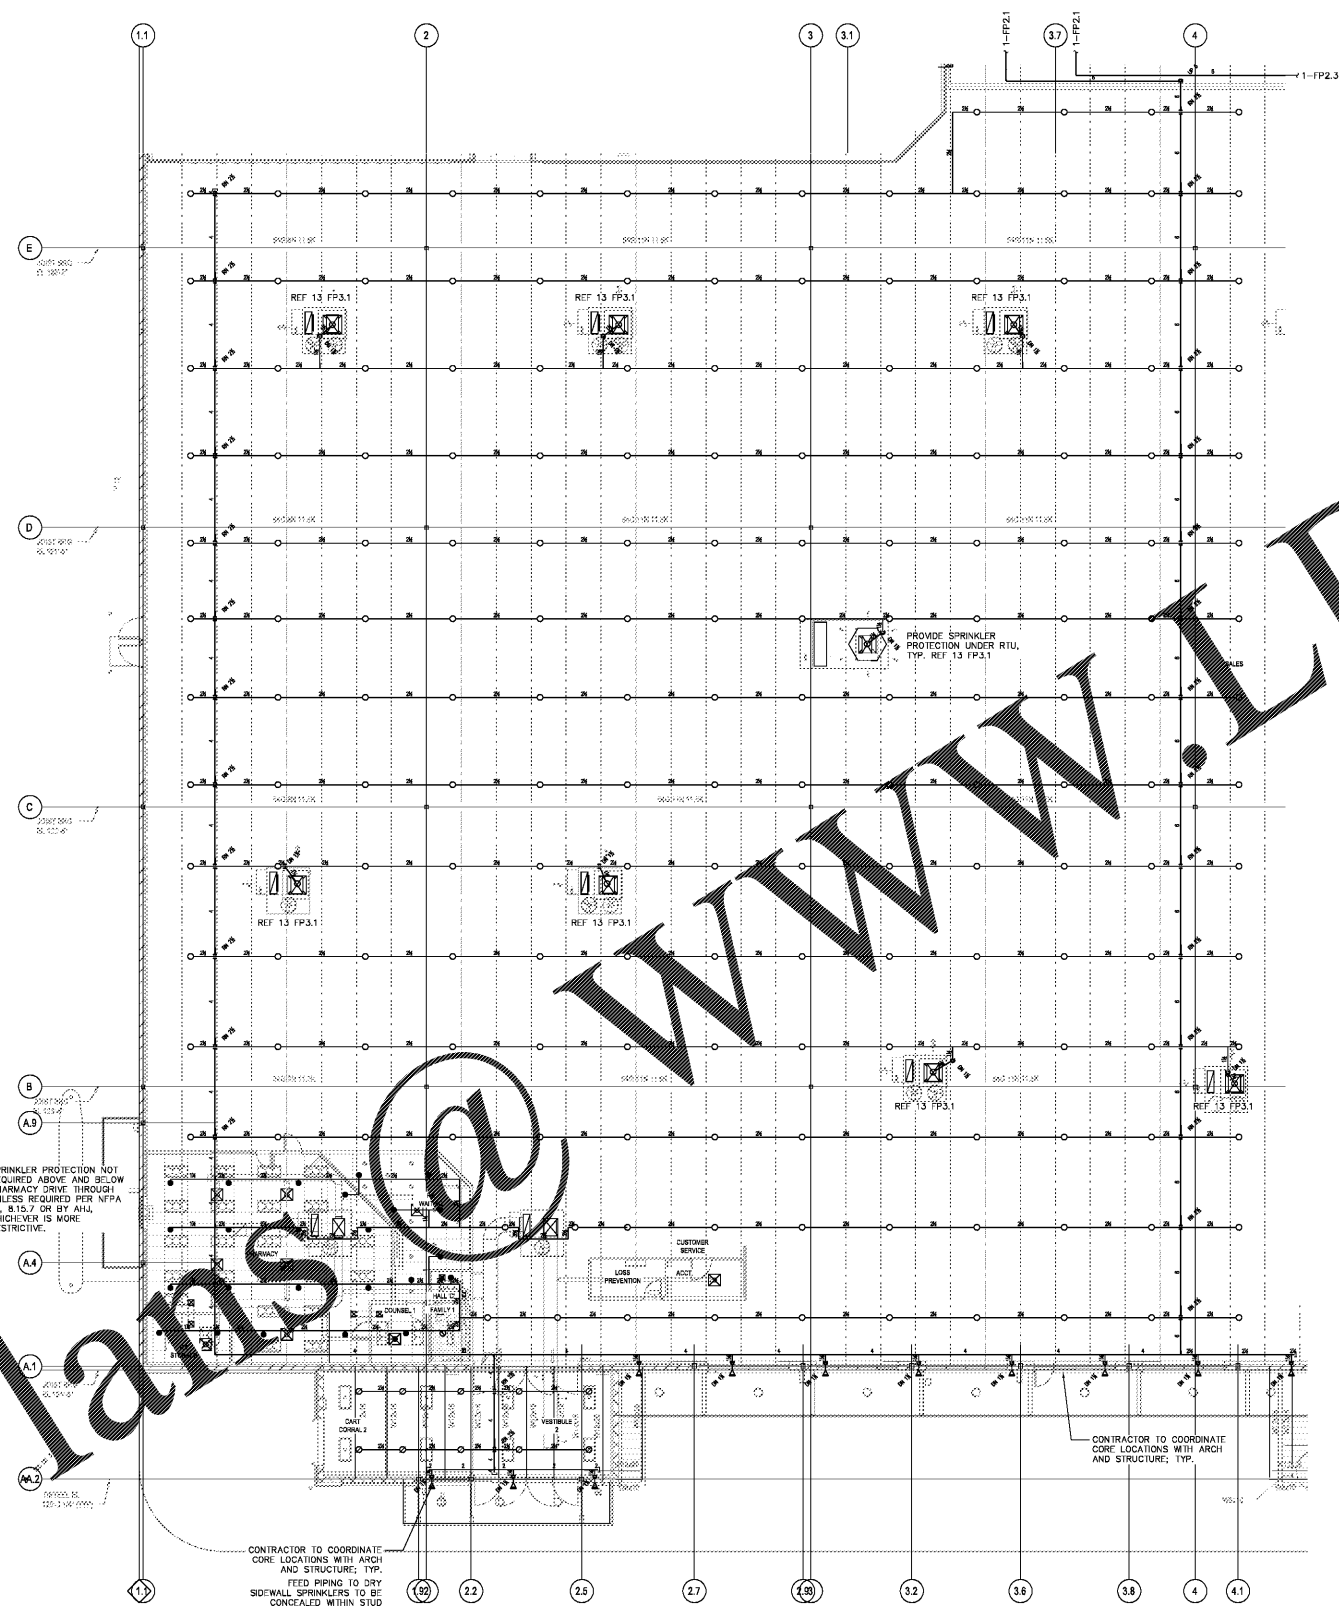

1 SPRINKLER PLAN SYSTEM 2
NOT TO SCALE


ALL ARM-OVER PIPING TO BE 1" SCHED-40 UNLESS NOTED OTHERWISE

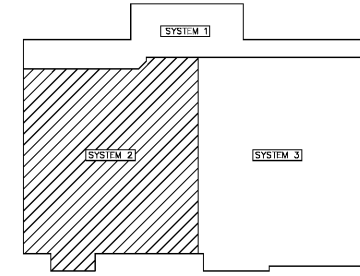

KEY PLAN
NOT TO SCALE



DRAWN BY: WJK
REVIEWED BY: DLW

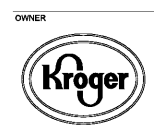

DATE: 10/23/2018
ISSUE DATE: 10/23/2018
ISSUE BY: JOK OWNER REVIEW
10/23/2018 10/23/2018

DATE: REVISION

PROJECT TITLE
KROGER STORE
R543

1050 W. Mercury Blvd
Hampton, VA 23066

COMMISSION NO: 518344
ISSUE DATE: 10/23/2018

SHEET TITLE
FIRE
SPRINKLER
PLAN
SYSTEM 2

SHEET NO.
FP2.2