



Order Plans

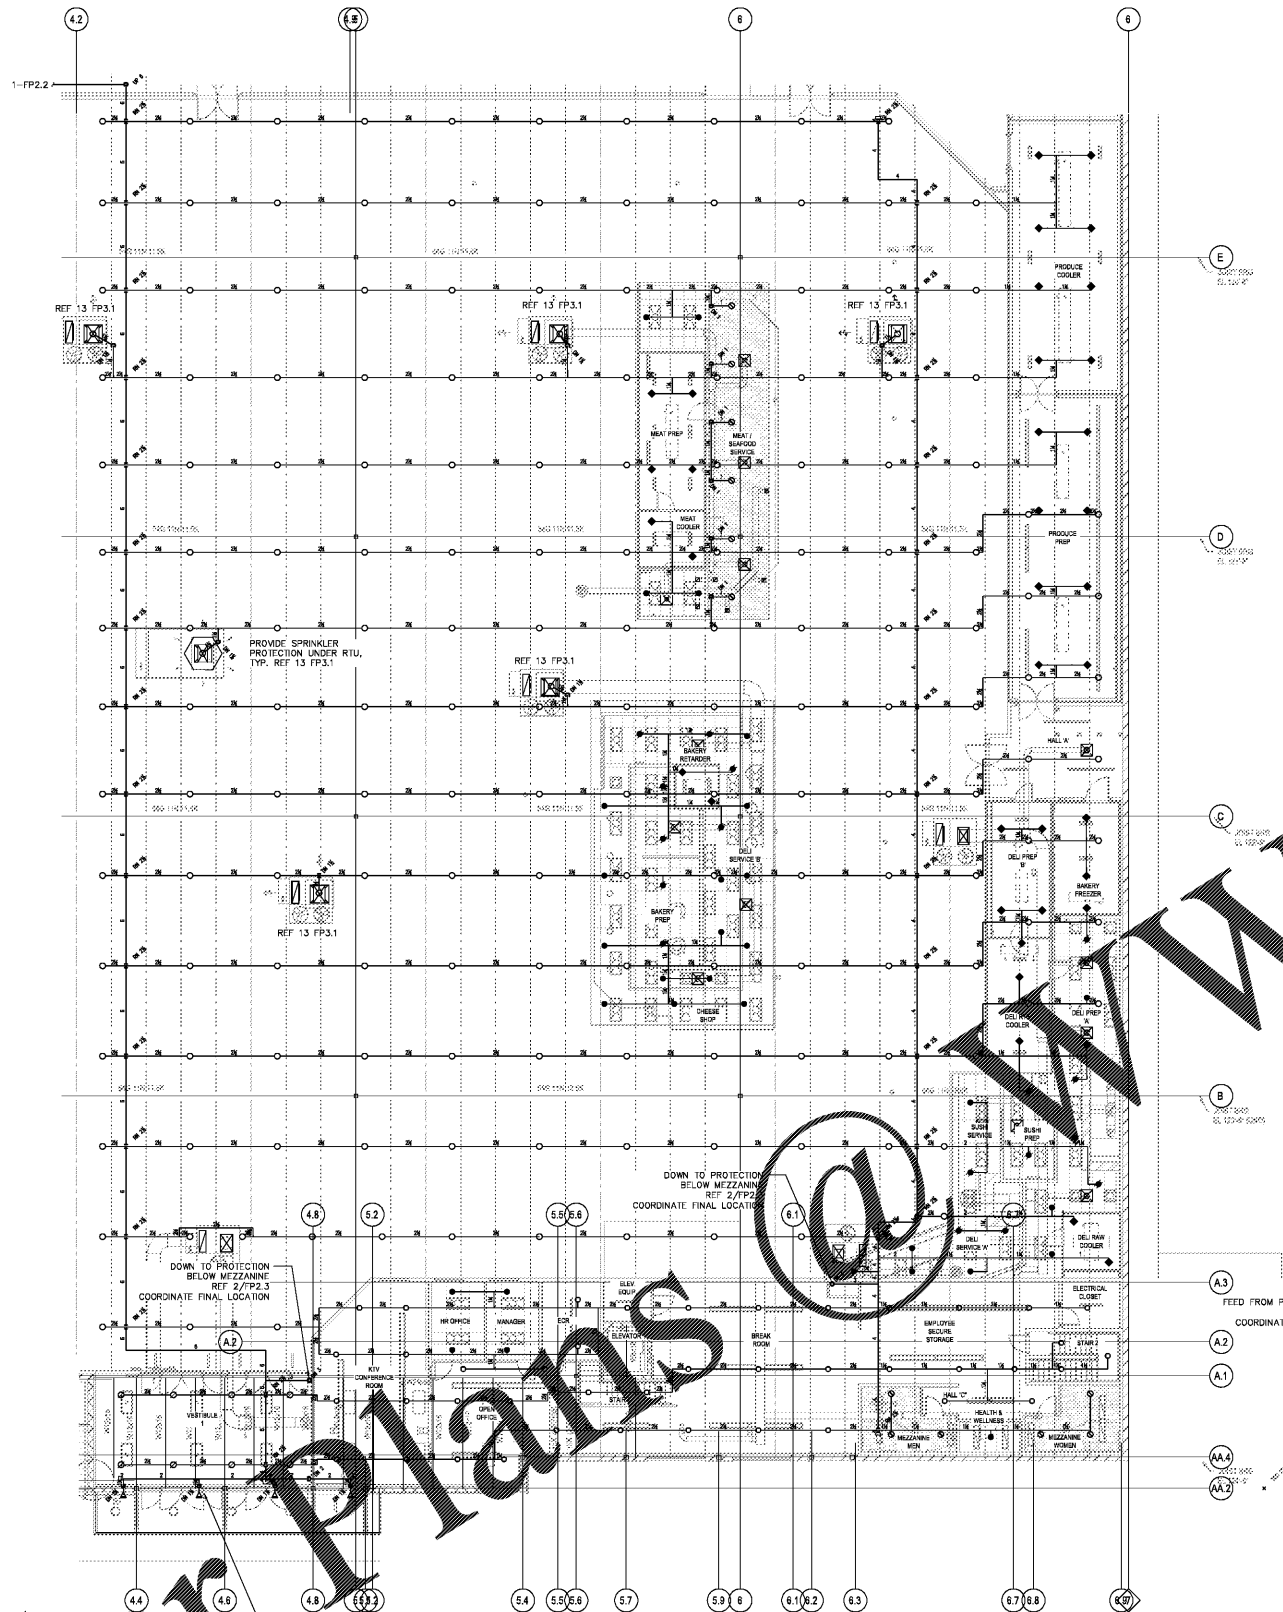


1 ROOF LEVEL SPRINKLER PLAN SYSTEM 3
SCALE: 3/32" = 1"

ALL ARM-OVER PIPING TO BE 1" SCHED-40 UNLESS NOTED OTHERWISE

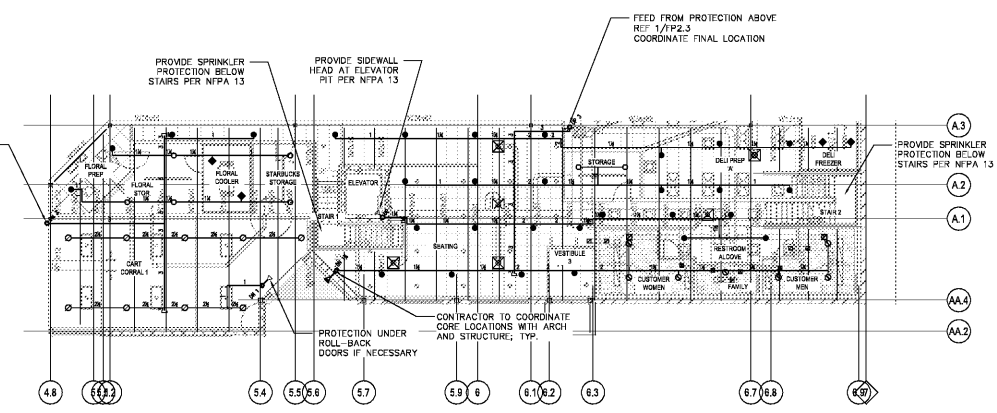

2 LOWER LEVEL SPRINKLER PLAN SYSTEM 3
SCALE: 3/32" = 1"

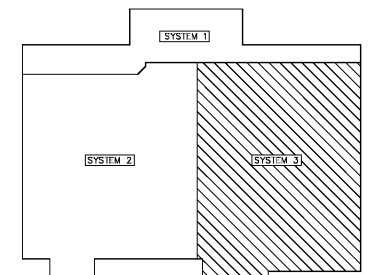


KEY PLAN
NOT TO SCALE

WWW.LDILine.com



DRAWN BY: WJK
REVIEWED BY: DLW

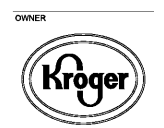

DATE: 10/23/2018
ISSUE: 06X OWNER REVIEW
10/23/2018 10/23/2018

DATE: REVISION:

PROJECT TITLE:
KROGER STORE R543

1000 W. Mainury Blvd
Hampton, VA 23666

COMMISSION NO: 518344
ISSUE DATE: 10/23/2018

SHEET TITLE:
FIRE SPRINKLER PLAN SYSTEM 3

SHEET NO:
FP2.3