


- KEYED NOTES**
- P804 4" STORM. REFER TO CIVIL SITE UTILITY PLAN FOR CONTINUATION. (TYPICAL)
 - P808 TIE THE DRAIN FROM THIS CASE INTO THE DRAIN OF A SIMILAR ADJACENT CASE ABOVE THE SLAB WITH AIR GAP.
 - P810 P.C. MUST COORDINATE THE FINAL TRENCH DRAIN LOCATIONS WITH THE FINAL COOLER BOX PLACEMENTS. INSTALLATION PRIOR TO FINAL CONCRETE POUR. THE TRENCH DRAINS MUST BE FINISHED SMOOTH, WELDABLE, AND EASILY CLEANABLE.
 - P811 REFRIGERATION FREEZER RAN COIL CONDENSATE DRAIN. PROVIDE AIR GAP.
 - P813 PROVIDE HEAT TRACE FOR CONDENSATE PIPING INSIDE OF FREEZER.
 - P814 PROVIDE TRAP GUARD, REFER TO SPECS FOR MANUFACTURER.
 - P816 4" SANITARY. REFER TO CIVIL SITE UTILITY PLAN FOR CONTINUATION.
 - P817 PROVIDE 1/2" HORIZONTAL STORM FOR 6" D.S. CONNECTION. REFER TO DETAIL ON SHEET P82. REFER TO CIVIL SITE UTILITY PLAN FOR CONTINUATION. (TYPICAL)
 - P819 NEW HUB DRAIN TO SERVE REFRIGERATED CASES. REFER TO DETAILS PSD-1 AND PSD-1PS-1 FOR INSTALLATION. (TYPICAL)
 - P822 AREA DRAIN TO SERVE VESTIBULE. REFER TO DETAIL PSD-3PS-1 FOR INSTALLATION. (TYPICAL)
 - P826 REFER TO DETAIL PSD-1PS-1 FOR FLOOR SINK INSTALLATION. (TYPICAL)
 - P827 HEAVY DUTY FLOOR DRAIN. REFER TO DETAIL PSD-1PS-1 FOR INSTALLATION. (TYPICAL)
 - P829 REFER TO DETAIL XPS-3 FOR INSTALLATION.
 - P831 REFER TO DETAIL XPS-3 FOR INSTALLATION. PROVIDE 4" HORIZONTAL STORM FOR 4" D.S. CONNECTION. REFER TO DETAIL PSD-3PS-1 FOR INSTALLATION.

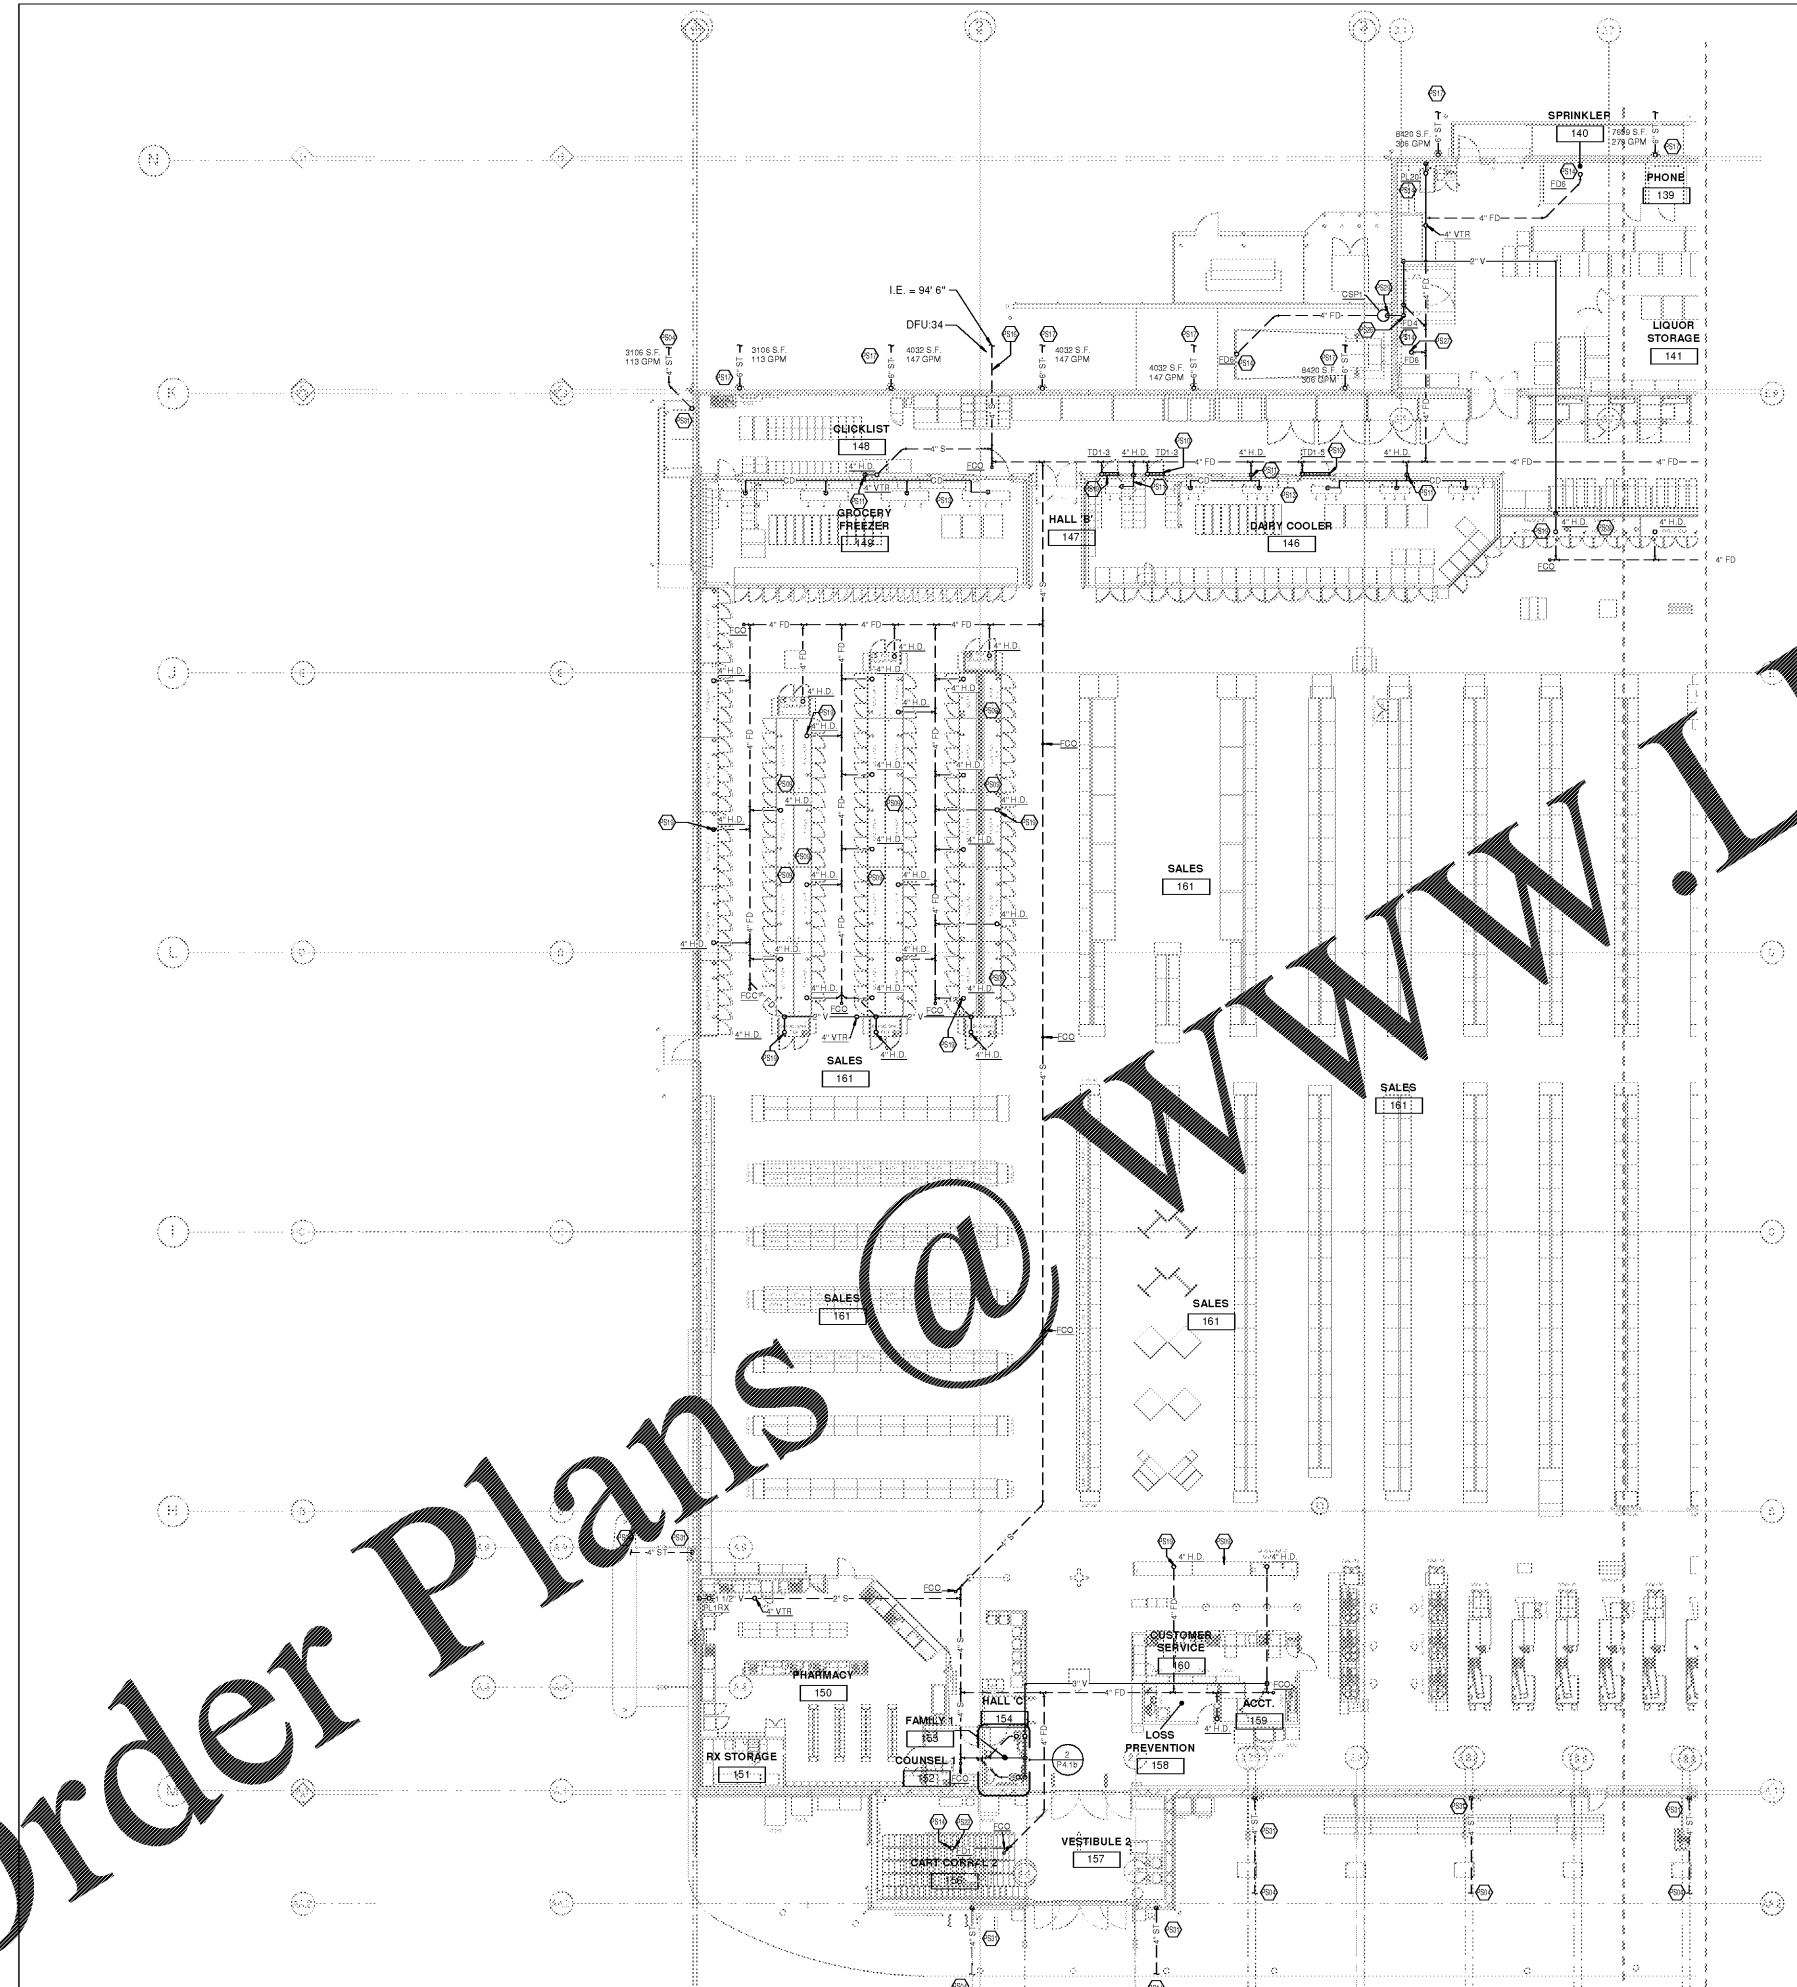

WASTE AND VENT PLAN - WEST
3/32" = 1'-0"

F.F.E. = 100'
2" REFERENCE LINE

OWNER'S USE ONLY
 CONTRACT NO. 1110218-2104-01 PM
 DATE: 10/23/2019
 SHEET: P1.1a
 PROJECT: KROGER STORE R543
 LOCATION: MERCURY BLVD, HAMPTON, VA
 ARCHITECT: CR2 architecture + design
 ENGINEER: EKLH ENGINEERS

MECHANICAL/ELECTRICAL ENGINEERS
 WWW.EKLHENGINEERS.COM
 LEWISTON, KENTUCKY
 LOUISVILLE, KENTUCKY
 NEW YORK, NEW YORK

OWNER

 DATE: 10/23/2019
 ISSUE: 5% OWNER REVIEW
 11/01/2019 100% BOPERMAT

DATE REVISION

PROJECT TITLE
KROGER STORE R543
 MERCURY BLVD.
 HAMPTON, VA
 COMMISSION NO. 517315
 ISSUE DATE 10/23/2019
 SHEET TITLE
WASTE AND VENT PLAN - WEST

SHEET NO.
P1.1a
 2019 Architectural Services, Inc.

CONSULTANTS

 creating extraordinary places
 www.cr2architects.com
 500-450-6545

CINCINNATI 600 Vine Street, Suite 200, Cincinnati, OH 45202
 DENVER 1475 Broadway, Suite 1000, Denver, CO 80202
 SEATTLE 805 2nd Avenue, Suite 1000, Seattle, WA 98104

Order Plans @ WWW.LDILine.com