




KEYED NOTES	
P514	PROVIDE TRAP GUARD, REFER TO SPECS FOR MANUFACTURER.
P530	REFER TO PSD-50/PS-2 FOR LAVATORY INSTALLATION (TYPICAL).
P536	WASTE PIPING DOWN FROM MEZZANINE, REFER TO SHEET P1-18 FOR CONTINUATION.
P538	VENT PIPING DOWN FROM MEZZANINE, REFER TO SHEET P1-18 FOR CONTINUATION.
P537	REFER TO SHEET P1-18 FOR PIPING CONTINUATION.
PW10	BRANCH ISOLATION VALVES TO BE MOUNTED AT 10'-0" A.F. UNLESS PHYSICALLY IMPOSSIBLE, IN WHICH CASE MOUNT AS CLOSE TO 10'-0" A.F. AS POSSIBLE. MAKE ACCESSIBLE AND HIDDEN FROM PUBLIC VIEW.
PW33	REFER TO PSD-50 FOR LAVATORY INSTALLATION (TYPICAL).
PW36	CAP PIPING FOR STARBUCKS CONNECTION, REFER TO SHEET DETAILS ON SHEET P2-3 AND STARBUCKS PLANS FOR PIPING LAYOUT AND INSTALLATION.
PW39	REFER TO SHEET P1-28 FOR PIPING/FIXTURE TAGS AND NOTATION.
PW40	REFER TO SHEET P1-28 FOR CONTINUATION.

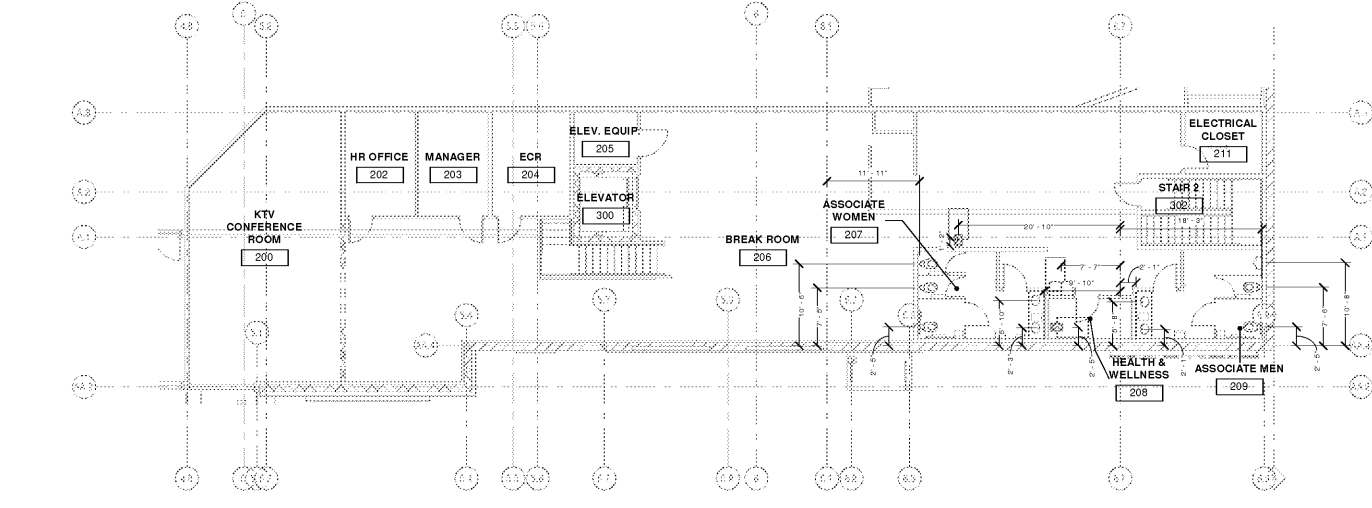

1 PLUMBING MEZZANINE DIMENSION PLAN
1/8" = 1'-0"

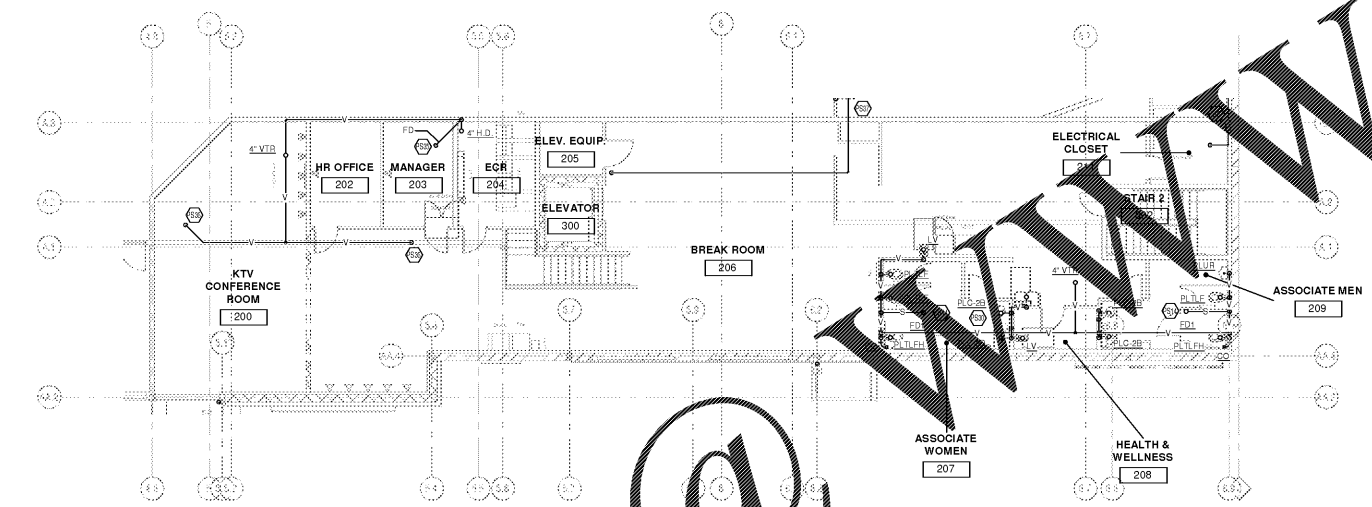

2 PLUMBING MEZZANINE WASTE AND VENT PLAN
1/8" = 1'-0"

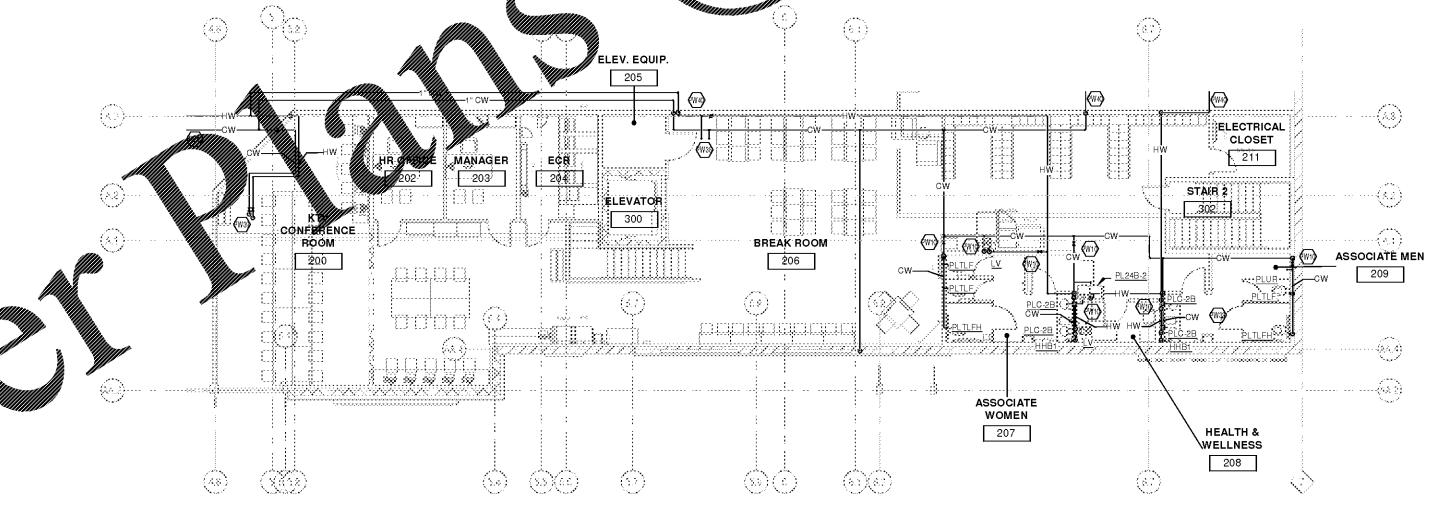

3 PLUMBING MEZZANINE DOMESTIC WATER PLAN
1/8" = 1'-0"

ORDERING OF MATERIALS OR SERVICE...
 ALL RIGHTS ARE RESERVED...
 11/10/2018 2:08:10 PM

Order Plans @ www.LDILine.com

CINCINNATI 600 Vine Street, Suite 200, Cincinnati, OH 45202
 DENVER 1875 Broadway, Suite 200, Denver, CO 80202
 CHICAGO 100 N Dearborn, Suite 400, Chicago, IL 60610
 SEATTLE 800 Stewart Street, Suite 200, Seattle, WA 98101
 TEL: 513.721.8080
 FAX: 513.721.8080
 WWW.LDILINE.COM

creating extraordinary places
 www.cr-architects.com
 502.450.4545

CONSULTANTS

MECHANICAL/ELECTRICAL ENGINEERS
 WWW.KHENGSCOM
 LEVINGTON, KENTUCKY
 LOUISVILLE, KENTUCKY
 NEW YORK, NEW YORK
 150 ALEXANDRIA PARK, SUITE 11
 FT. THOMAS, KENTUCKY 40325
 959-442-8286 FAX

OWNER

DATE	ISSUE
10/25/18	50% OWNER REVIEW
11/01/18	100% BOP/PERMIT

DATE	REVISION

PROJECT TITLE
KROGER STORE R543
 MERCURY BLVD.
 HAMPTON, VA
 COMMISSION NO. 517315
 ISSUE DATE 10/23/2018
 SHEET TITLE
PLUMBING MEZZANINE PLAN

SHEET NO.
P1.5
 2018 AECOM/CR/ALP/STP/VA

2" REFERENCE LINE