


ORDERING OF MATERIALS AND SERVICES: All items, items, specifications, quantities, and prices are subject to change without notice. The Consultant is not responsible for the accuracy of the information provided by the Contractor. The Consultant is not responsible for the accuracy of the information provided by the Contractor. The Consultant is not responsible for the accuracy of the information provided by the Contractor.

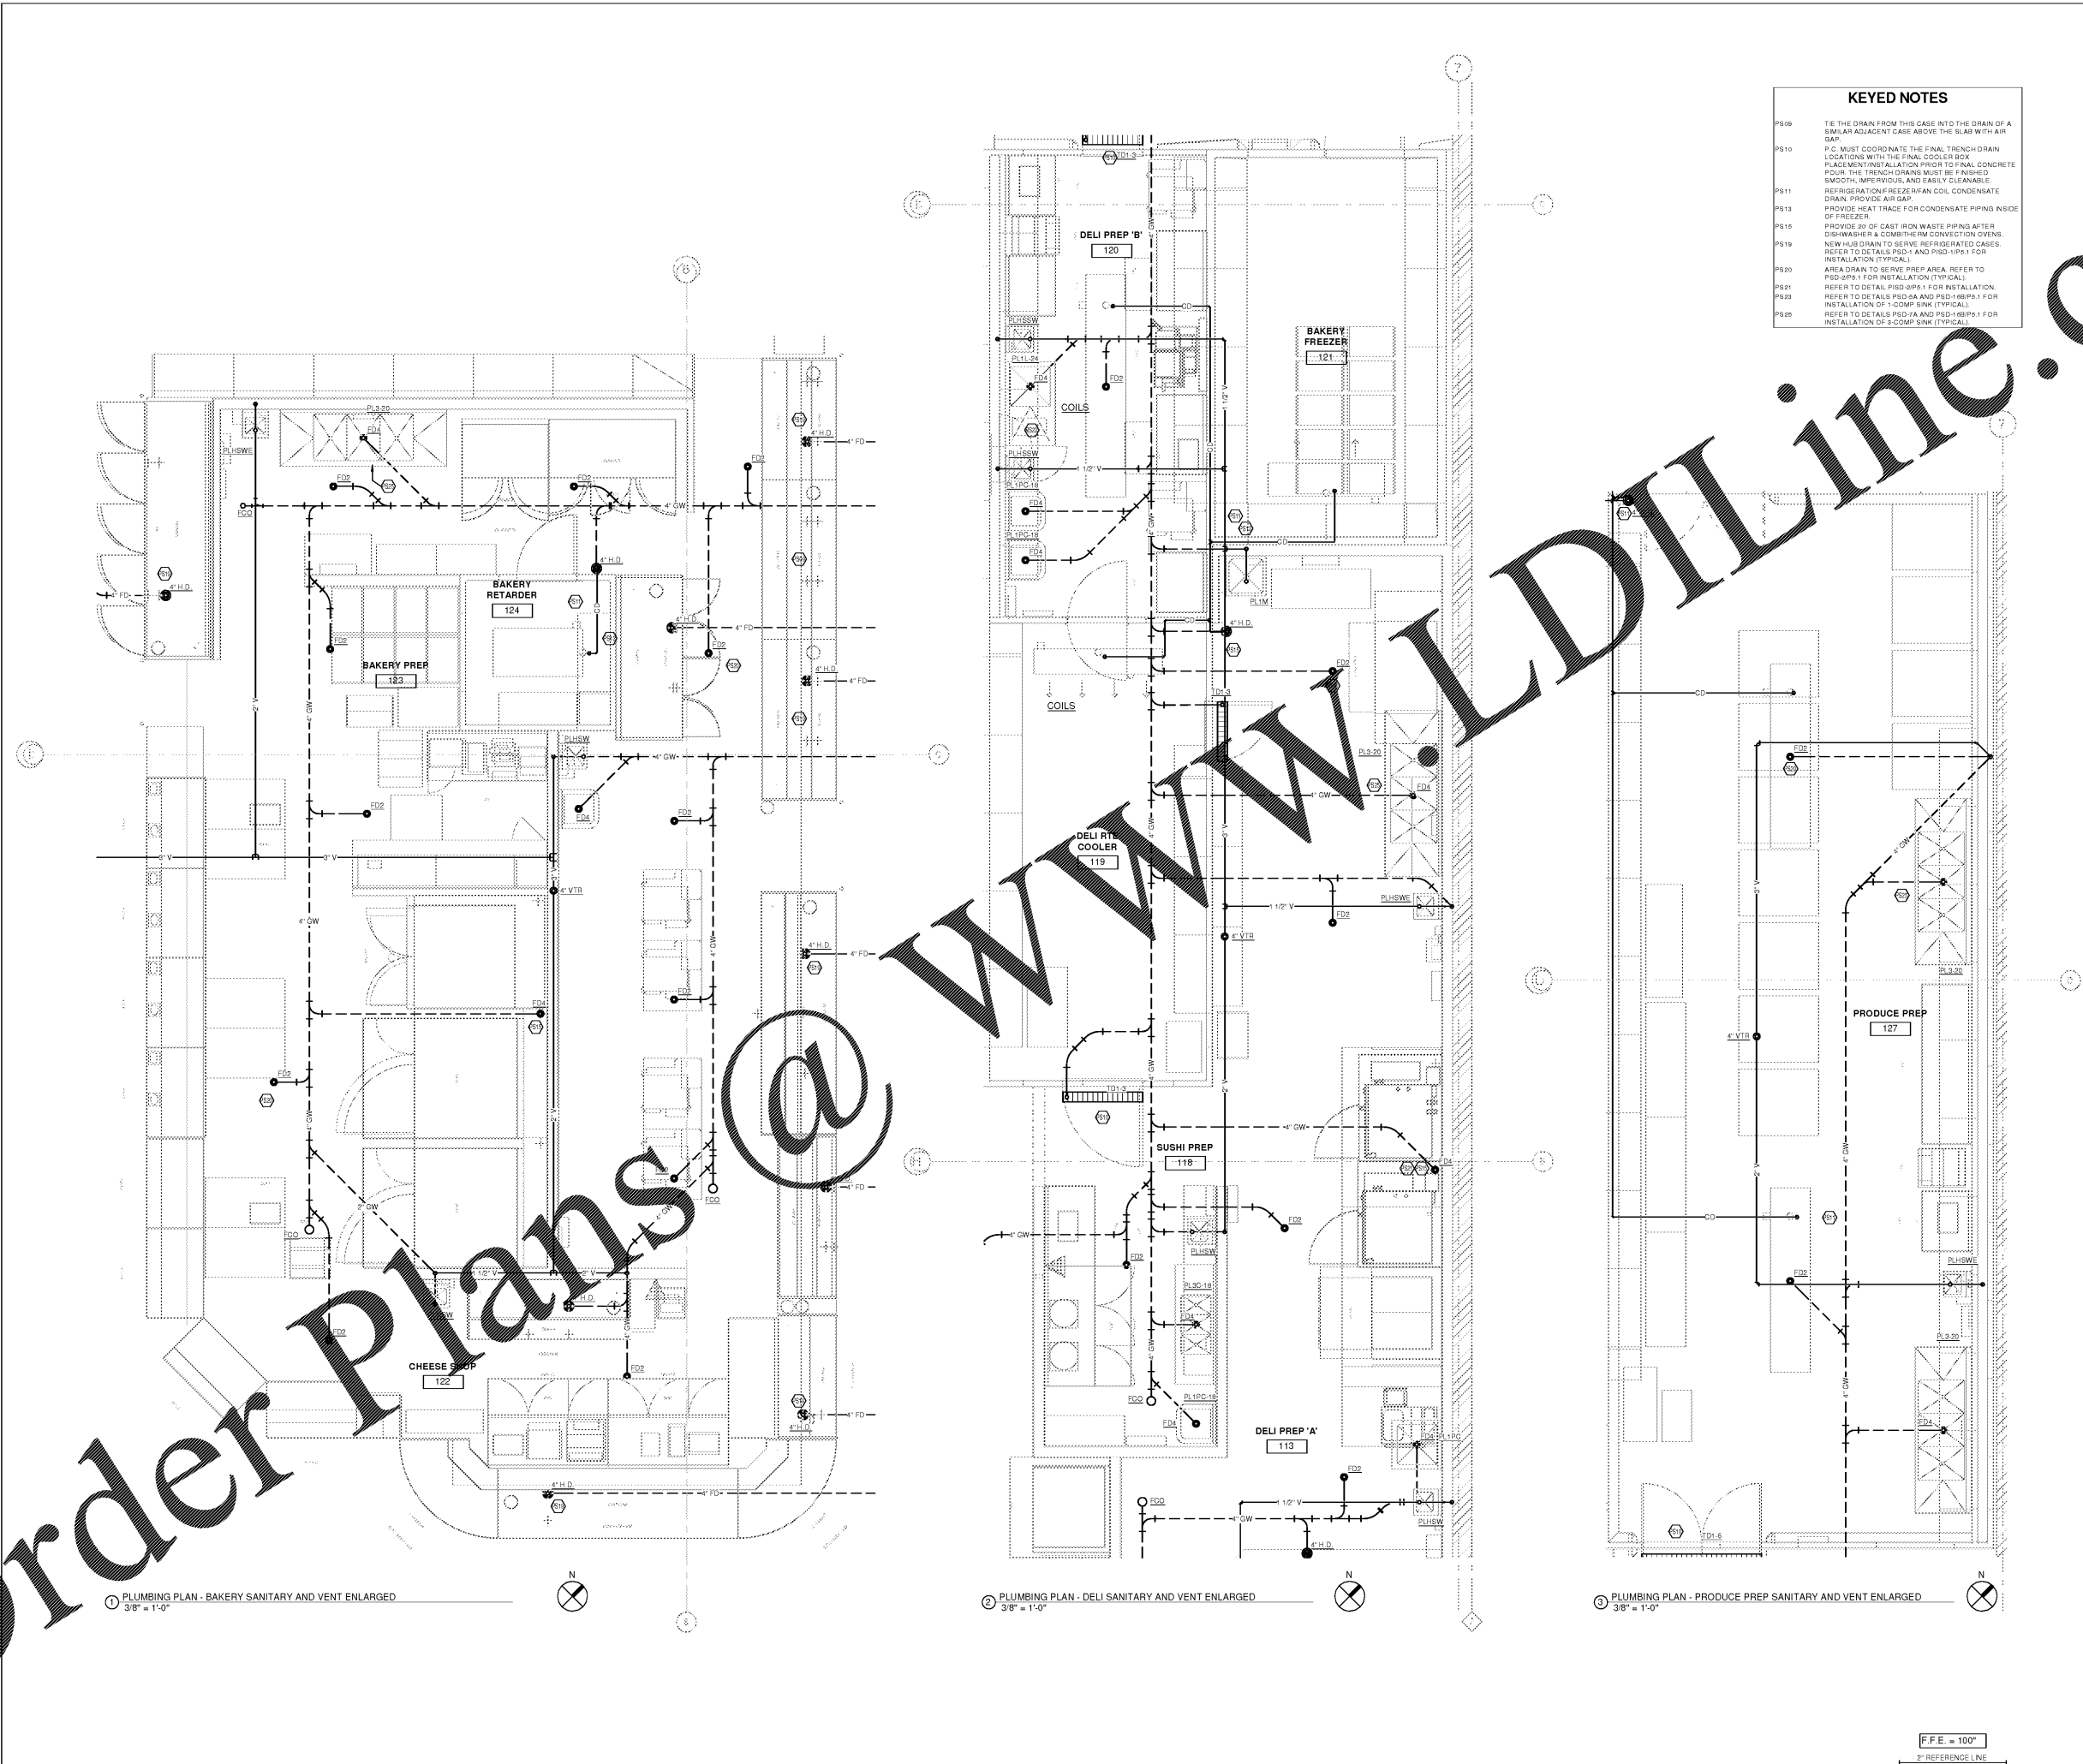

- KEYED NOTES**
- PS99 TIE THE DRAIN FROM THIS CASE INTO THE DRAIN OF A SIMILAR ADJACENT CASE ABOVE THE SLAB WITH AIR GAP.
 - PS10 P.C. MUST COORDINATE THE FINAL TRENCH DRAIN LOCATIONS WITH THE FINAL COOLER BOX. PLACEMENT INSTALLATION PRIOR TO FINAL CONCRETE POUR. THE TRENCH DRAINS MUST BE FINISHED SMOOTH, WETTED, AND EASILY CLEANABLE.
 - PS11 REFRIGERATION FREEZER/FAN COIL CONDENSATE DRAIN. PROVIDE AIR GAP.
 - PS13 PROVIDE HEAT TRACE FOR CONDENSATE PIPING INSIDE OF FREEZER.
 - PS10 PROVIDE 3/4" OF CAST IRON WASTE PIPING AFTER DISHWASHER & COMBI/HEM CONVECTION OVENS. NEW HUD DRAIN TO SERVE REFRIGERATED CASES. REFER TO DETAILS PSD-9 AND PSD-10 FOR INSTALLATION (TYPICAL).
 - PS19 AREA DRAIN TO SERVE FREEZER AREA. REFER TO PSD-9 & 1 FOR INSTALLATION (TYPICAL).
 - PS20 REFER TO DETAIL PSD-9 & 1 FOR INSTALLATION. REFER TO DETAILS PSD-9 AND PSD-10 FOR INSTALLATION OF 1-COMP SINK (TYPICAL).
 - PS21 REFER TO DETAILS PSD-9 AND PSD-10 FOR INSTALLATION OF 2-COMP SINK (TYPICAL).
 - PS22 REFER TO DETAILS PSD-9 AND PSD-10 FOR INSTALLATION OF 3-COMP SINK (TYPICAL).

1 PLUMBING PLAN - BAKERY SANITARY AND VENT ENLARGED
3/8" = 1'-0"

2 PLUMBING PLAN - DELI SANITARY AND VENT ENLARGED
3/8" = 1'-0"

3 PLUMBING PLAN - PRODUCE PREP SANITARY AND VENT ENLARGED
3/8" = 1'-0"

F.F.E. = 100'
2" REFERENCE LINE

CONSULTANTS
CR
 architecture + design
 creating extraordinary places
 www.cr-architects.com
 800-450-6842
 CHICAGO: 600 West Superior, Suite 1000, Chicago, IL 60611
 DENVER: 1475 Broadway, Suite 1000, Denver, CO 80202
 MIAMI: 1101 Brickell Avenue, Suite 1000, Miami, FL 33131
 SEATTLE: 800 Stewart Street, Suite 1000, Seattle, WA 98101

MECHANICAL/ELECTRICAL ENGINEERS
 WWW.KHENGERS.COM
EXEKH
 ENGINEERS
 150 ALEXANDRIA PARK SUITE 11
 FT. THOMAS, KENTUCKY 40321
 502-442-8255
 502-442-8256 FAX
 NEW YORK, NEW YORK

OWNER

 DATE: 10/22/18
 ISSUE: 11/15/2018
 50% OWNER REVIEW
 100% BOPERMAT

DATE	REVISION

PROJECT TITLE
KROGER STORE R543
 MERCURY BLVD.
 HAMPTON, VA

COMMISSIONING: 5/17/15
 ISSUE DATE: 10/23/2018
 SHEET TITLE
ENLARGED PLUMBING PLANS - WASTE AND VENT

SHEET NO.
P4.1a
 ©2018 Architectural & Mechanical, Inc.

Order Plans @

WWW.LDILine.com