



OWNERSHIP OF INSTRUMENTS OF SERVICE  
 All rights, claims, specifications, copyright, and other reserved rights, including without limitation, the copyright, in the drawings, documents and information provided by the Consultant are instruments of service and shall remain the property of the Consultant. No part of these drawings, documents and information may be reproduced, stored in a retrieval system, or transmitted in any form or by any means, electronic, mechanical, photocopying, recording, or by any information storage and retrieval system, without the prior written permission of the Consultant. The Consultant shall not be liable for any damages, including consequential damages, arising out of the use of these drawings, documents and information. The Consultant shall not be liable for any damages, including consequential damages, arising out of the use of these drawings, documents and information. The Consultant shall not be liable for any damages, including consequential damages, arising out of the use of these drawings, documents and information.

11/10/2018 2:08:27 PM

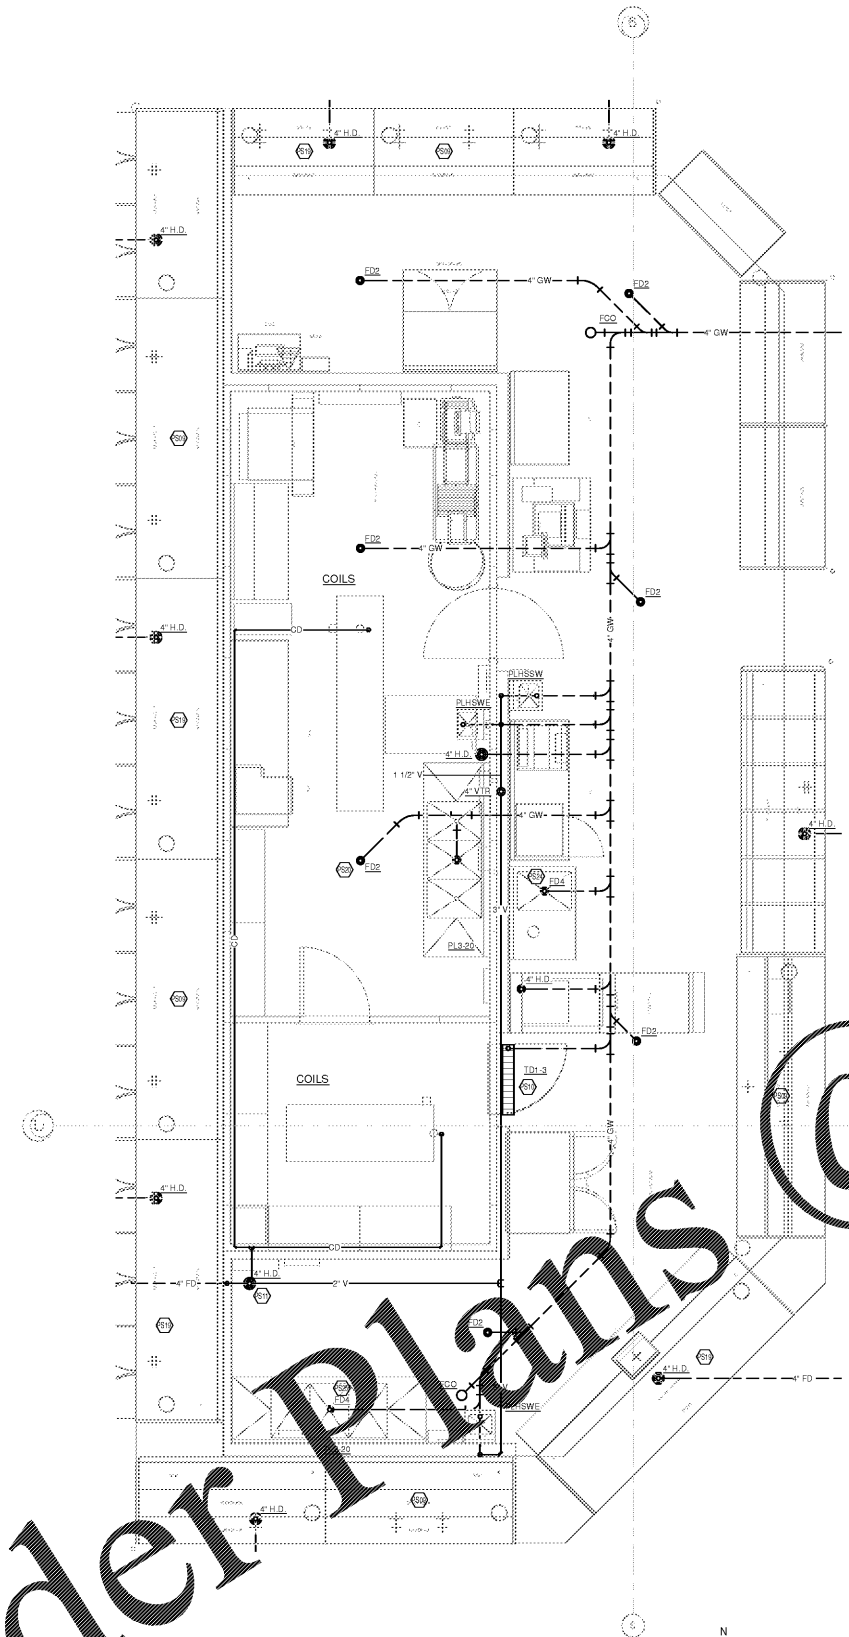

PLUMBING PLAN - MEAT/SEAFOOD SANITARY AND VENT ENLARGED  
 3/8" = 1'-0"

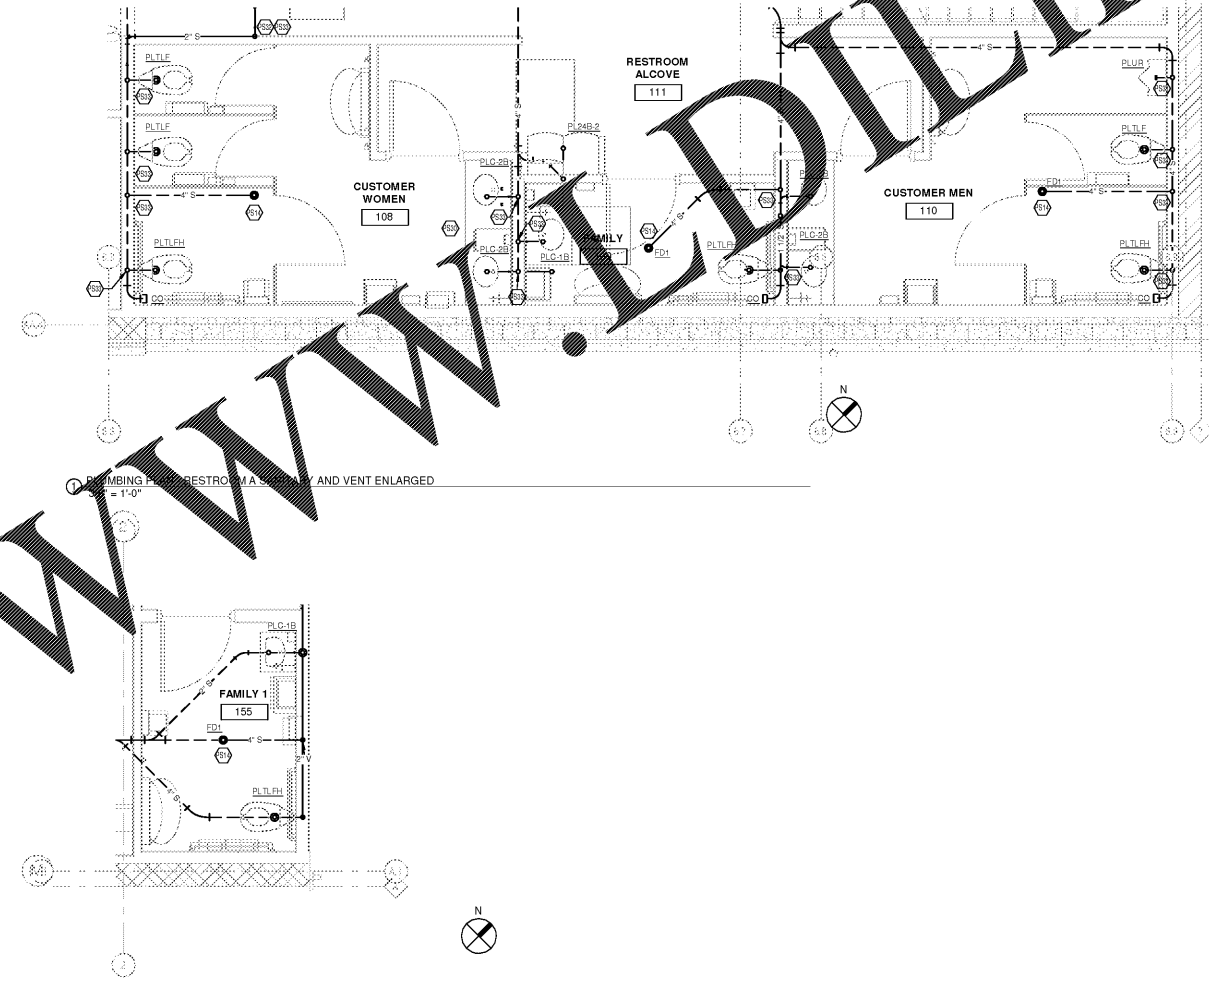

PLUMBING PLAN - RESTROOM B SANITARY AND VENT ENLARGED  
 3/8" = 1'-0"

**KEYED NOTES**

- PS09 TIE THE DRAIN FROM THIS CASE INTO THE DRAIN OF A SIMILAR ADJACENT CASE ABOVE THE SLAB WITH AIR GAP.
- PS10 P.C. MUST COORDINATE THE FINAL TRENCH DRAIN LOCATIONS WITH THE FINAL COOLER BODY PLACEMENT/INSTALLATION PRIOR TO FINAL CONCRETE POUR. THE TRENCH DRAINS MUST BE FINISHED SMOOTH, IMPERVIOUS, AND EASILY CLEANABLE.
- PS11 REFRIGERATION/FREEZER/AN COIL CONDENSATE DRAIN, PROVIDE AIR GAP.
- PS14 PROVIDE TRAP GUARD, REFER TO SPECS FOR MANUFACTURER.
- PS19 NEW HUB DRAIN TO SERVE REFRIGERATED CASES. REFER TO DETAILS PSD-1 AND PSD-1PS-1 FOR INSTALLATION (TYPICAL).
- PS20 AREA DRAIN TO SERVE F'REP AREA. REFER TO PSD-SP-1 FOR INSTALLATION (TYPICAL).
- PS24 REFER TO DETAILS PSD-AS AND PSD-1BPS-1 FOR INSTALLATION OF 80#FOOD SINK.
- PS25 REFER TO DETAILS PSD-7A AND PSD-1BPS-1 FOR INSTALLATION OF 3 COMP SINK (TYPICAL).
- PS30 REFER TO PSD-5PS-2 FOR LAVATORY INSTALLATION (TYPICAL).
- PS32 WASTE PIPING UP TO MEZZANINE. REFER TO SET FOR CONTINUATION.
- PS33 VENT PIPING UP TO MEZZANINE. REFER TO SET FOR CONTINUATION.

F.F.E. = 100"  
 2" REFERENCE LINE

Order Plans @

WWW.LDILine.com

**CR**  
 architecture + design  
 creating extraordinary places  
 www.cr-architects.com  
 800-490-6848

CONSULTANTS

**MECHANICAL ELECTRICAL ENGINEERS**  
 WWW.KHENGERS.COM  
**KLH ENGINEERS**  
 150 ALEXANDRIA PKWY SUITE 11  
 LOUISVILLE, KENTUCKY 40224  
 502-442-8256  
 502-442-8256 FAX

OWNER

**Kroger**

DATE	REVISION
10/25/2018	5% OWNER REVIEW
11/01/2018	100% B/PERMIT

PROJECT TITLE  
**KROGER STORE R543**

MERCURY BLVD.  
 HAMPTON, VA

COMMISSION NO. 517315  
 ISSUE DATE 10/23/2018  
 SHEET TITLE  
**ENLARGED PLUMBING PLANS - WASTE AND VENT**

SHEET NO.  
**P4.1b**  
 2009 Architecture + Design, Inc.