

- KEYED NOTES**
- PW09 HW DOWN COORDINATE WITH REFRIGERATION PFE DROPS. REFER TO DETAIL PSD-41.
 - PW10 BRANCH ISOLATION VALVES TO BE MOUNTED AT 10'6" A.F.F. UNLESS PHYSICALLY IMPOSSIBLE. IN WHICH CASE MOUNT AS CLOSE TO 10'6" A.F.F. AS POSSIBLE. MAKE ACCESSIBLE AND HIDDEN FROM PUBLIC VIEW.
 - PW12 ROUTE HW PIPING ALONG THE TOP OF CASES TO HMB2. CONTRACTOR SUPPLIED FILTER (3M TWIN MANFOLD FILTER SYSTEM FOR MULTIPLE SINGLE MANFOLD FOR SINGLE FIXTURE) FOR ADJACENT FIXTURE. MUST BE MOUNTED 1" BELOW FINISHED CEILING OR EXHAUST HOOD, IN AN ACCESSIBLE LOCATION. REFER TO FIXTURE CONNECTION SCHEDULE FOR FIXTURE FILTER REQUIREMENTS. REFER TO PSD-43 ON SHEET P4-1.
 - PW28 REFER TO DETAIL PSD-2A FOR INSTALLATION OF 1-COMP SINK (TYPICAL).
 - PW30 REFER TO DETAIL PSD-7A FOR INSTALLATION OF 3-COMP SINK (TYPICAL).
 - PW32 REFER TO DETAIL PSD-43 FOR OVEN PIPING INSTALLATION.

CR
 architecture + design
 creating extraordinary places
 www.cr-architects.com
 502-492-6842

CONSULTANTS

MECHANICAL/ELECTRICAL ENGINEERS
 WWW.KHENGERS.COM
 LEVINGTON, KENTUCKY
 LOUISVILLE, KENTUCKY
 NEW YORK, NEW YORK

SEKHLH ENGINEERS
 150 ALEXANDRIA PIKE, SUITE 11
 FT. THOMAS, KENTUCKY 40310
 909-442-8286 FAX

OWNER


Kroger

DATE	ISSUE
10/25/2018	5% OWNER REVIEW
11/01/2018	100% BOPERMAT

PROJECT TITLE
KROGER STORE R543
 MERCURY BLVD.
 HAMPTON, VA

COMMISSION NO. 517315
 ISSUE DATE 10/23/2018
 SHEET TITLE
ENLARGED PLUMBING PLANS - WATER

SHEET NO.
P4.2a
 2018 Addendum 2/2/2018, V.0

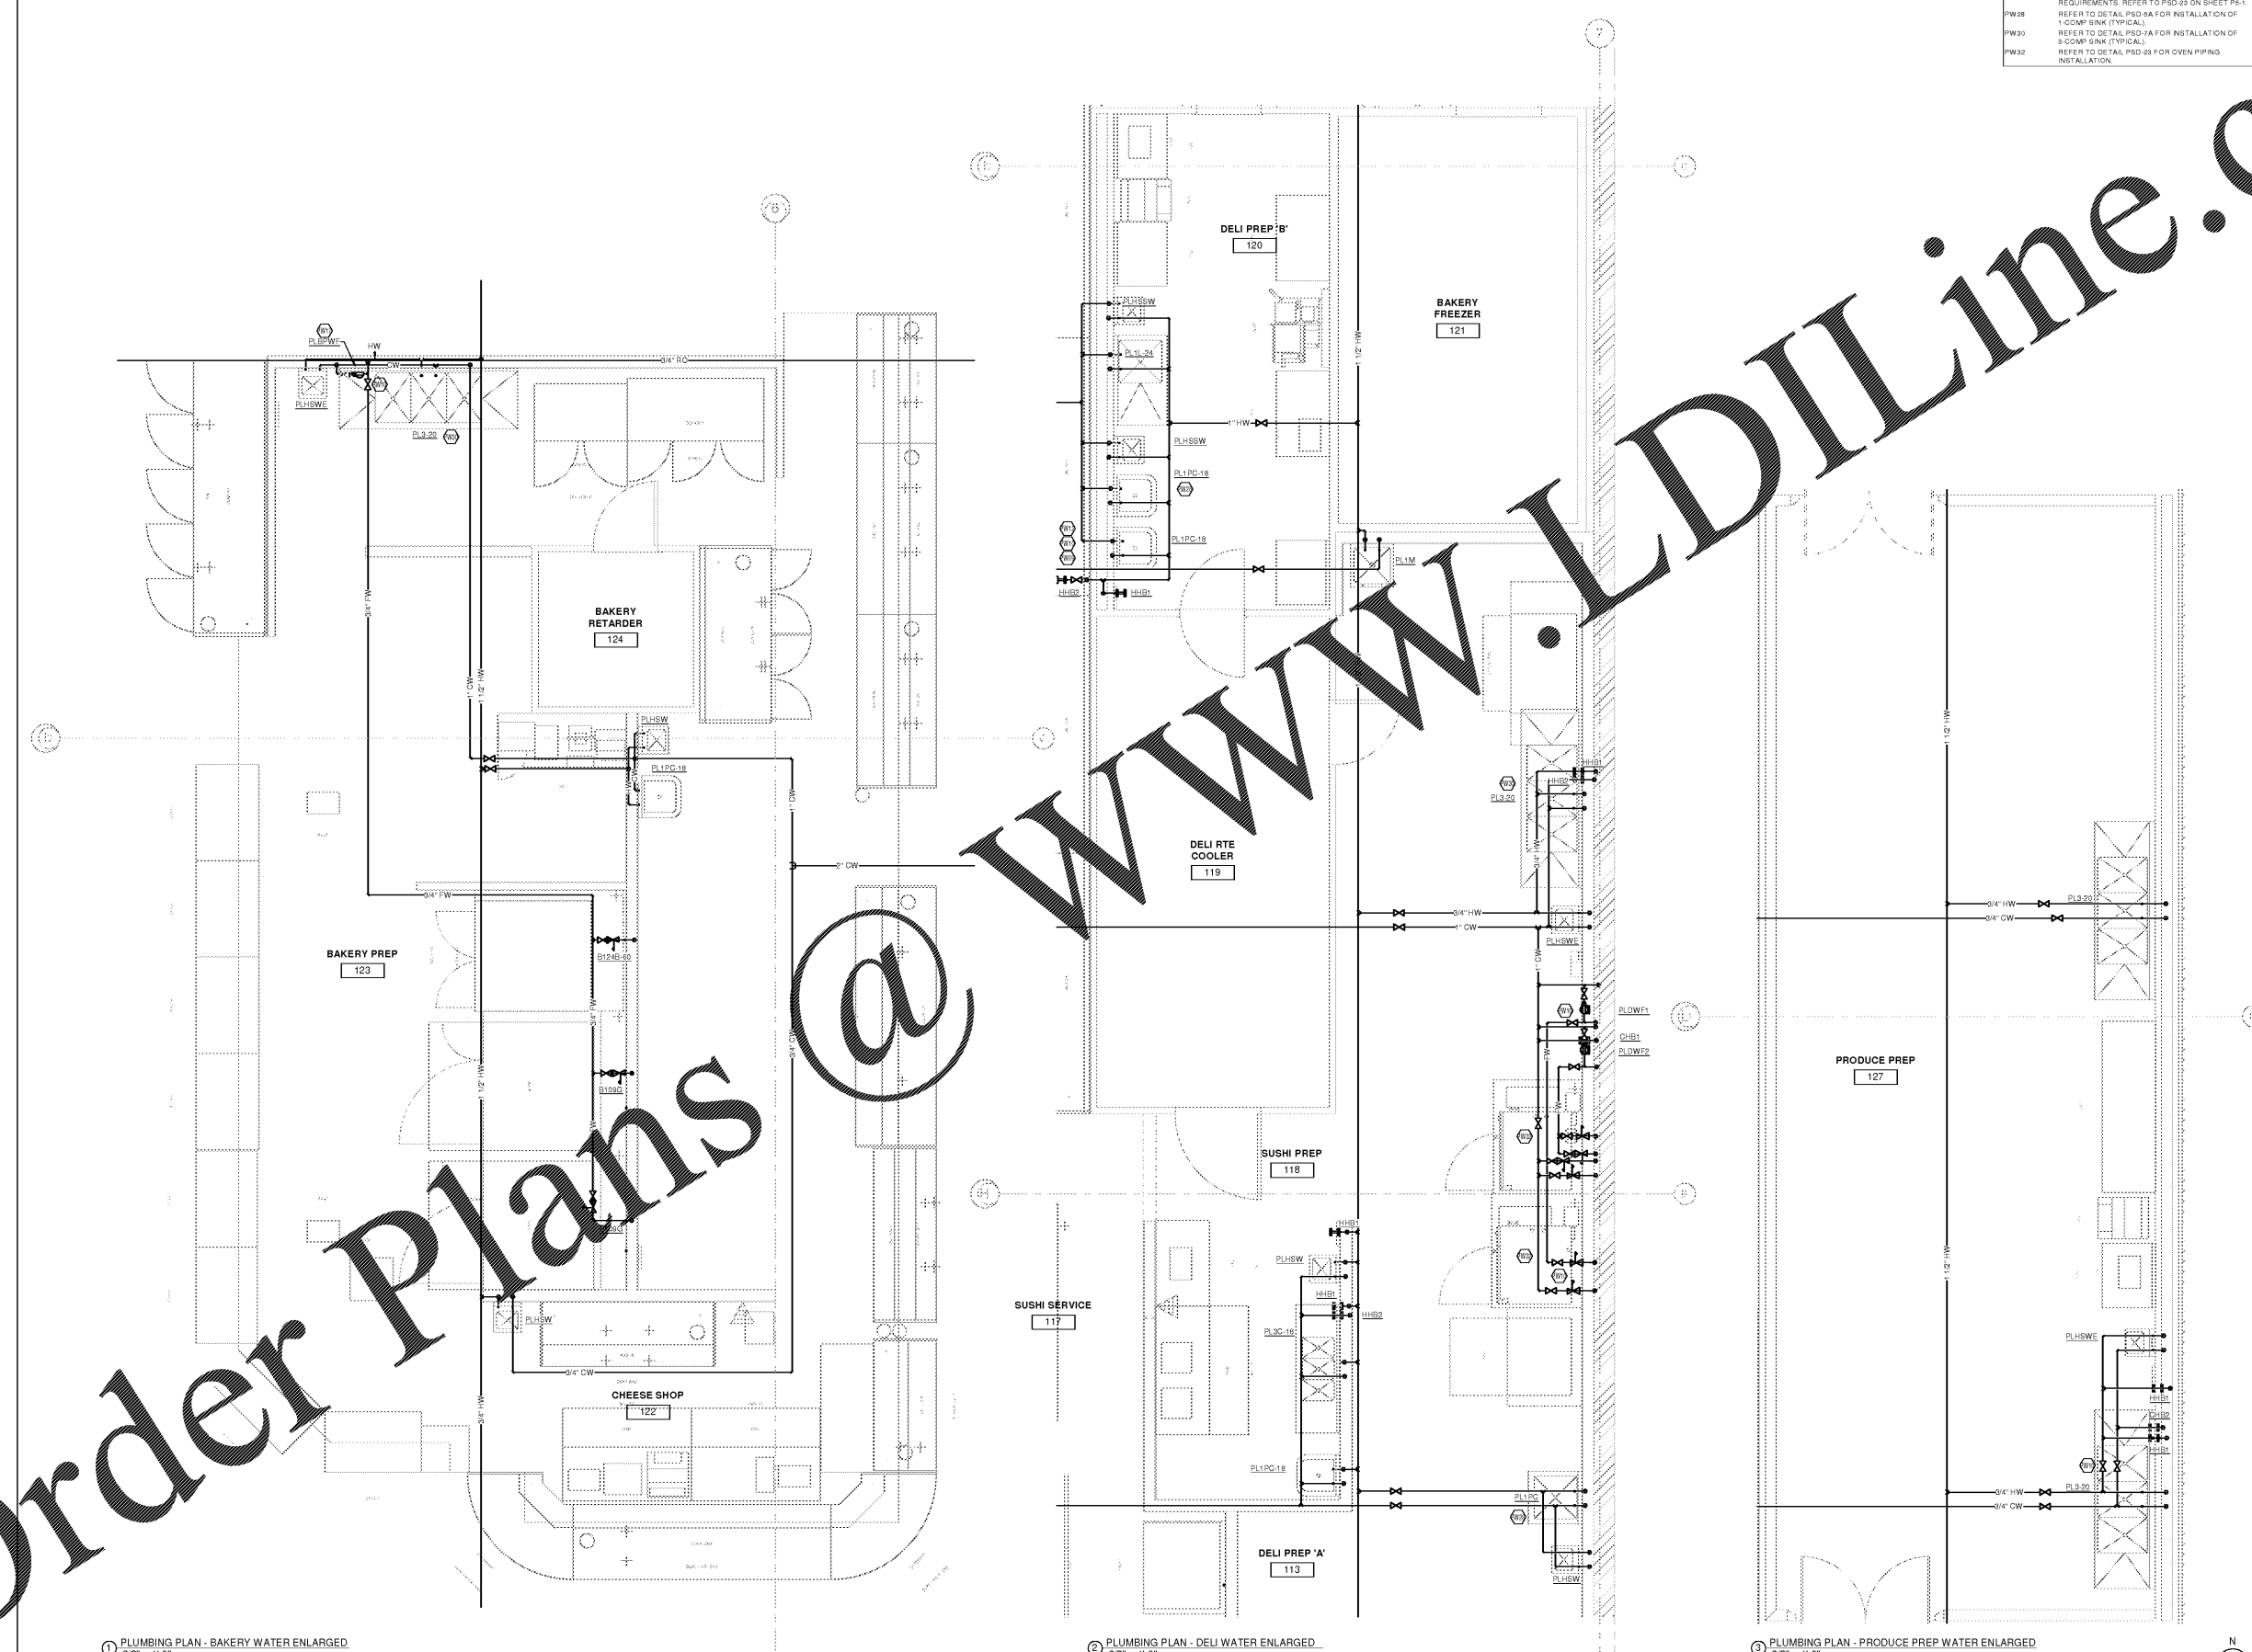

1 PLUMBING PLAN - BAKERY WATER ENLARGED
 3/8" = 1'-0"

2 PLUMBING PLAN - DELI WATER ENLARGED
 3/8" = 1'-0"

3 PLUMBING PLAN - PRODUCE PREP WATER ENLARGED
 3/8" = 1'-0"



2" REFERENCE LINE

OWNERSHIP OF INSTRUMENTS OF SERVICE
 All rights, claims, specifications, conditions, terms, or fees, held in common law, statutory and other reserved rights, including without limitation, the copyright therein, shall remain the property of the Consultant. No part of this document may be reproduced or transmitted in any form or by any means, electronic, mechanical, photocopying, recording, or by any information storage and retrieval system, without the prior written permission of the Consultant. The Consultant's liability shall be limited to the amount of the fee paid to the Consultant.
 11/10/2018 2:08:59 PM

Order Plans @ WWW.LDILine.com