


DECOR COORDINATION NOTE
 ALL SPECIALTY LIGHTING TO BE COORDINATED WITH DECOR AFTER DECOR IS INSTALLED. INITIAL ROUGH-IN MAY BE DONE PRIOR TO DECOR INSTALLATION. INITIAL ROUGH-IN CONSISTS OF ELECTRICAL CONDUITS, PULLBOXES, JUNCTION BOXES IN THE CEILING/JOIST SPACE FOR DECOR LIGHTING AND WIRING TO JUNCTION BOXES. ALL LIGHTING SUPPORTS, MC CABLE WHIPS, FINAL CONNECTIONS, ETC TO BE COMPLETED AFTER DECOR HAS BEEN INSTALLED. FAILURE TO INSTALL DECOR LIGHTING IN THIS MANNER WILL RESULT IN REWORK WHICH WILL NOT BE AWARDED A CHANGE ORDER PROPOSAL.

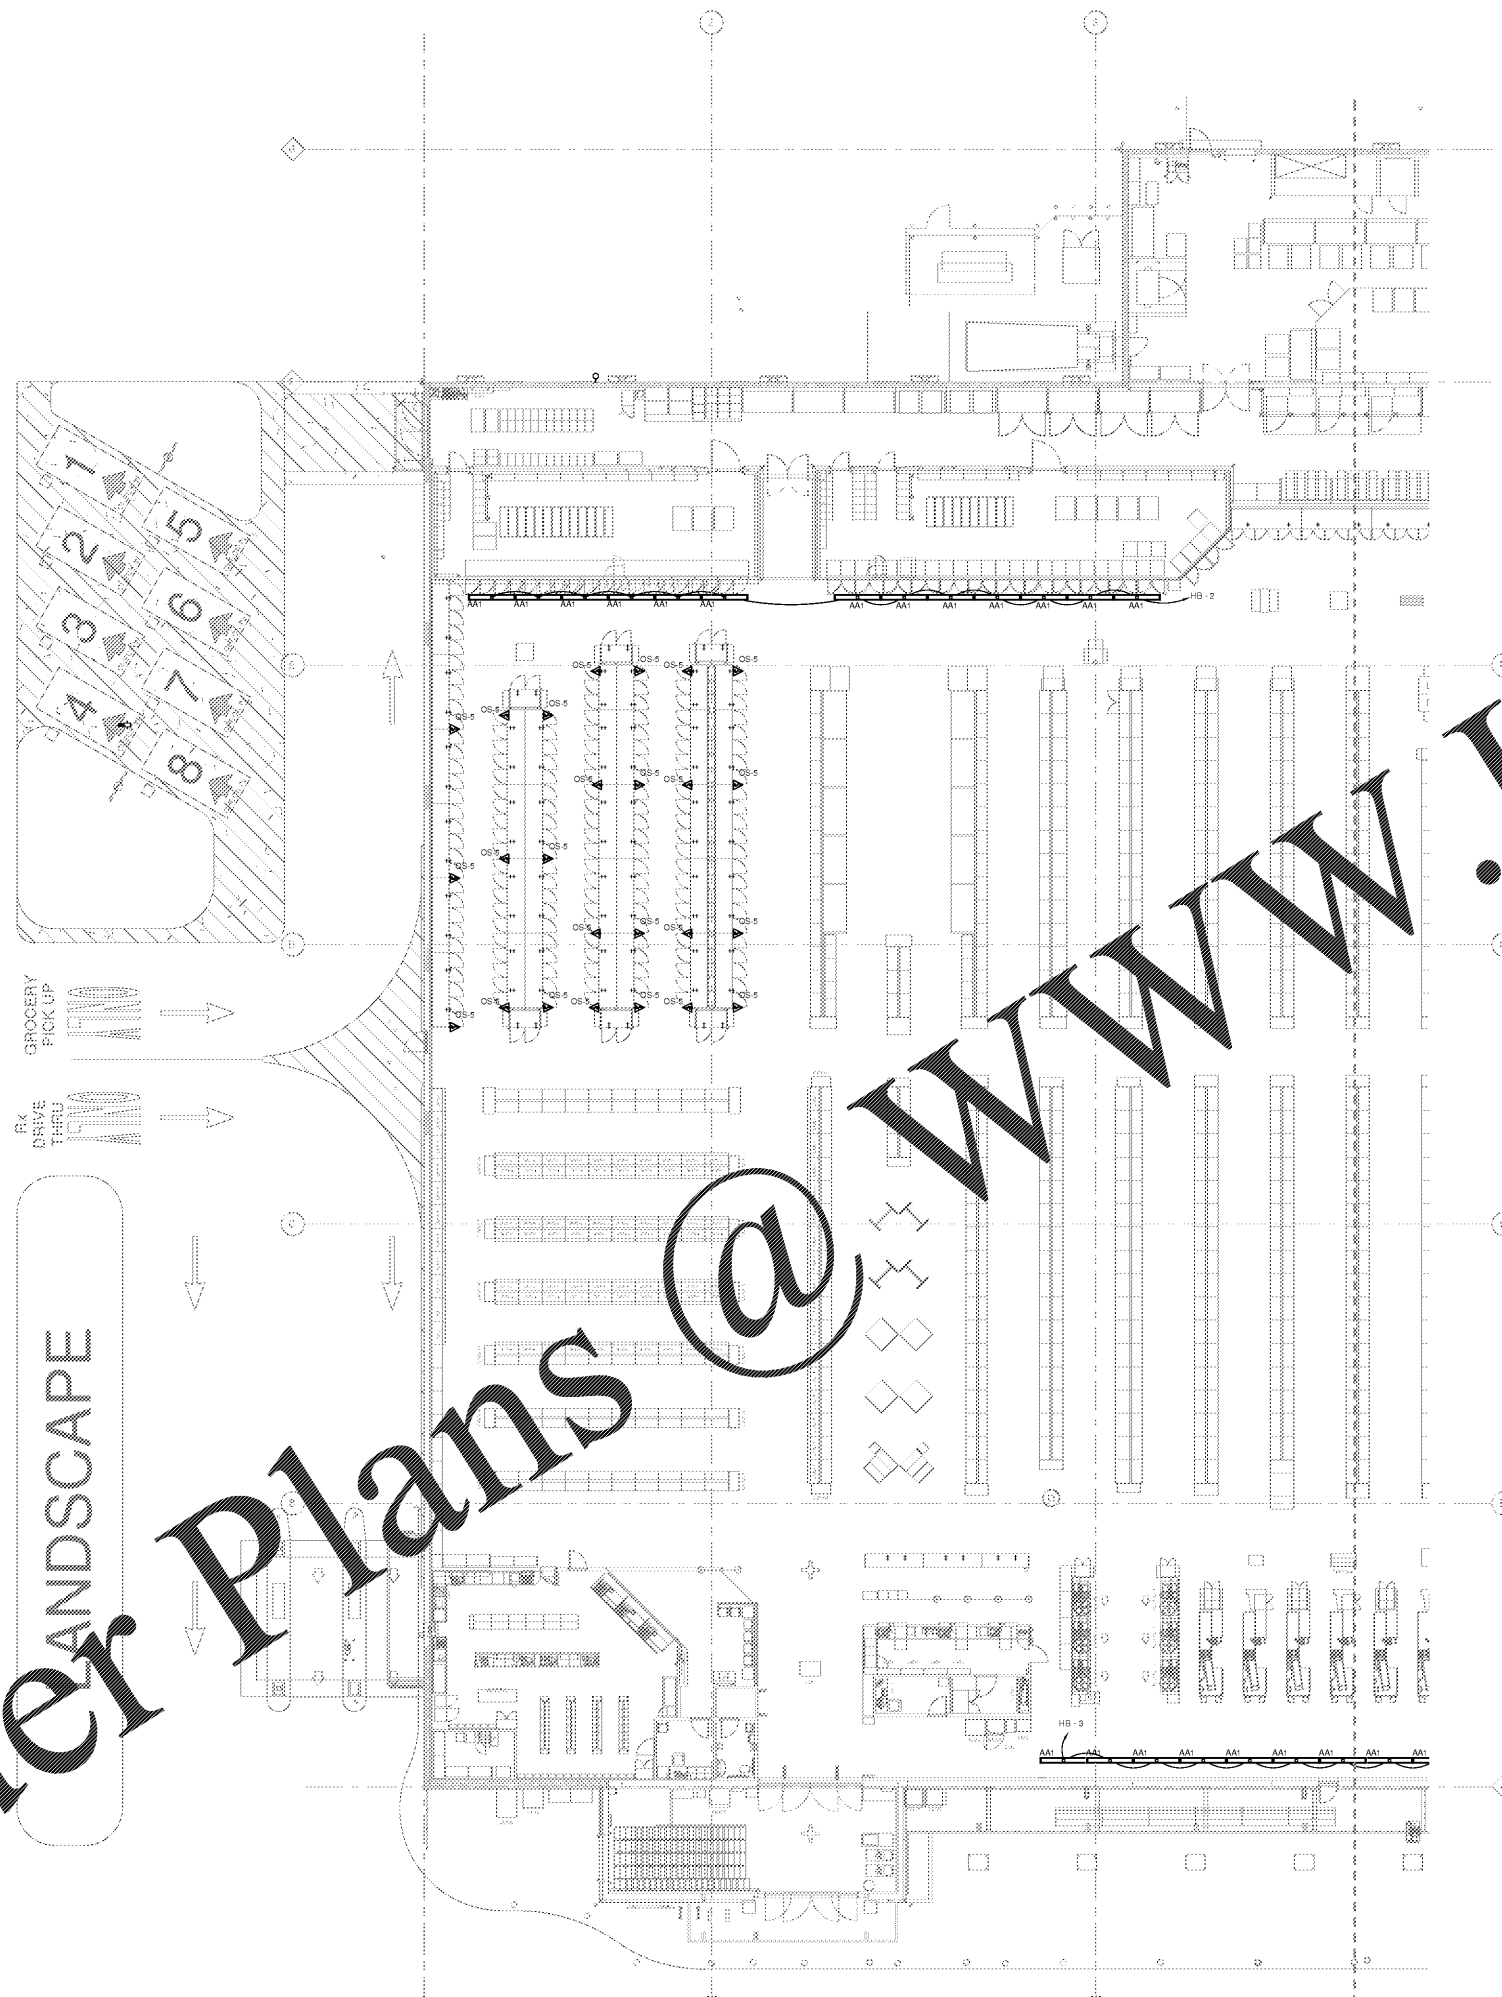

CONSULTANT OF RECORD FOR ELECTRICAL AND MECHANICAL SYSTEMS AND INSTRUMENTS PROVIDED BY THE CONSULTANT AS INSTRUMENTS OF SERVICE. ALL RIGHTS ARE RESERVED. THIS DOCUMENT IS THE PROPERTY OF THE CONSULTANT AND IS NOT TO BE REPRODUCED OR TRANSMITTED IN ANY FORM OR BY ANY MEANS, ELECTRONIC OR MECHANICAL, INCLUDING PHOTOCOPYING, RECORDING, OR BY ANY INFORMATION STORAGE AND RETRIEVAL SYSTEM, WITHOUT THE WRITTEN PERMISSION OF THE CONSULTANT. THE CONSULTANT ASSUMES NO LIABILITY FOR ANY DAMAGE, INCLUDING CONSEQUENTIAL DAMAGES, ARISING FROM THE USE OF THIS DOCUMENT.

11/10/2018 2:28:58 PM
 SPECIALTY LIGHTING PLAN AND DETAILS - WEST
 3/32" = 1'-0"

2" REFERENCE LINE

CR
 architecture + design
 creating extraordinary places
 www.cr-architects.com
 500-490-6842

MECHANICAL/ELECTRICAL ENGINEERS
 WWW.KHENGERS.COM
 LEWINGTON, KENTUCKY
 LOUISVILLE, KENTUCKY
 NEW YORK, NEW YORK

OWNER

DATE	REVISION
10/25/2018	5% OWNER REVIEW
11/01/2018	100% B/PERMIT

PROJECT TITLE
KROGER STORE R543
 MERCURY BLVD.
 HAMPTON, VA

COMMISSIONING: 517315
 ISSUE DATE: 10/23/2018
 SHEET TITLE
SPECIALTY LIGHTING PLAN AND DETAILS - WEST

SHEET NO.
E1.2a
 ©2019 Architecture + Design, Inc.

Order Plans @ www.LDILine.com